
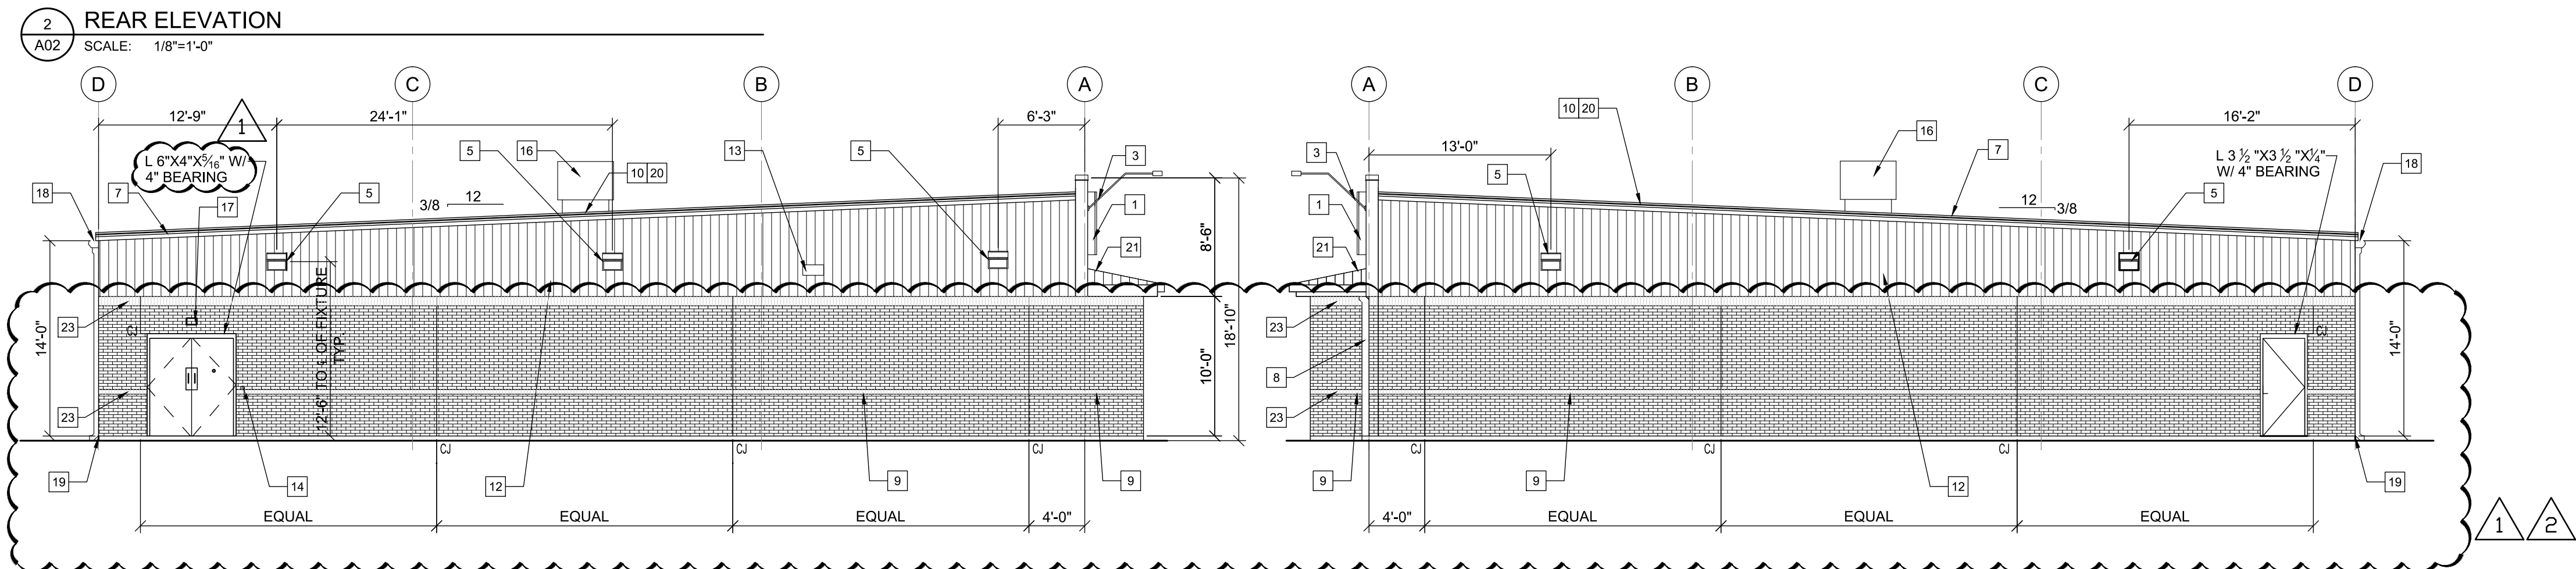
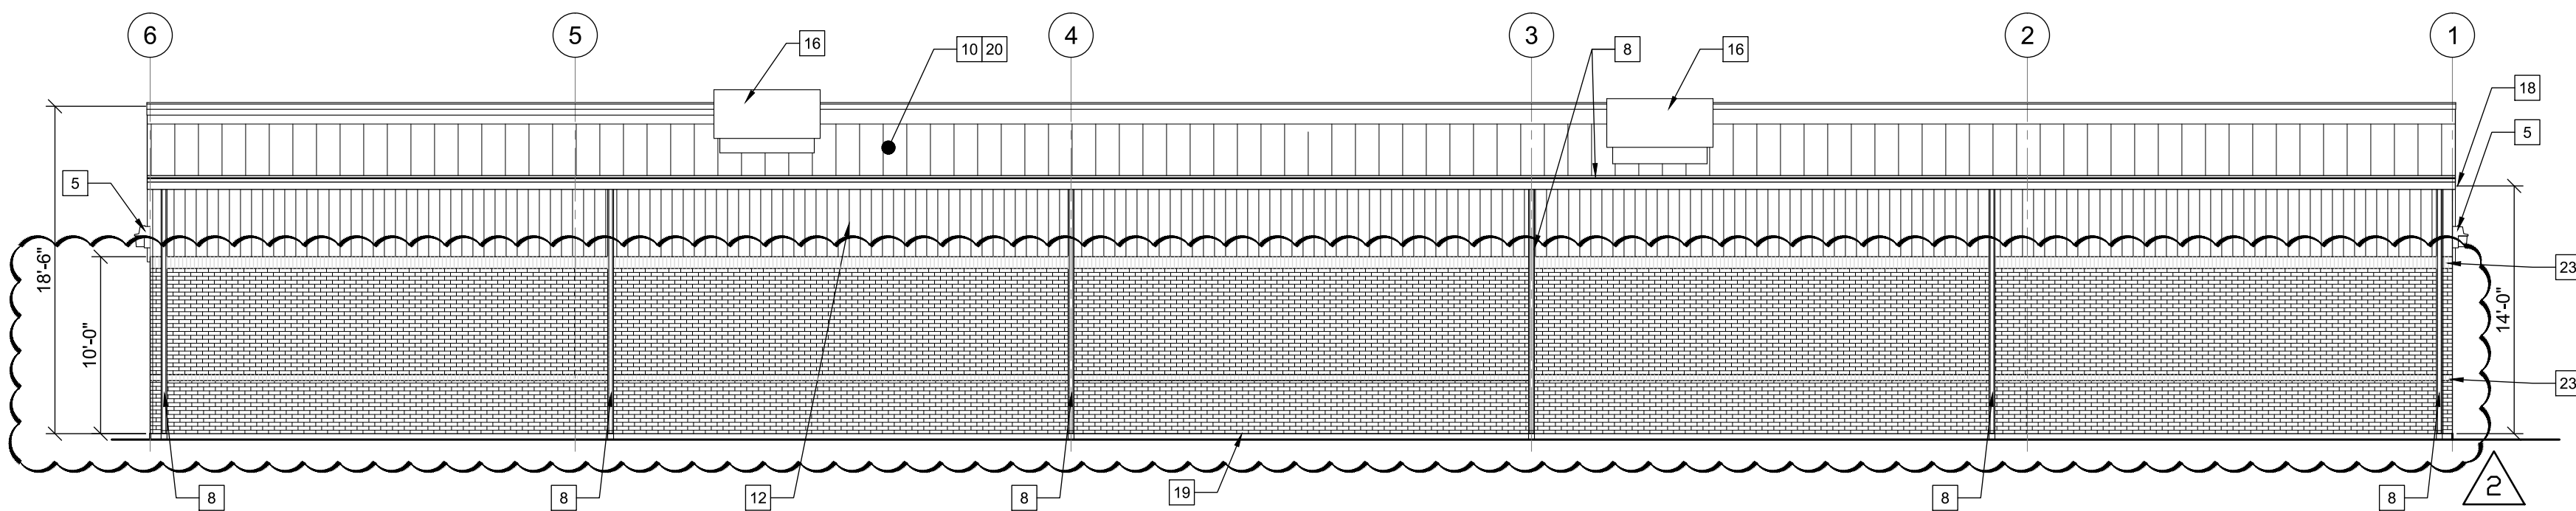



PRE-ENGINEERED METAL BUILDING VENDOR	VP BUILDINGS ATTN: DAVID ENGLISH (901) 748-6103					STAR BUILDING SYSTEMS ATTN: RODNEY BURT (800) 879-7827					NUCOR BUILDING SYSTEMS ATTN: BOB BARRY (315) 622-4440 (260) 937-7891					BIG BEE STEEL BUILDINGS, INC. ATTN: KEVIN BUSLER (800) 633-3378					CHIEF BUILDINGS ATTN: ERIN SULLIVAN (308) 385-4628 (308) 390-8199						
EXTERIOR FINISHES																											
EXTERIOR FINISHES ARE TO MATCH OR BE EQUAL TO VP METAL BUILDING SYSTEM'S FINISH SELECTION.																											
GUTTERS	●					●					●					●					●						
DOWN SPOUTS	●					●					●					●					●						
SIDE AND REAR METAL WALL PANELS & TRIM, RECEIVING & EMERGENCY EXIT DOORS (EXTERIOR OF DOORS TO BE PAINTED, REFER TO DOOR SCHEDULE)	●					●					●					●					●						
BRICK VENEER	TO BE SELECTED BY OWNER AND APPROVED BY DOLLAR GENERAL																										
BRICK ROWLOCK COURSE	TO BE SELECTED BY OWNER AND APPROVED BY DOLLAR GENERAL																										
BRICK SOLDIER COURSE	TO BE SELECTED BY OWNER AND APPROVED BY DOLLAR GENERAL																										
FLAT METAL SOFFIT AT STOREFRONT VESTIBULE AREA				●					●					●					●					●			
BUILDING PARAPET WALL AND CANOPY		●					●				●					●					●				●		
STOREFRONT SYSTEM			●					●									●							●			
STANDING SEAM METAL ROOF PANELS AND BUILDING PARAPET AT ROOF SIDE					●				●						●					●					●		
LINER PANELS (INTERIOR SALES AND RECEIVING FLOOR)				●					●								●				●				●		

- NOTE:
- REFER TO SHEET T-1 FOR ADDITIONAL INFORMATION ON RECOMMENDED NATIONAL ACCOUNT VENDORS.
 - NATIONAL ACCOUNT AND CONTACT INFORMATION SUBJECT TO CHANGE.

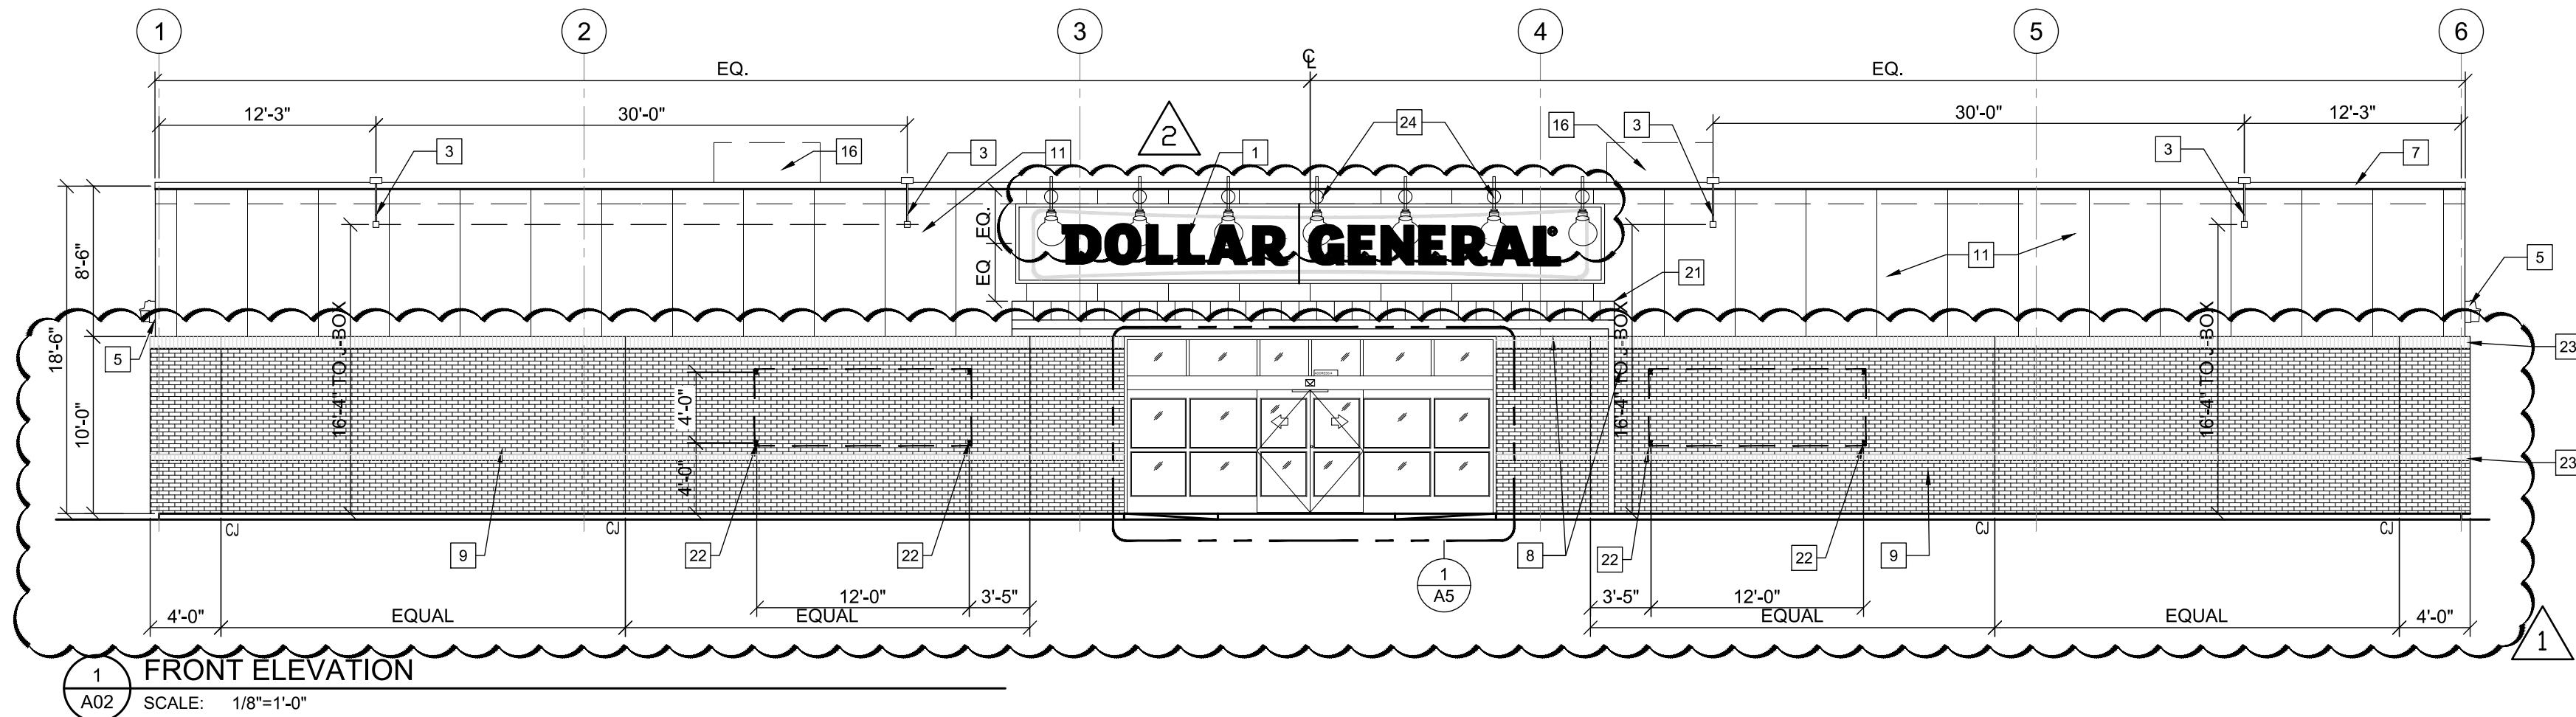

ELEVATION KEYED NOTES

- SIGN FURNISHED AND INSTALLED BY DOLLAR GENERAL CORP. WITH CIRCUIT AS NOTED ON ELECTRICAL PLAN. COORDINATE LOCATION OF SIGN W/ D.G. PM. CONTRACTOR IS TO PROVIDE ADEQUATE BLOCKING AS REQUIRED BY SIGN MANUFACTURER TO SUPPORT SIGN WEIGHT OF UP TO 1400 LBS. EXTERIOR CANOPY SIGN SHALL BE SUPPORTED BY THE FACE OF THE CANOPY. COORDINATE THE PROPER SIGNAGE TO BE USED WITH DOLLAR GENERAL.
- NOT USED.
- FLOOD LIGHT. REFER TO ELEC. DRAWINGS FOR ADDITIONAL INFO.
- NOT USED.
- WALL PACK. REFER TO ELECTRICAL DRAWINGS FOR ADDITIONAL INFORMATION.
- NOT USED.
- TRIM - SEE EXTERIOR FINISH SCHEDULE FOR COLOR.
- GUTTER AND DOWNSPOUT - SEE EXTERIOR FINISH SCHEDULE FOR COLOR.
- BRICK VENEER MANUFACTURER AND COLOR SELECTED BY OWNER.
- STANDING SEAM METAL ROOF.
- PRE-FINISHED METAL WALL PANELS FOR THE FASCIA AND PARAPET OVER THE ENTRANCE. REVERSE RIB PROFILE.
- PRE-FINISHED METAL WALL PANELS FOR THE SIDE AND REAR OF THE BUILDING. PROVIDE TAMPER-RESISTANT FASTENERS FOR BOTTOM 8'-0".
- VENT FOR BATHROOM EXHAUST. REFER TO MECHANICAL DRAWINGS FOR ADDITIONAL INFORMATION.
- DOOR BUZZER. REFER TO ELECTRICAL DRAWINGS FOR ADDITIONAL INFORMATION.
- NOT USED.
- HVAC UNITS MOUNTED ON ROOF. REFER TO MECHANICAL DRAWINGS FOR MORE INFORMATION.
- OUTSIDE AIR TEMP. SENSOR MOUNTED OVER RECEIVING DOORS @ 8'-0" A.F.F.
- MINIMUM EAVE HEIGHT IS 14'-0" A.F.F.
- FINISHED GRADE AT EXTERIOR WALLS SHALL BE A MINIMUM OF 6" BELOW FINISHED FLOOR AT ALL NON PAVED AREAS.
- IN NORTHERN CLIMATES, PROVIDE SNOW GUARDS ON ROOF PER LOCAL CODE AND ZONE 4 AND ABOVE CLIMATE.
- METAL CANOPY BY PRE-ENGINEERED METAL BUILDING MANUFACTURER.
- 1/2" DIAMETER x 6" LONG STAINLESS STEEL EYE BOLTS (CLOSED) WITH 1" DIAMETER OPENINGS. DRILL AND EPOXY INTO BLOCK WALL. 4 BOLTS TO BE LOCATED AS SHOWN EACH SIDE OF ENTRY. TOTAL OF 8 BOLTS.
- BRICK SOLDIER COURSE AND ROWLOCK COURSE MANUFACTURER AND COLOR SELECTED BY OWNER.
- GOOSE NECK LIGHT FIXTURE FOR SIGNAGE

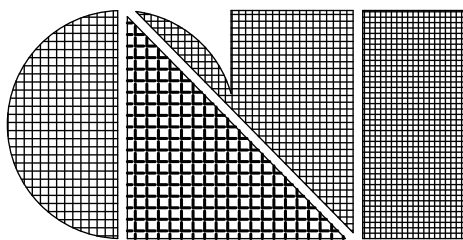

C.L. Helt, Architect Inc.

1136 Greenwood Cliff
Charlotte, NC 28204


Ph. 704-342-1686
Fx. 704-343-0054
E-MAIL INFO@CLHELT.COM

ARCHITECT'S PROJECT # 19032

Project :
DOLLAR GENERAL
FOR
JMB INVESTMENT COMPANY, LLC
SPRING HILL ROAD
STAUNTON, VA
DESIGN BASED ON 2018 PROTOTYPE "C"

Sheet Description :
**EXTERIOR
ELEVATIONS**

Seal

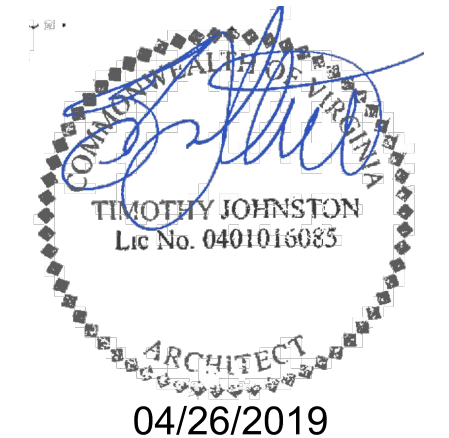

THIS DRAWING AND ITS COPIES ARE THE COPYRIGHT
OF THE ARCHITECT. THEY MAY NOT BE USED FOR
PROJECTS OTHER THAN THE DESIGNATED PROJECT
WITHOUT THE SPECIFIC WRITTEN APPROVAL OF C. L.
HELT ARCHITECT INC., AND OR TIMOTHY JOHNSTON,
ARCHITECT

Drawn By :
B. WOODS

Checked By :
D. MYERS

Revisions :

- | | | |
|---|----------|-----------------|
| 1 | 04-16-19 | ZONING COMMENTS |
| 2 | | |
| 3 | | |
| 4 | | |

Date :
03/29/2019

Sheet No.

A02