

DEPARTMENT OF MENTAL HYGIENE AND HOSPITALS

DR. HIRAM W. DAVIS

COMMISSIONER


WESTERN STATE HOSPITAL

STAUNTON

VIRGINIA


DR. JAMES B. PETTIS

SUPERINTENDENT

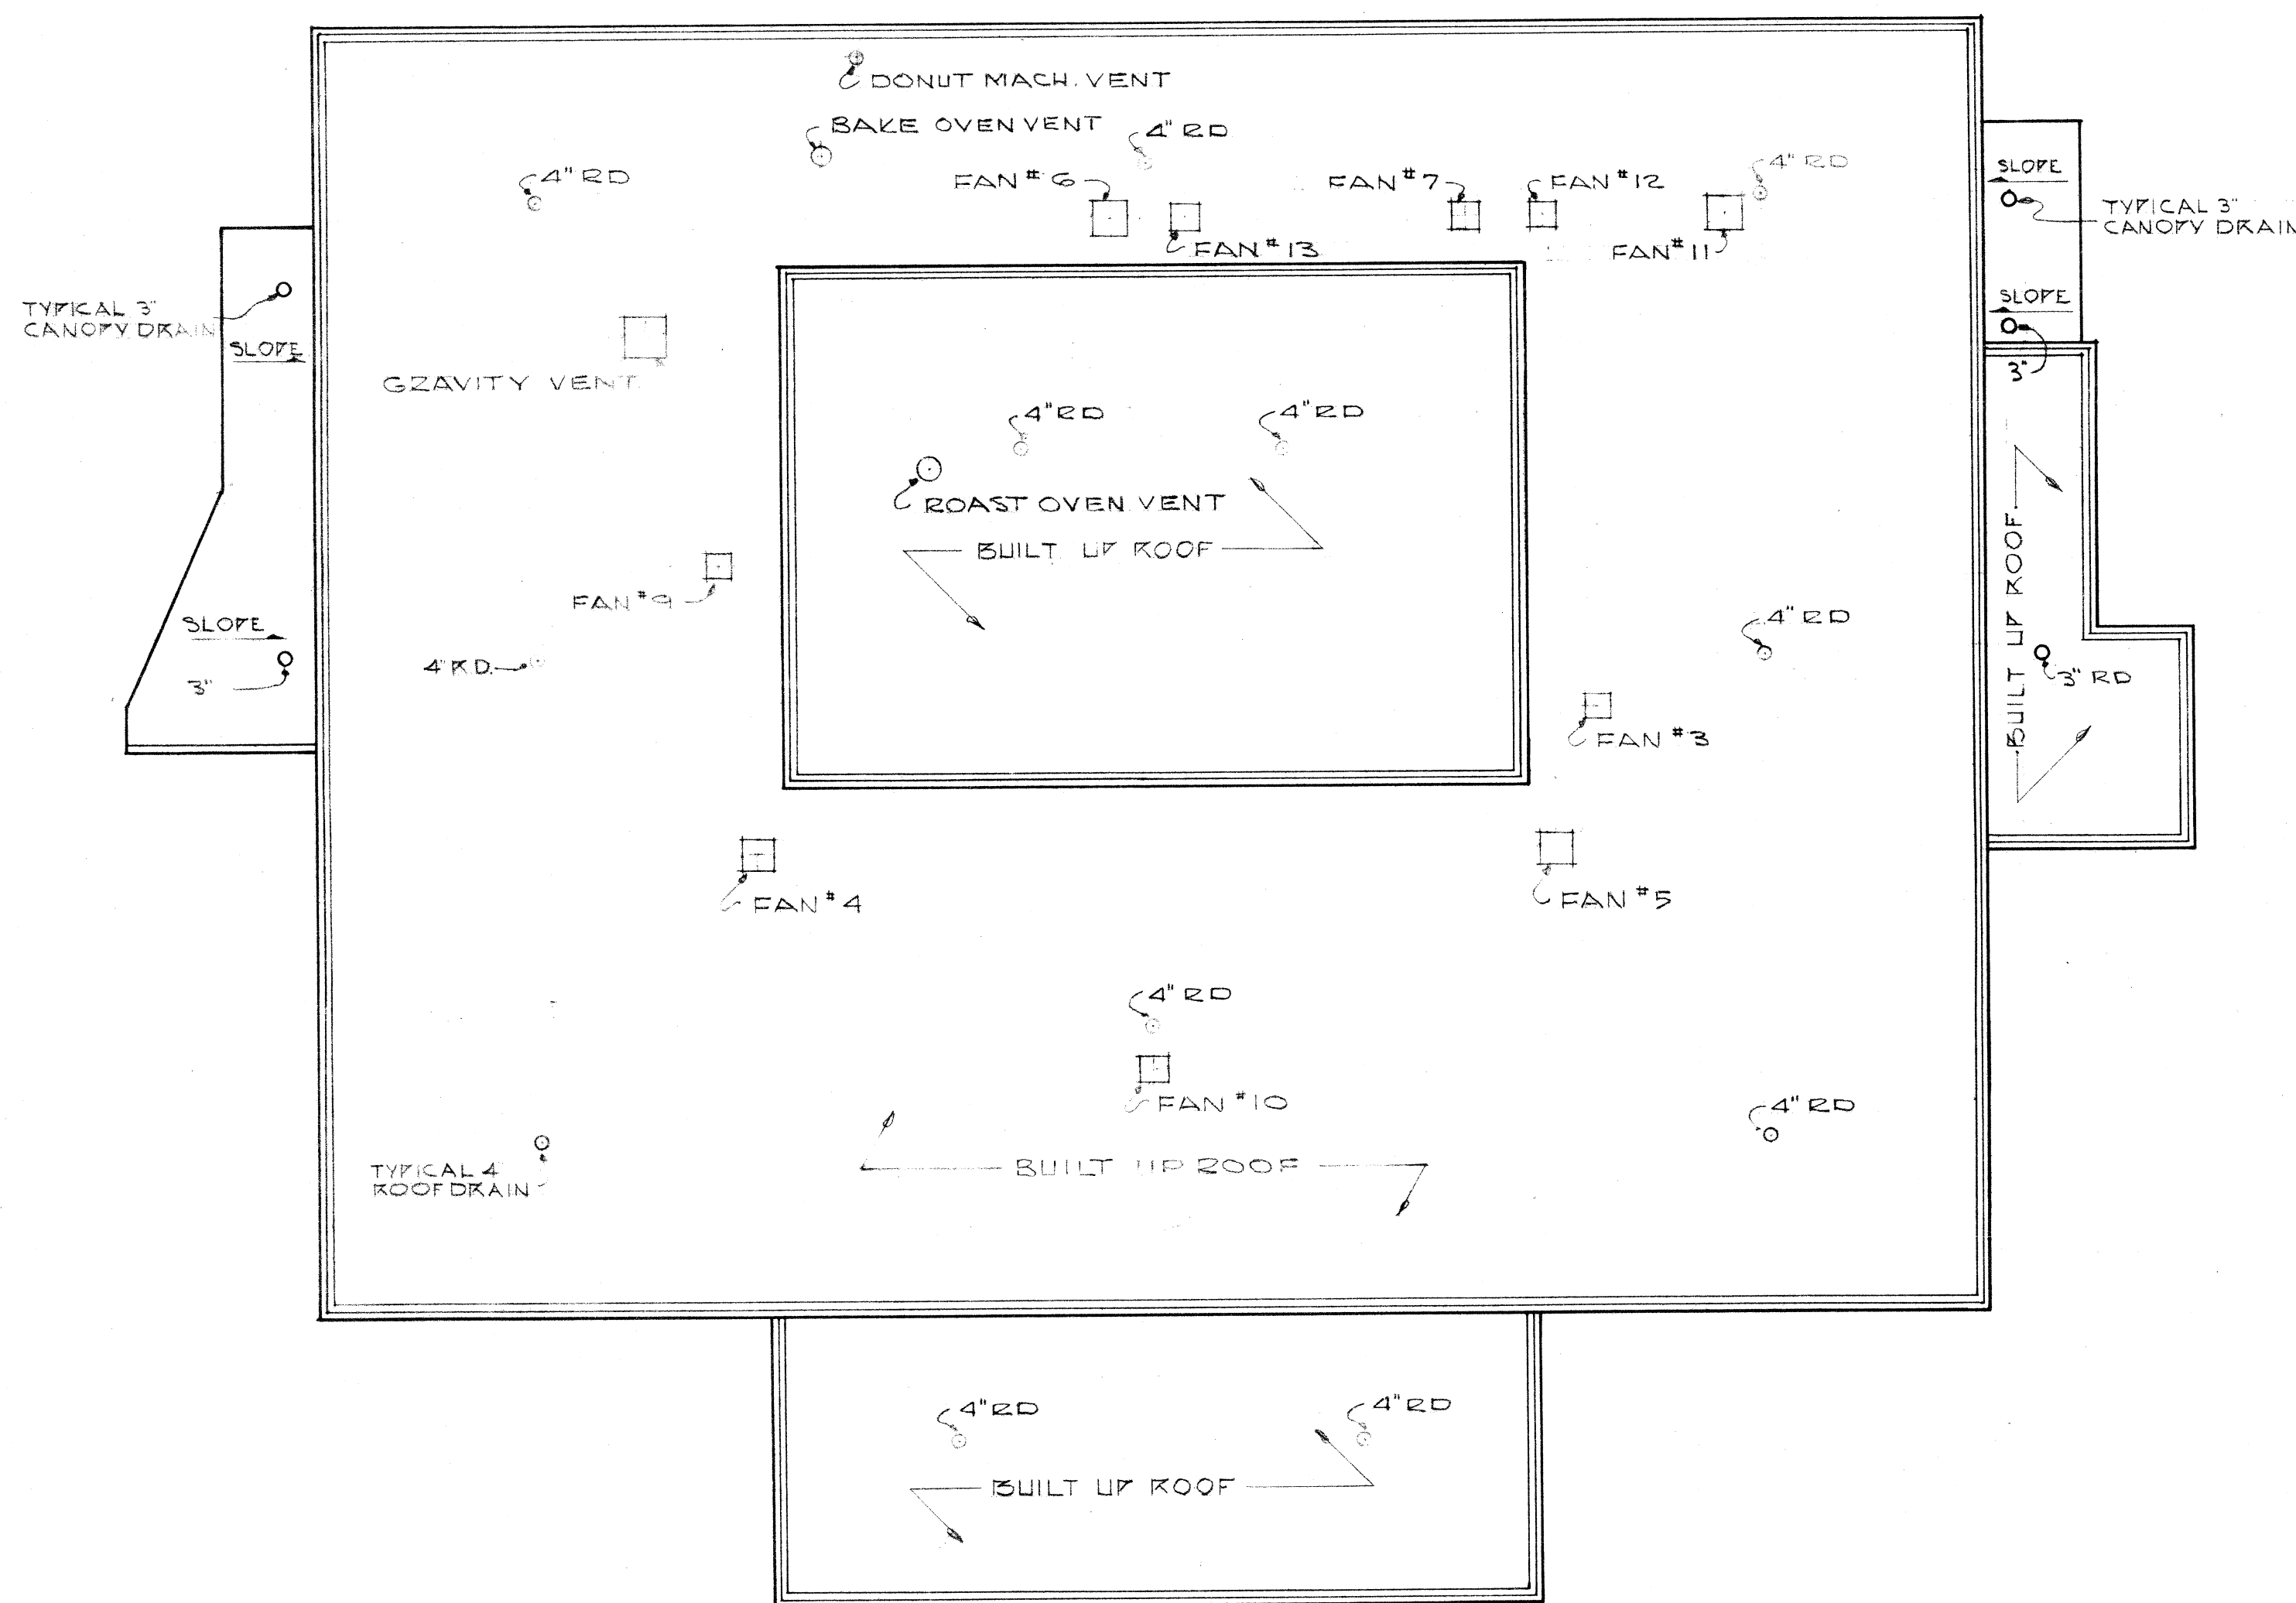

ROOF PLAN
SCALE: 1/16" = 1'-0"

- NOTES:
- (1) AREA LIMITS OF SITE (INCLUDING ROADWAY, PARKING, WALKS) EXCAVATION, FILLING, GRADING HAS BEEN REQUIRED TO OBTAIN NEW GRADE ELEVATIONS INDICATED.
 - (2) SEE PLAN FOR FINISH GRADE AT PERIMETER OF BUILDING.
 - (3) AREA LIMITS OF FINE GRADING & SEEDING (A) AREAS OF ITEM NO. 1 ABOVE INCLUDING ALL NEW AND EXIST. UNSURFACED AREAS.
 - (4) EXTEND TO AND OVERLAP WITH EXIST. GRASSSED AREAS IN VICINITY OF SITE.
 - (5) SEE SH. U-1 FOR ADDITIONAL INFORMATION.
 - (6) OUTSIDE UTILITIES, PARKING AREAS, WALKS, IN MODIFIED BASE BIDS.
 - (7) CONTINUED TREATMENT BUILDING K2-E AND ITS SUPPORTING ROADWAY, PARKING, WALKS, OUTSIDE UTILITIES ARE CONTRACTED FOR AND UNDER CONSTRUCTION.

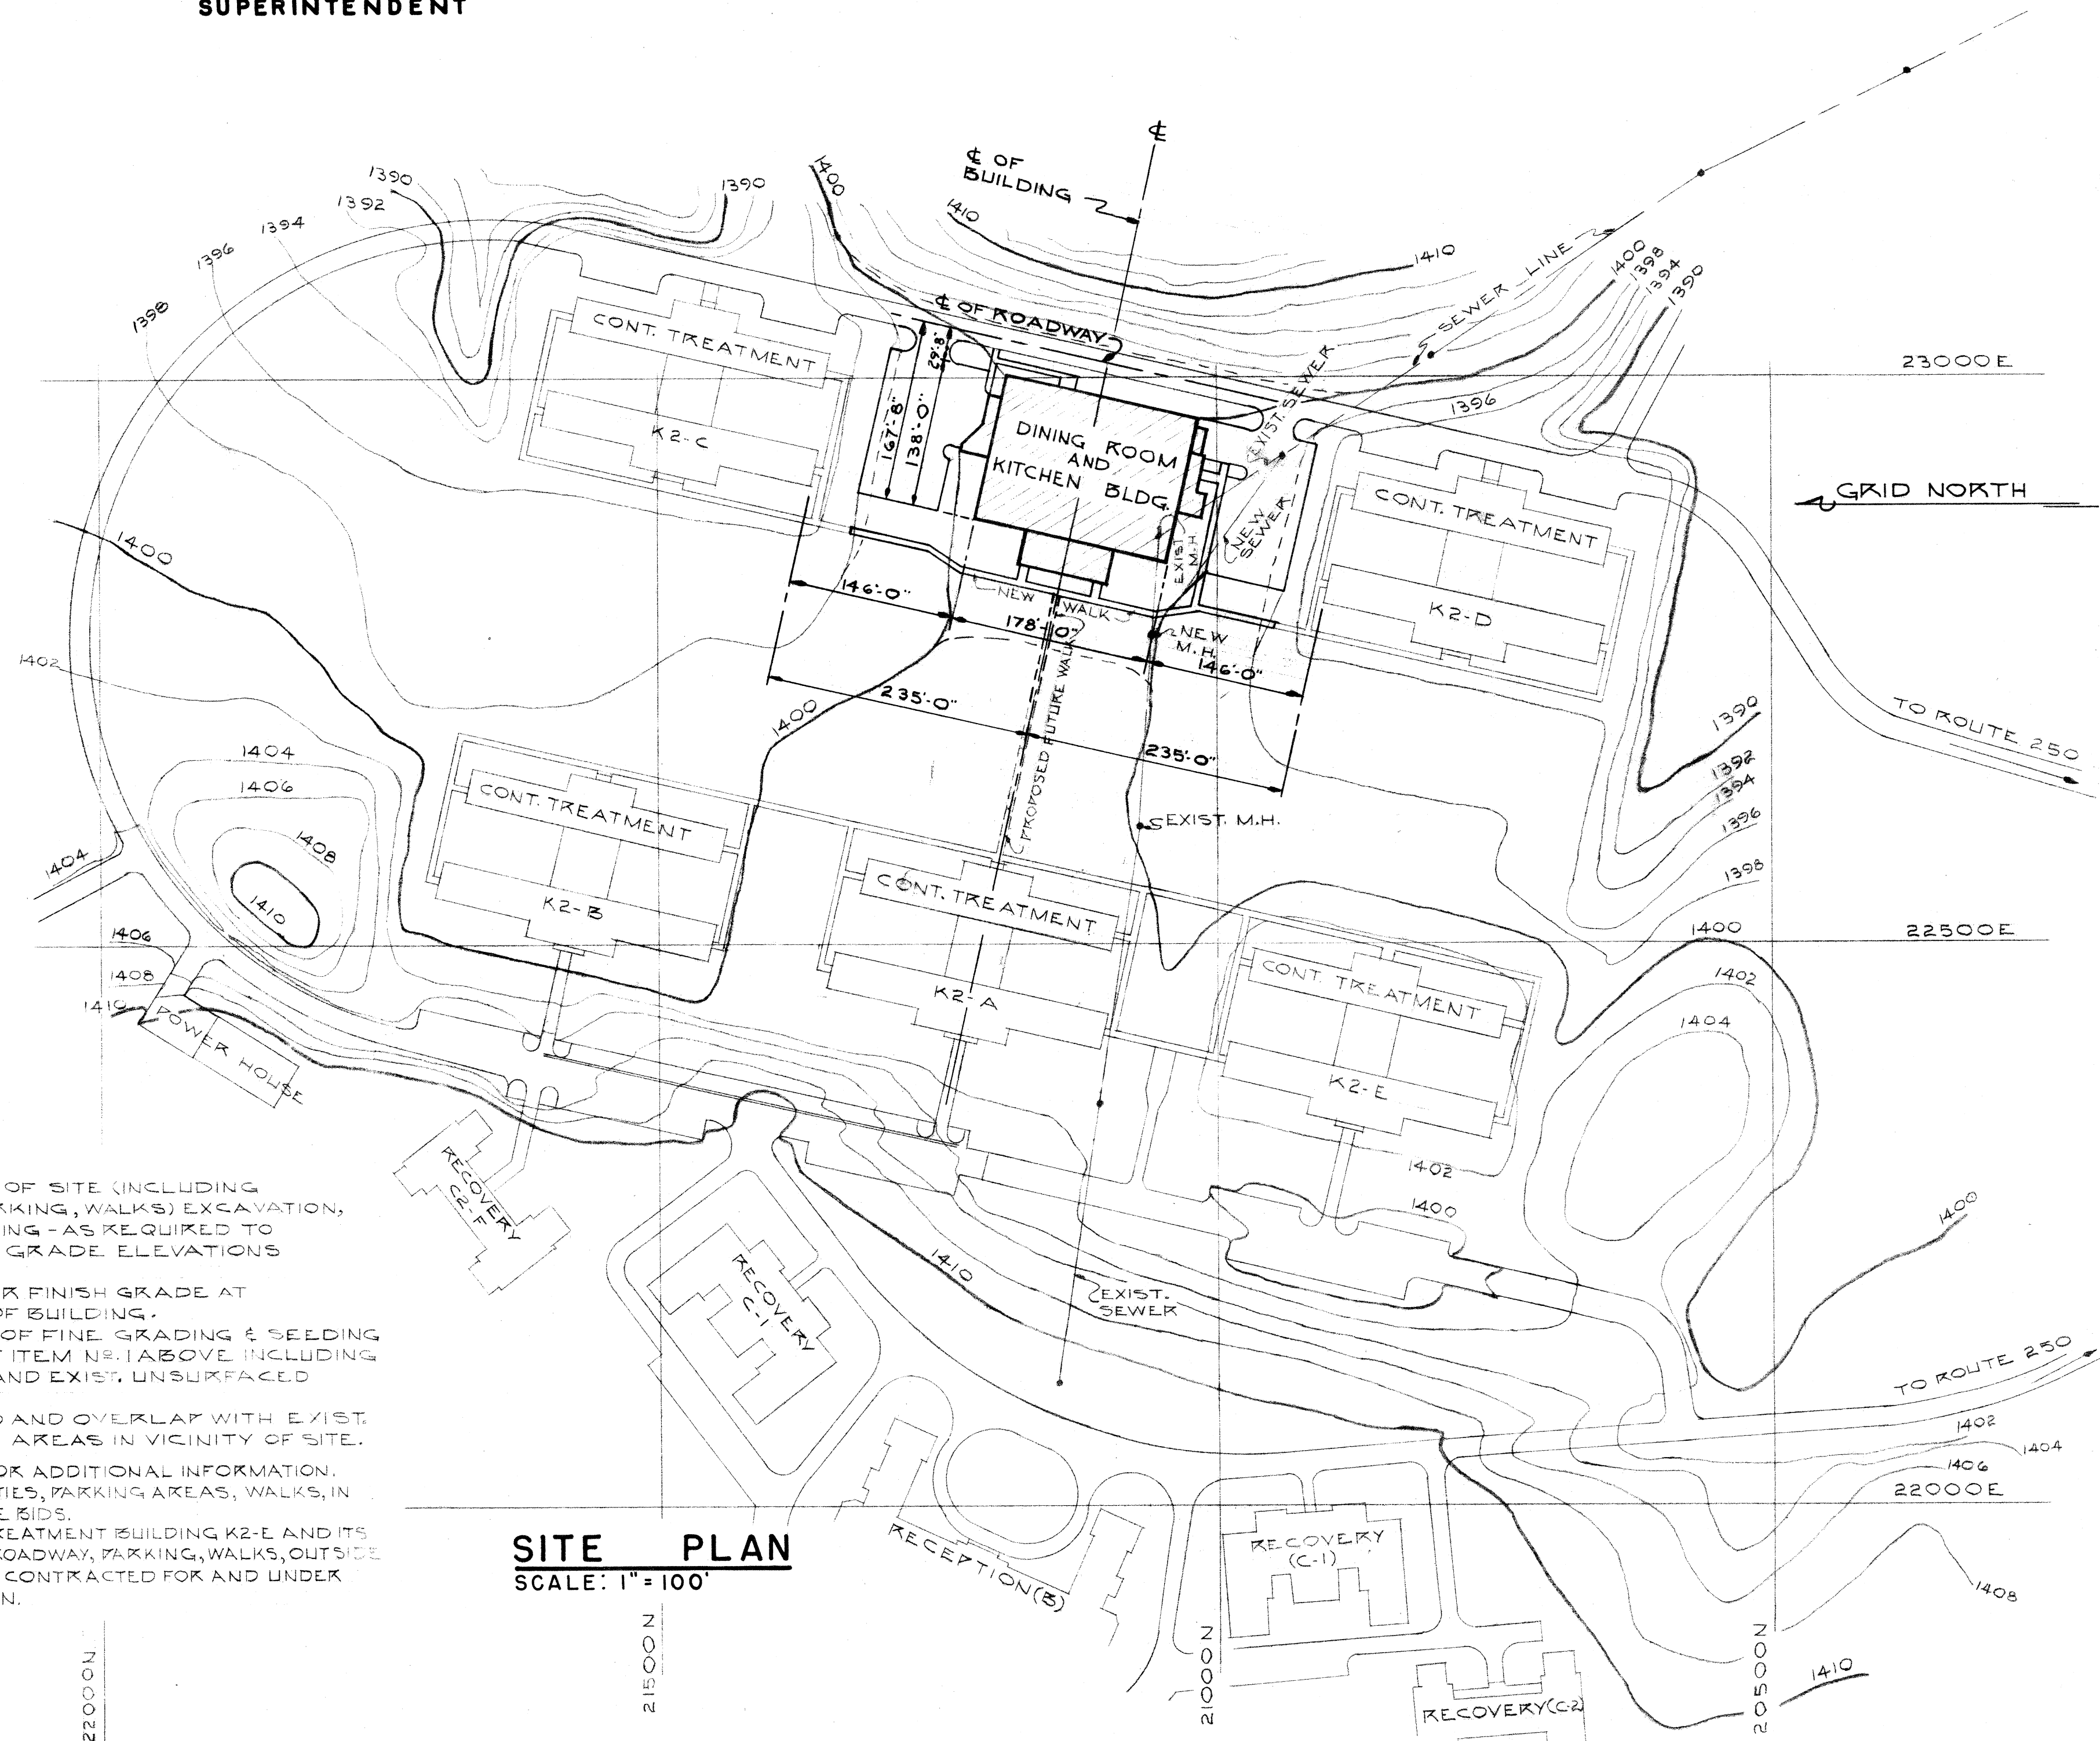

SITE PLAN
SCALE: 1" = 100'

DINING ROOM AND KITCHEN BUILDING, NEW SITE

MARCELLUS WRIGHT & SON
ARCHITECTS - RICHMOND, VIRGINIA

WILEY & WILSON - MECHANICAL ENGINEERS
LYNCHBURG, VIRGINIA

HENRY W. ROBERTS - STRUCTURAL ENGINEER
RICHMOND, VIRGINIA




PROJECT NO 706-36

SEPTEMBER 1961

SOE File No.
706-1191

NOTE:
(1) CONST. JTS SHOWN ON THIS PLAN ARE FOR CONC. SLABS ON GRADE/TOROUS FLOOR FIRST FL. LEVEL, IF TERR. ALT. IS USED, FOUR IN CHECKER BOARD PATTERN AREAS OF FOUR MAY INCREASE TO APPROX. DOUBLE THAT SHOWN IF TERR. IS NOT USED.
(2) SEE SH. 5-1 FOR OTHER REQUIRED CONST. JTS.

  SECTION SCALE: 1/2" = 1'-0"

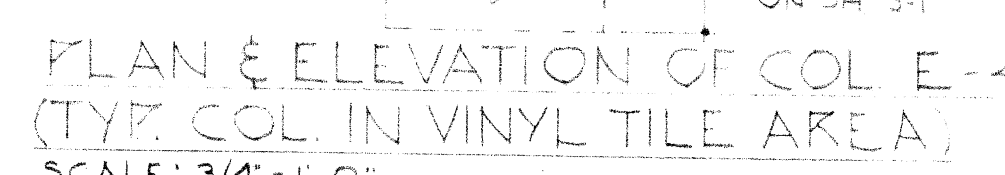

NOTES:

(1) EXTREME CARE MUST BE TAKEN IN PLACING FILL WITHIN BUILDING TO PREVENT OVERTURNING OF WALLS. USE TEMPORARY BRACING WHERE NECESSARY.

(2) DEPRESS BASEMENT AND FIRST FLOOR SLABS ON GROUND AS REQUIRED TO RECEIVE QT OR CT (GENERALLY, DEPRESS 2" FOR CT & 2" FOR QT BELOW TOP OF FINISH FLOOR). SEE FINISH SCHEDULE & DWGS FOR EXACT LOCATIONS.

USE 1/2" DIA. 0" DOWEL
@ CENTER OF EA
PIER. DRILL HOLE
IN ROCK & GROUT
IN BAR


20"

18"

ASSUMED ROCK BEARING
HERE UNDER HEAVY CENTR

ELEV. OF TYP. CONC. PIER IN CRAWL SPACE

SCALE: 3/4" = 1'-0"

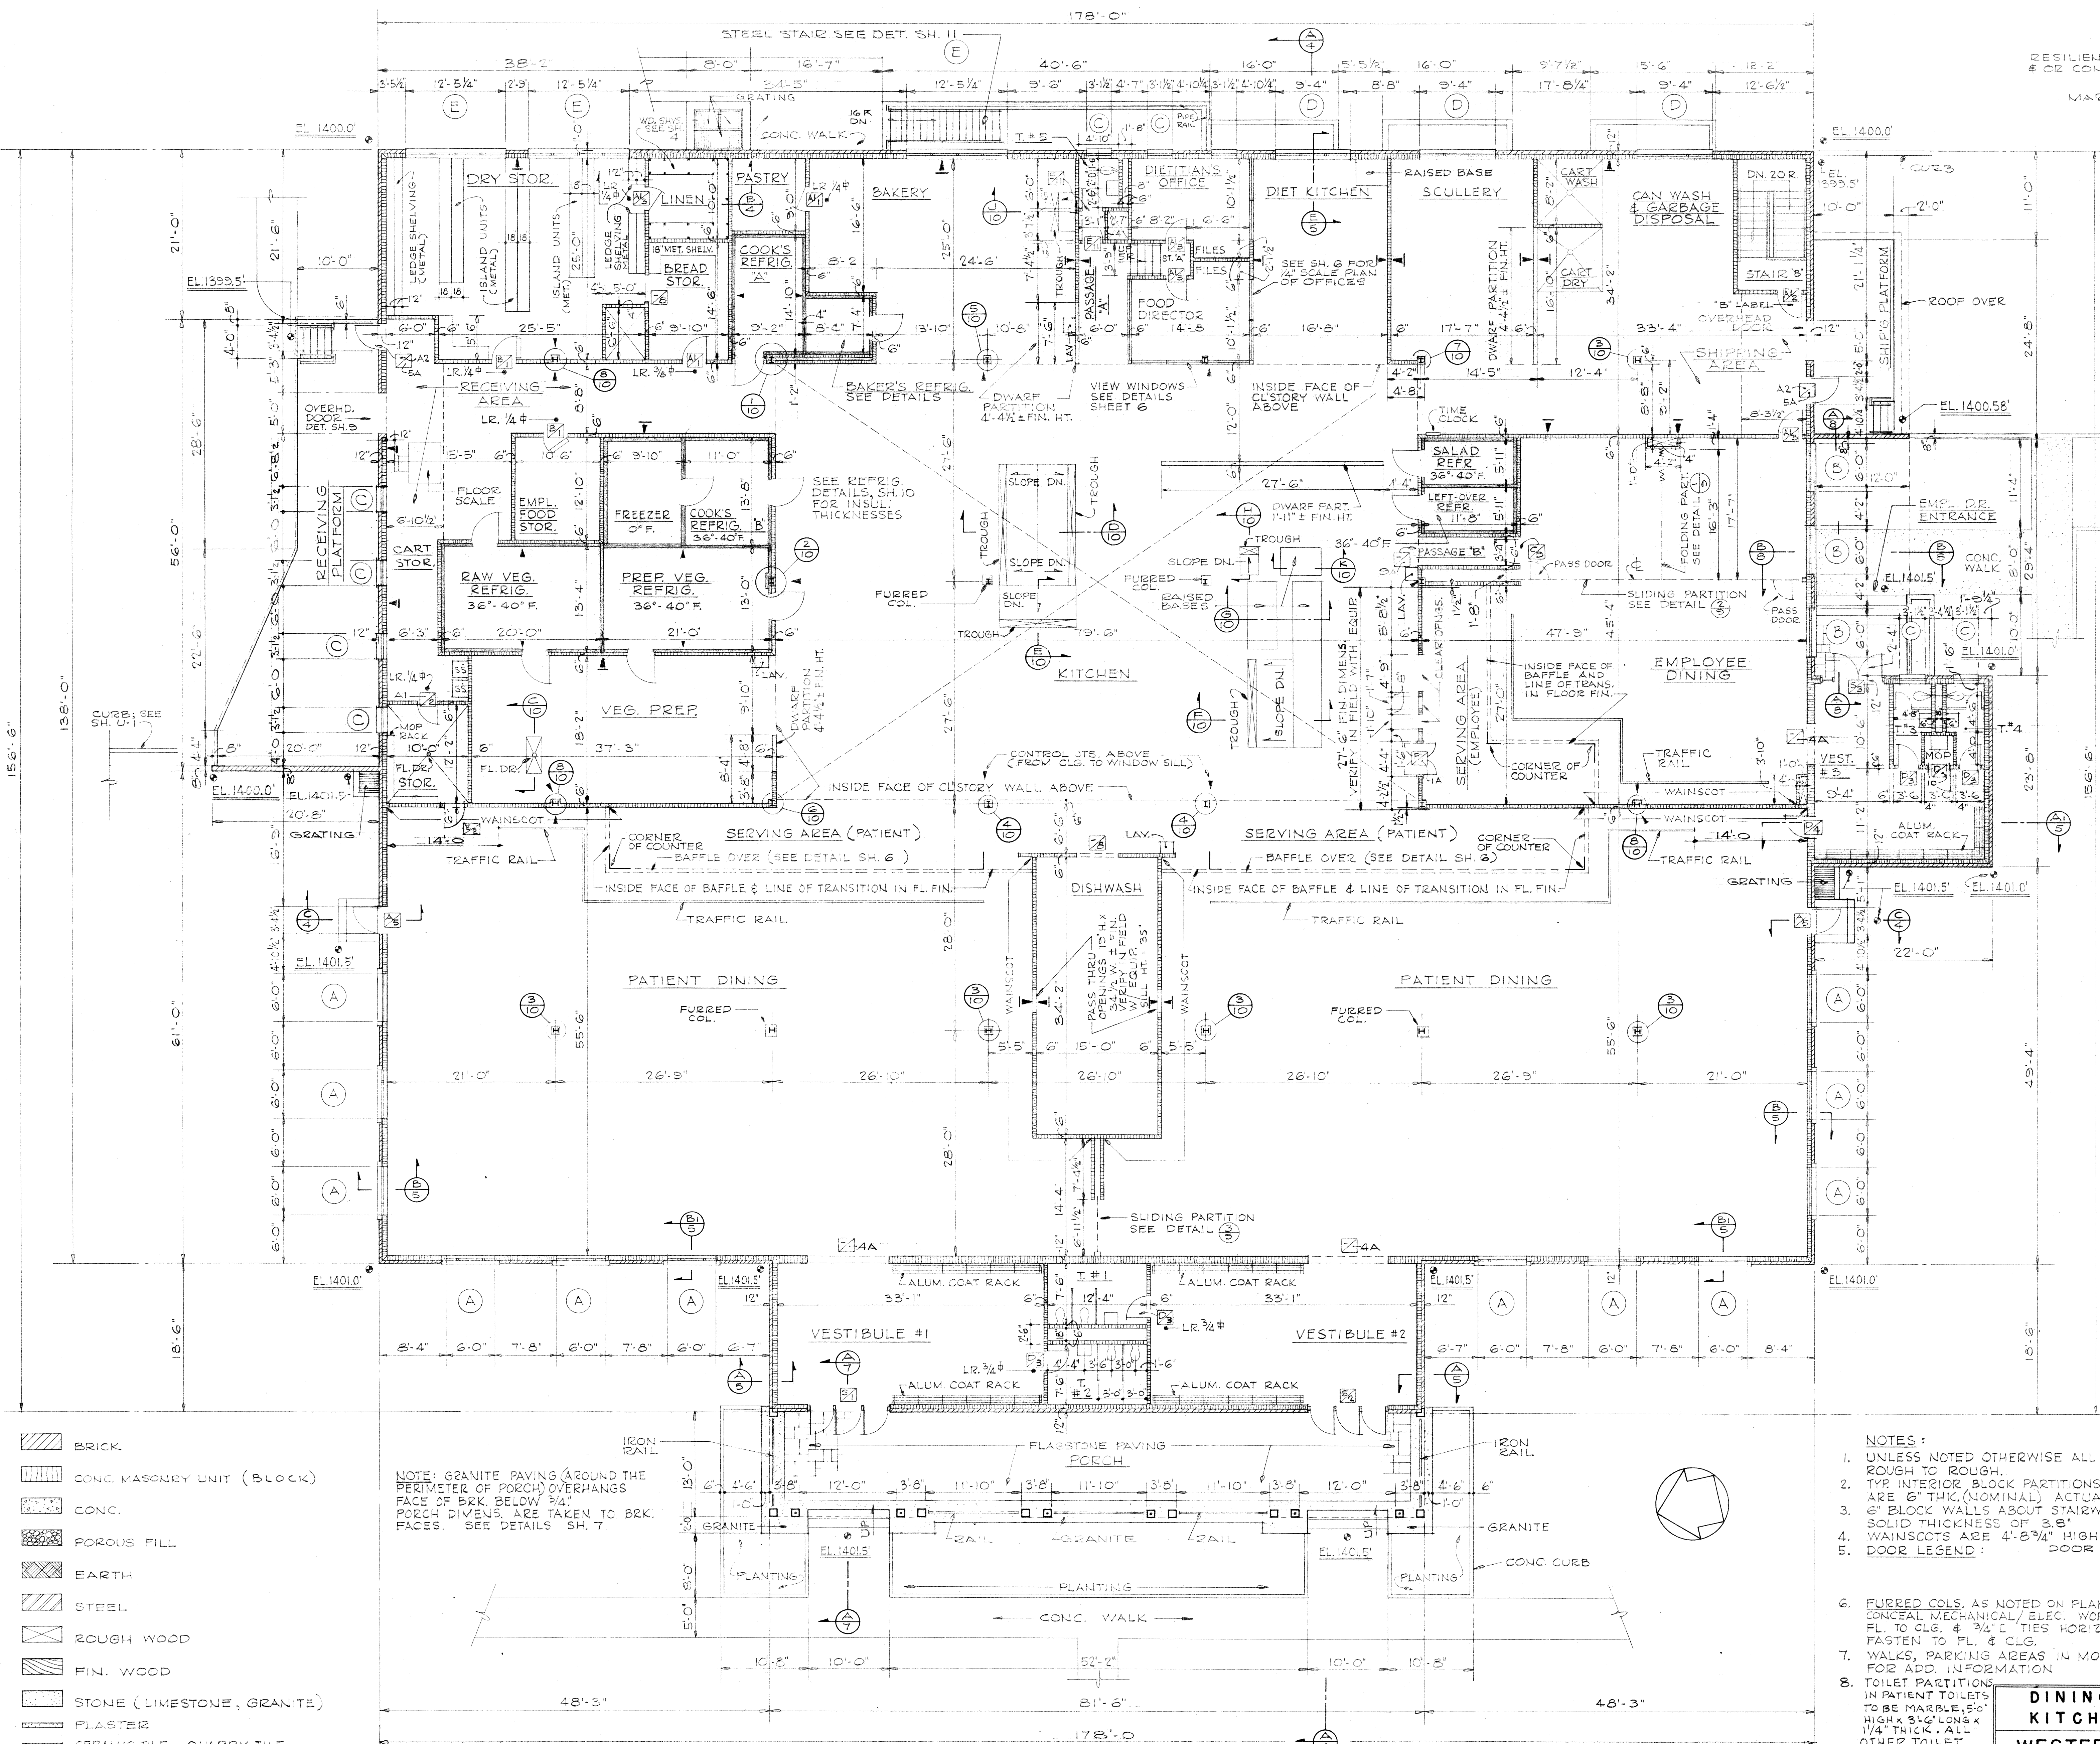

- MATERIAL INDICATIONS**
- BRICK
 - CONC. MASONRY UNIT (BLOCK)
 - CONC.
 - POROUS FILL
 - EARTH
 - STEEL
 - ROUGH WOOD
 - FIN. WOOD
 - STONE (LIMESTONE, GRANITE)
 - PLASTER
 - CERAMIC TILE, QUARRY TILE
 - ROOF & PERIMETER INSUL.
 - REFRIGERATOR INSUL.

NOTE: GRANITE PAVING (AROUND THE PERIMETER OF PORCH) OVERHANGS FACE OF BRK. BELOW 2". PORCH DIVIS. ARE TAKEN TO BRK. FACES. SEE DETAILS SH. 7

NOTE: CRACK CONTROL JOINTS INDICATED THIS PLAN IS TO BE CONSIDERED AS A GUIDE ONLY. THE ACTUAL CONSTRUCTION SHALL BE AS SHOWN IN THE DETAILS AND SPECIFICATIONS. THE CONTRACTOR SHALL BE RESPONSIBLE FOR THE PROTECTION OF EXISTING UTILITIES AND STRUCTURES. THE CONTRACTOR SHALL BE RESPONSIBLE FOR THE PROTECTION OF EXISTING UTILITIES AND STRUCTURES. THE CONTRACTOR SHALL BE RESPONSIBLE FOR THE PROTECTION OF EXISTING UTILITIES AND STRUCTURES.

FIRST FLOOR PLAN
 SCALE 1/8" = 1'-0"

NOTE: USE @ TRANSITION OF FLOOR FINISH @ SERVING COUNTERS, OVERHEAD DOORS @ DOOR C/O BETWEEN EMPLOYEE DINING & PASSAGE "B".




DETAIL of MARBLE DIVIDED STRIP
 SCALE 3/4" = 1'-0"

SEE SH. 6 FOR EMP. DR. ENTR. DETAILS

1/2" S.S. POST & RAIL, POST SPACING 5'-0" O.C. MAX.
 S.S. FLANGE
 2" PIPE SLEEVE
 HYDRAULIC TYPE PAST SETTING CEMENT
 WELD 1/4" THICK 6"x6" PLATE TO BOTTOM OF PIPE SLEEVE.
TRAFFIC RAIL DET.
 SCALE 3/4" = 1'-0"

12"
 3/4" x 2 1/2"
 1/2" SPACE SET
 BRACE 4" O.C.
 3/4" x 2 1/2"
 MOP CLAMPS 12" O.C.
 3/4" x 3 1/2"
 X.C.P.F.
 Q.T. BASE
 1ST FLOOR EL. 1403.0
MOP RACK DETAIL
 (IN STORAGE RM.)
 SCALE 1/2" = 1'-0"

- NOTES:**
- UNLESS NOTED OTHERWISE ALL DIMENSIONS ARE GIVEN ROUGH TO ROUGH.
 - TYP. INTERIOR BLOCK PARTITIONS, UNLESS NOTED OTHERWISE, ARE 6" THICK (NOMINAL) ACTUAL: 5 5/8".
 - 6" BLOCK WALLS ABOUT STAIRWAY TO HAVE A MIN. EQUIVALENT SOLID THICKNESS OF 3.8".
 - WAINSCOTS ARE 4'-6 3/4" HIGH (EXCEPT PASSAGE "B", 4'-4 1/2" HIGH).
 - DOOR LEGEND: DOOR TYPE - FRAME TYPE - LOUVER - FREE AREA
 - FURRED COLS. AS NOTED ON PLAN: FURRED AS REQ'D TO CONCEAL MECHANICAL/ELEC. WORK. USE 1 1/2" I'S VERTICALLY, FL TO CLG. & 3/4" I'S HORIZONTALLY. RIGIDLY ANCHOR & FASTEN TO FL & CLG.
 - WALKS, PARKING AREAS IN MODIFIED BASE BIDS. SEE SH. 10 FOR ADD. INFORMATION.
 - TOILET PARTITIONS IN PATIENT TOILETS TO BE MARBLE, 5'-0" HIGH, 3'-0" LONG x 1/4" THICK. ALL OTHER TOILET PARTITIONS TO BE METAL.

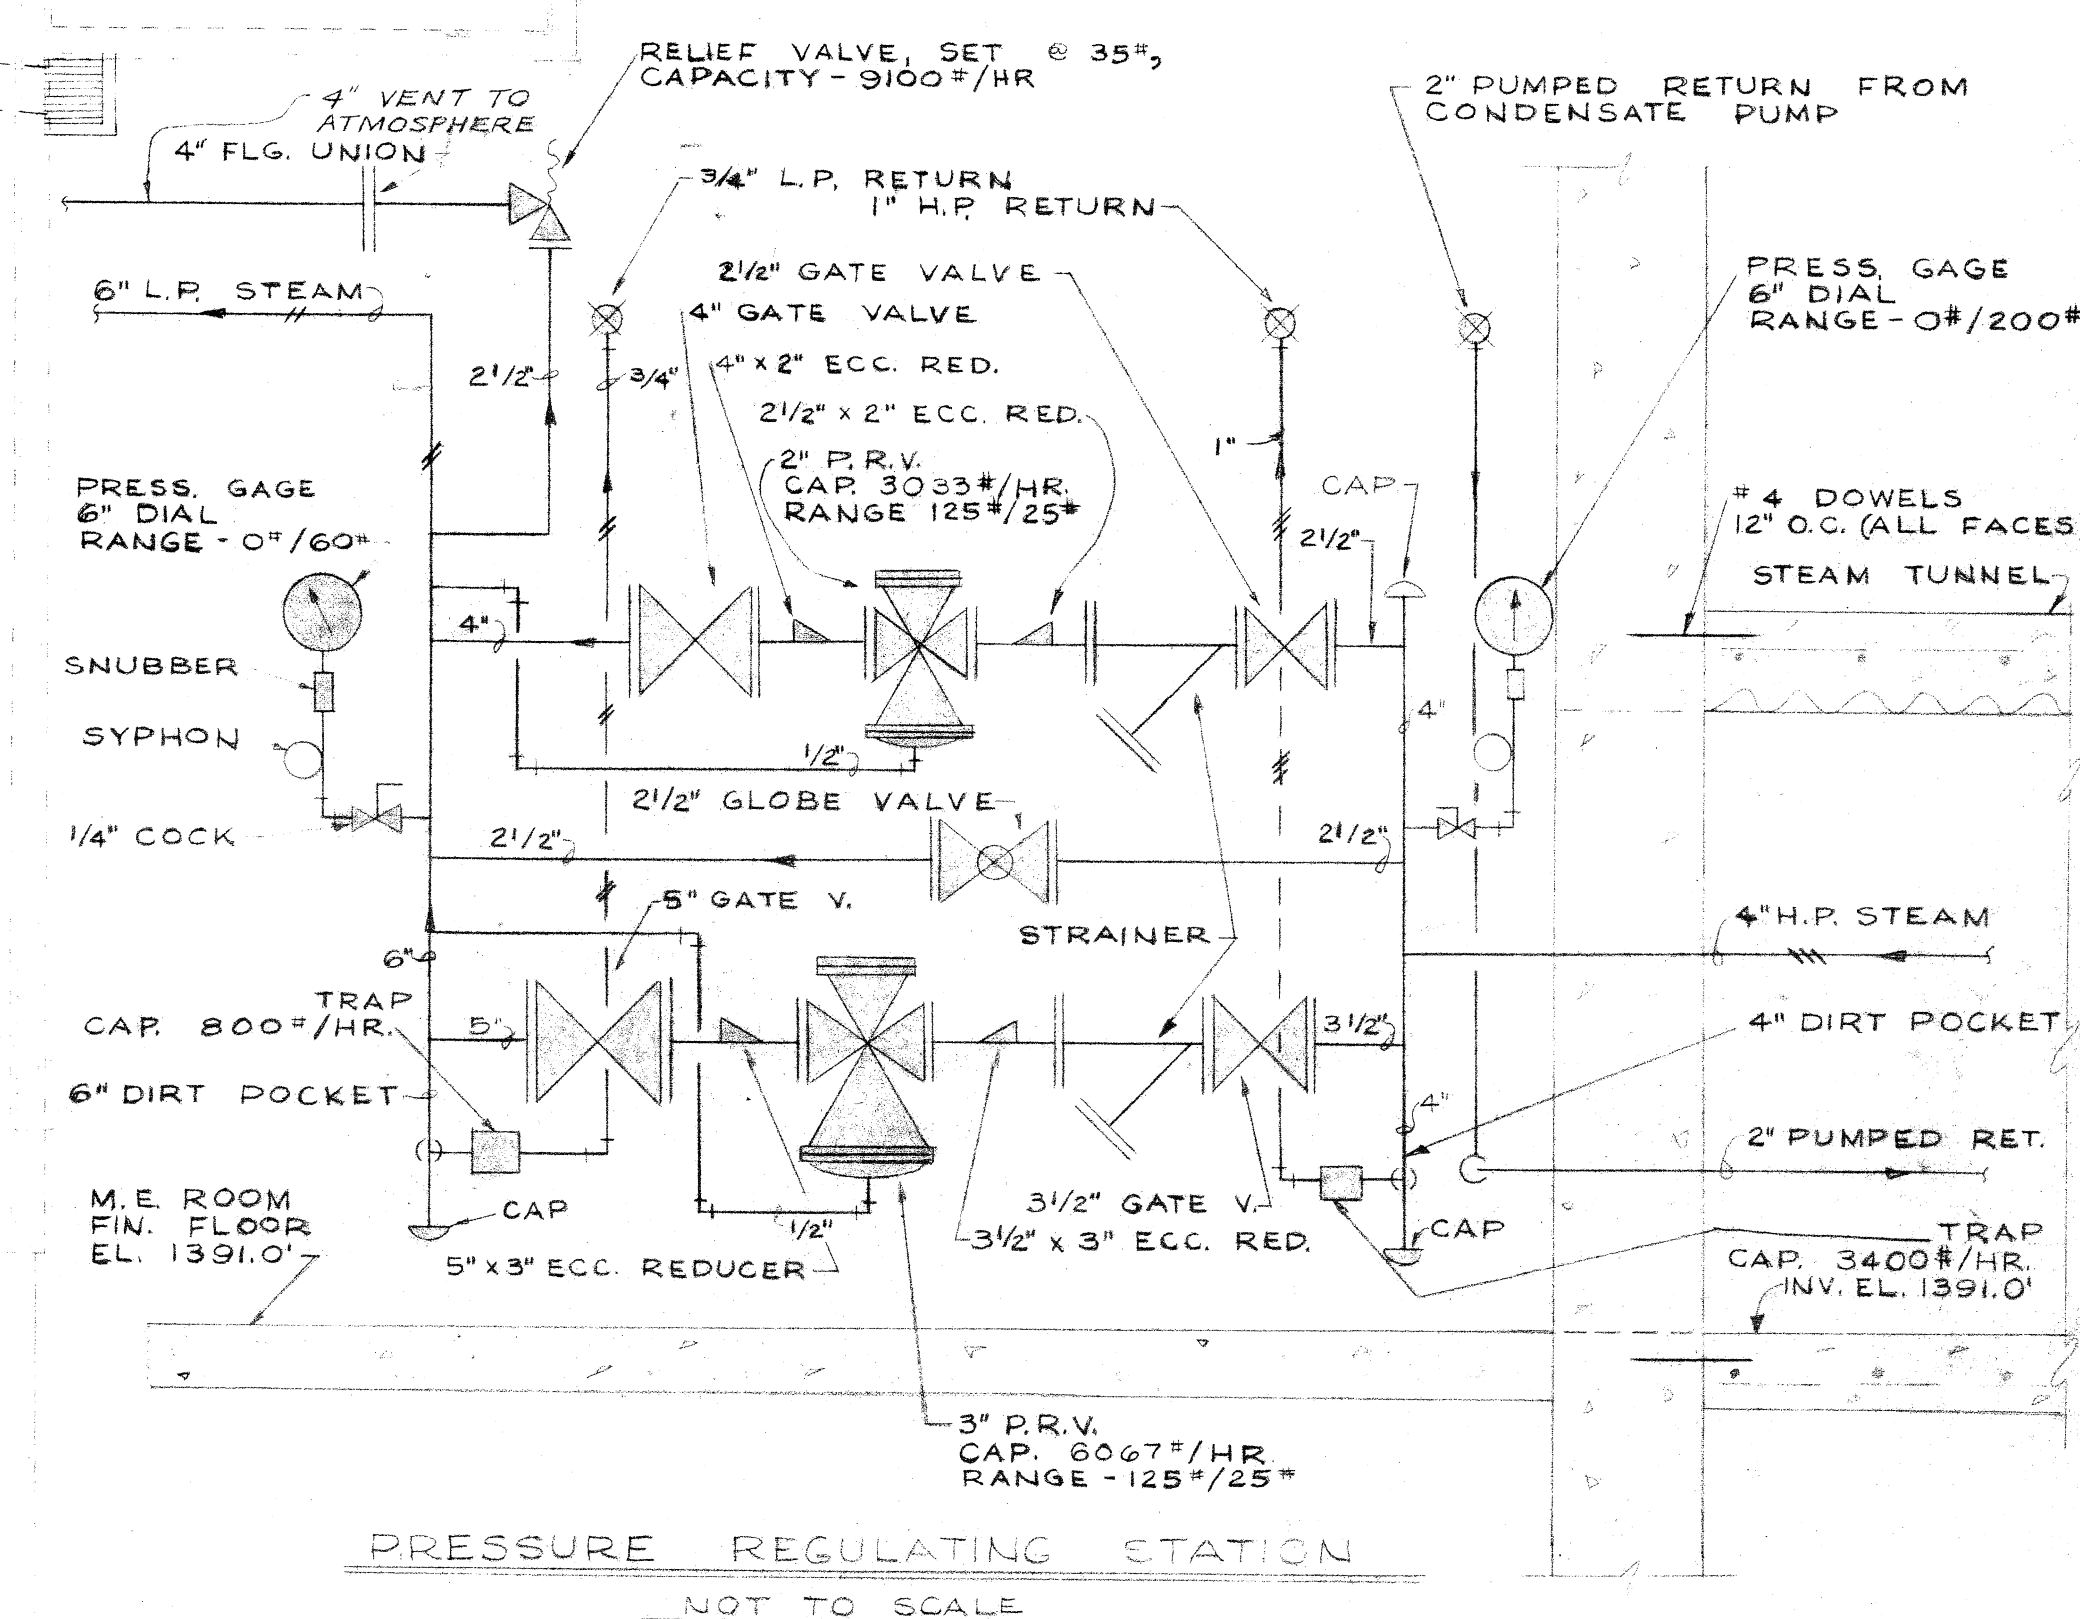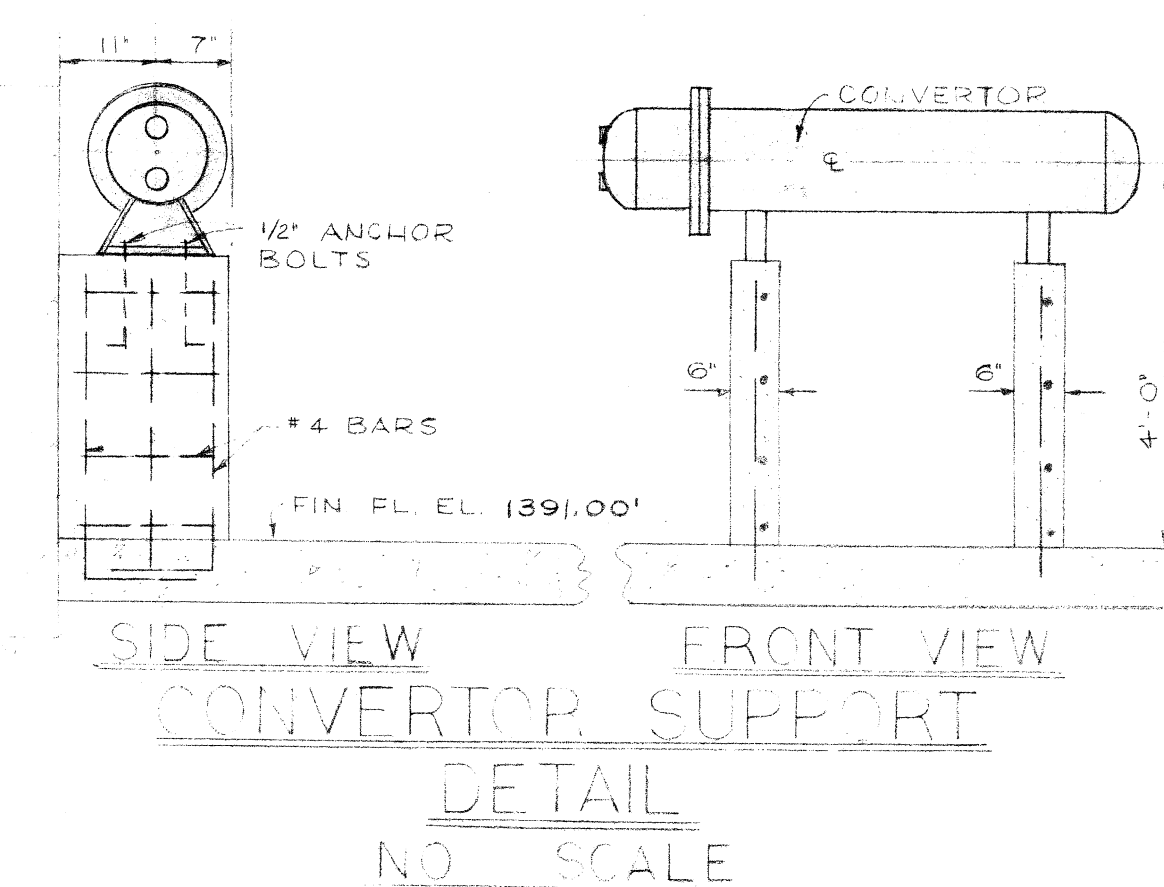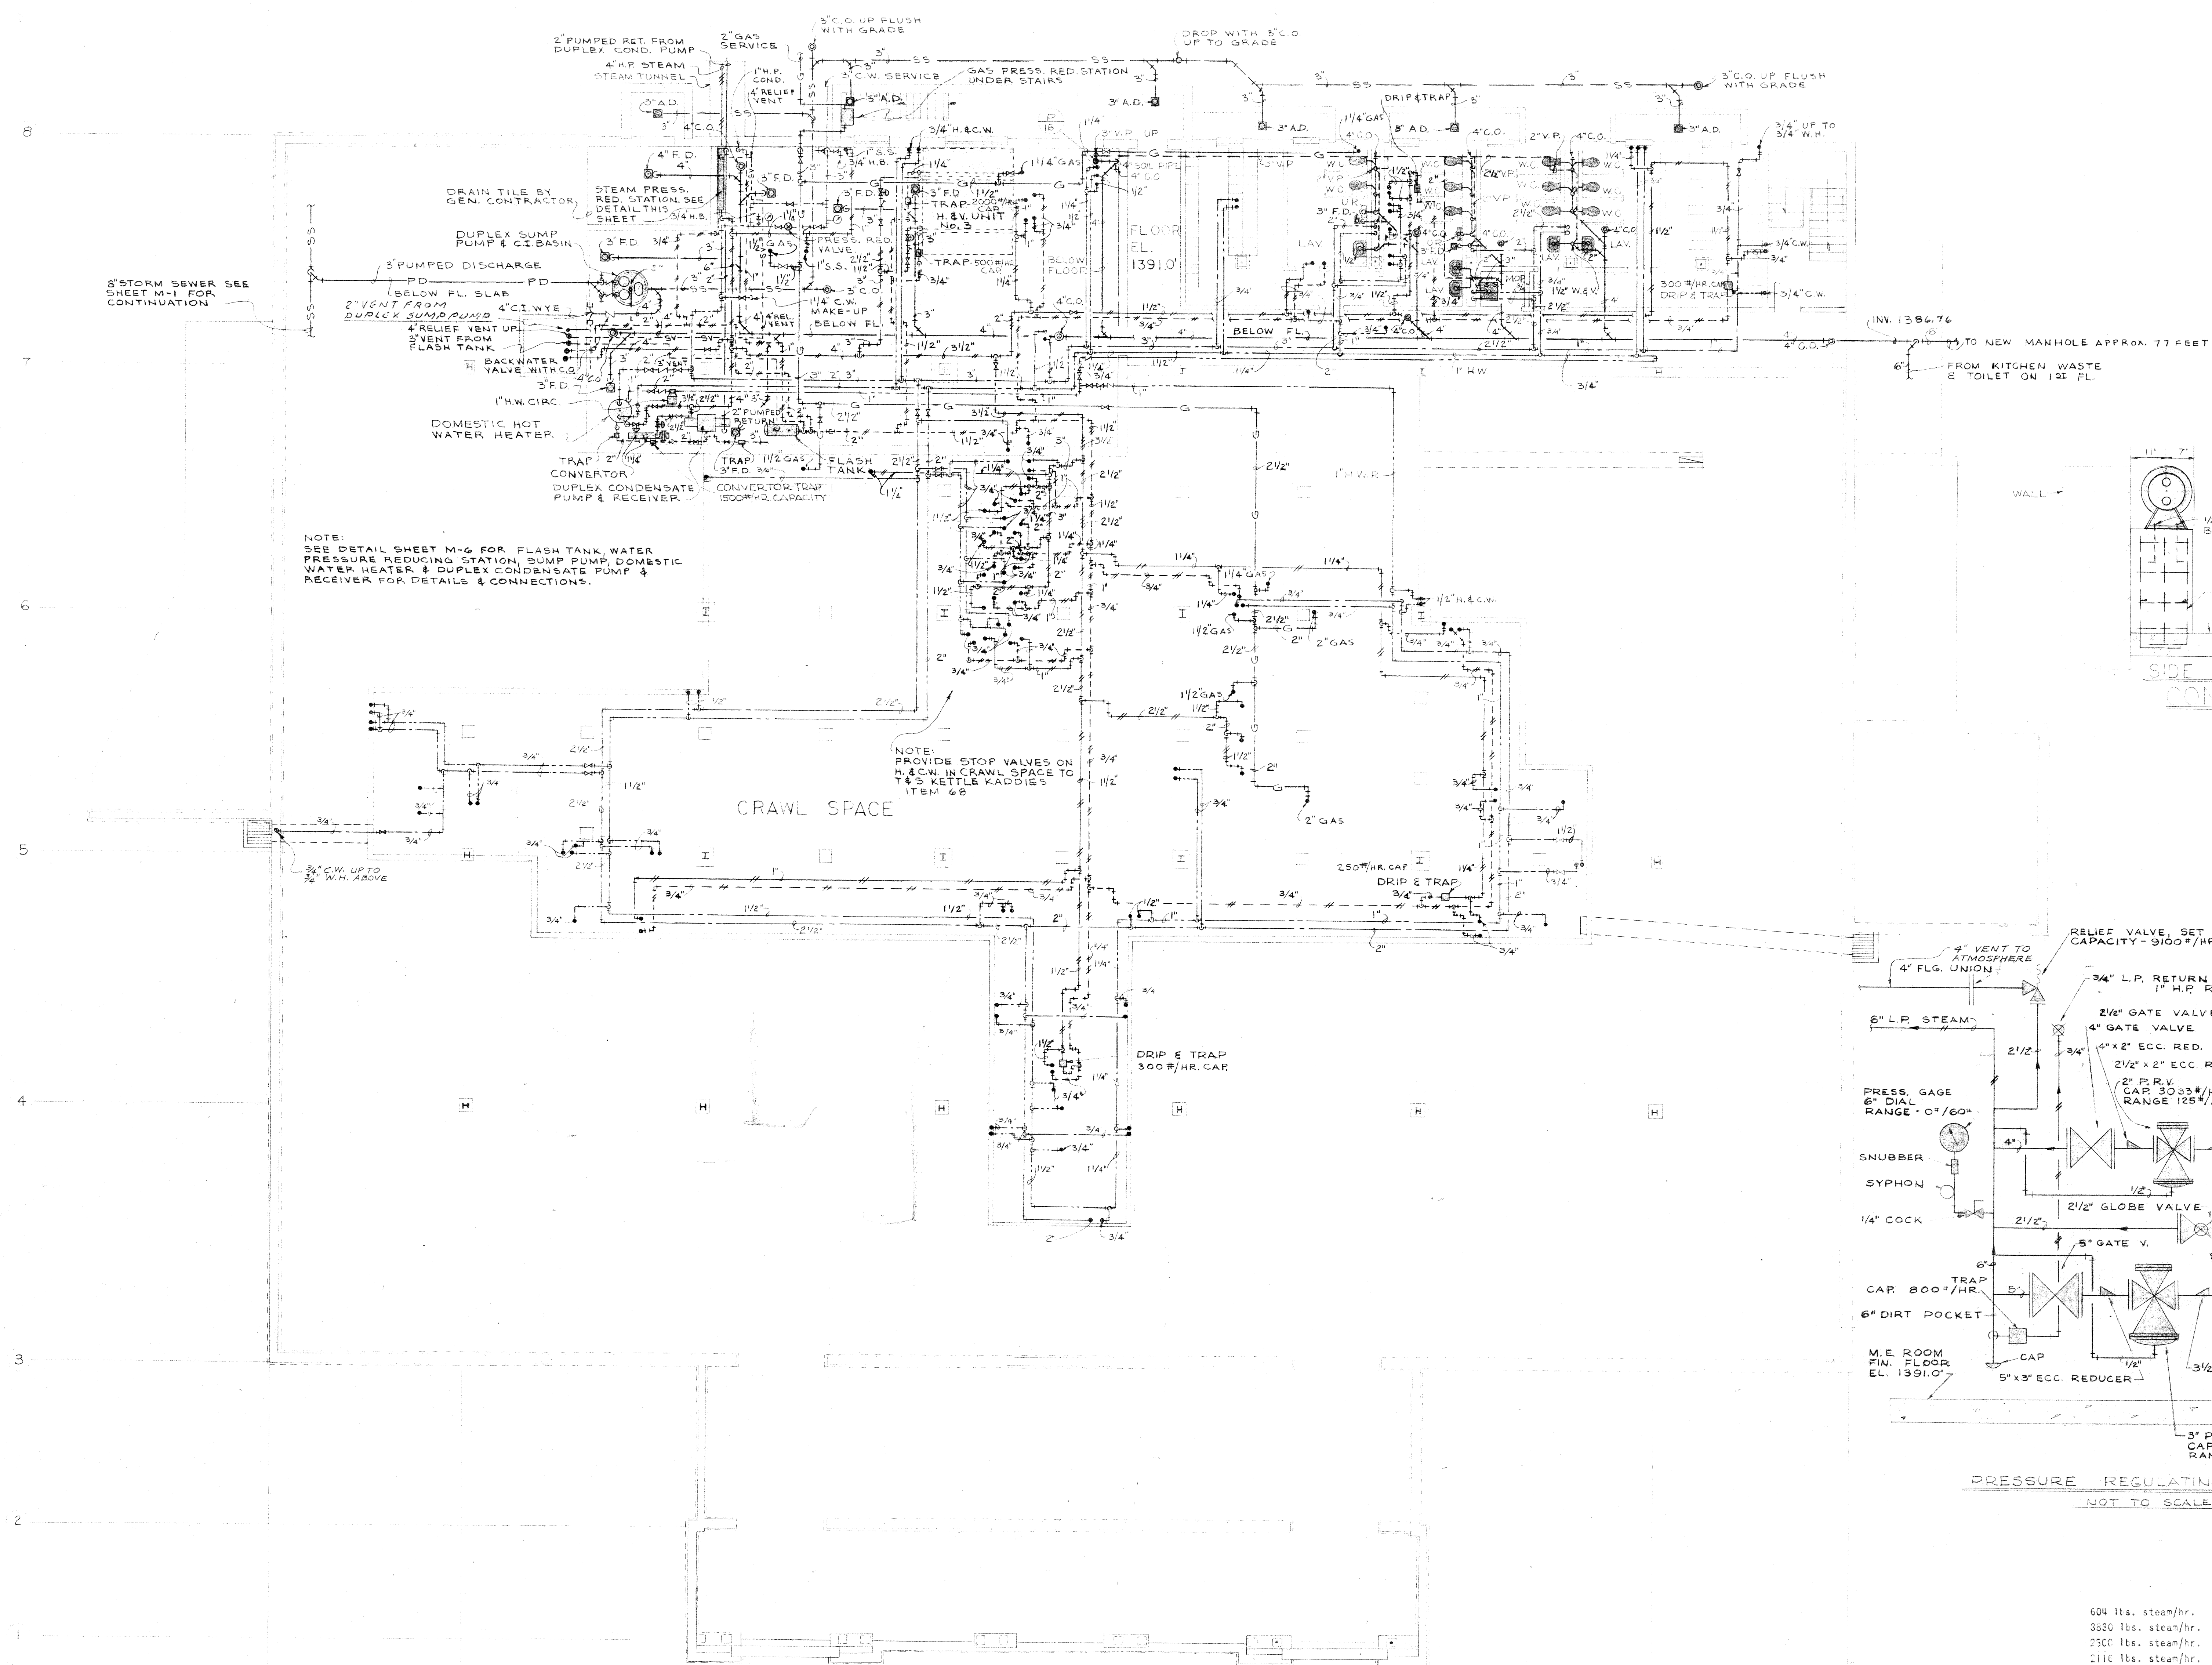

604 lbs. steam/hr. - Heating Load
3830 lbs. steam/hr. - Ventilating Load
2560 lbs. steam/hr. - Domestic Hot Water Heating Load
2116 lbs. steam/hr. - Kitchen Equipment Load

MECHANICAL
BASEMENT FLOOR PLUMBING PLAN

DINING ROOM AND
KITCHEN BUILDING


WESTERN STATE HOSPITAL
WAYNESBORO ROAD
STAUNTON VIRGINIA

WILEY & WILSON
CONSULTING ENGINEERS
LYNCHBURG, VA. RICHMOND, VA.

DATE SEPT. 1961	MARCELLUS WRIGHT & SON ARCHITECTS 100EAST MAIN STREET RICHMOND, VIRGINIA
REVISED	

SHEET
M-1
OF 9

BASEMENT FLOOR PLAN
SCALE - 1/8" = 1'-0"

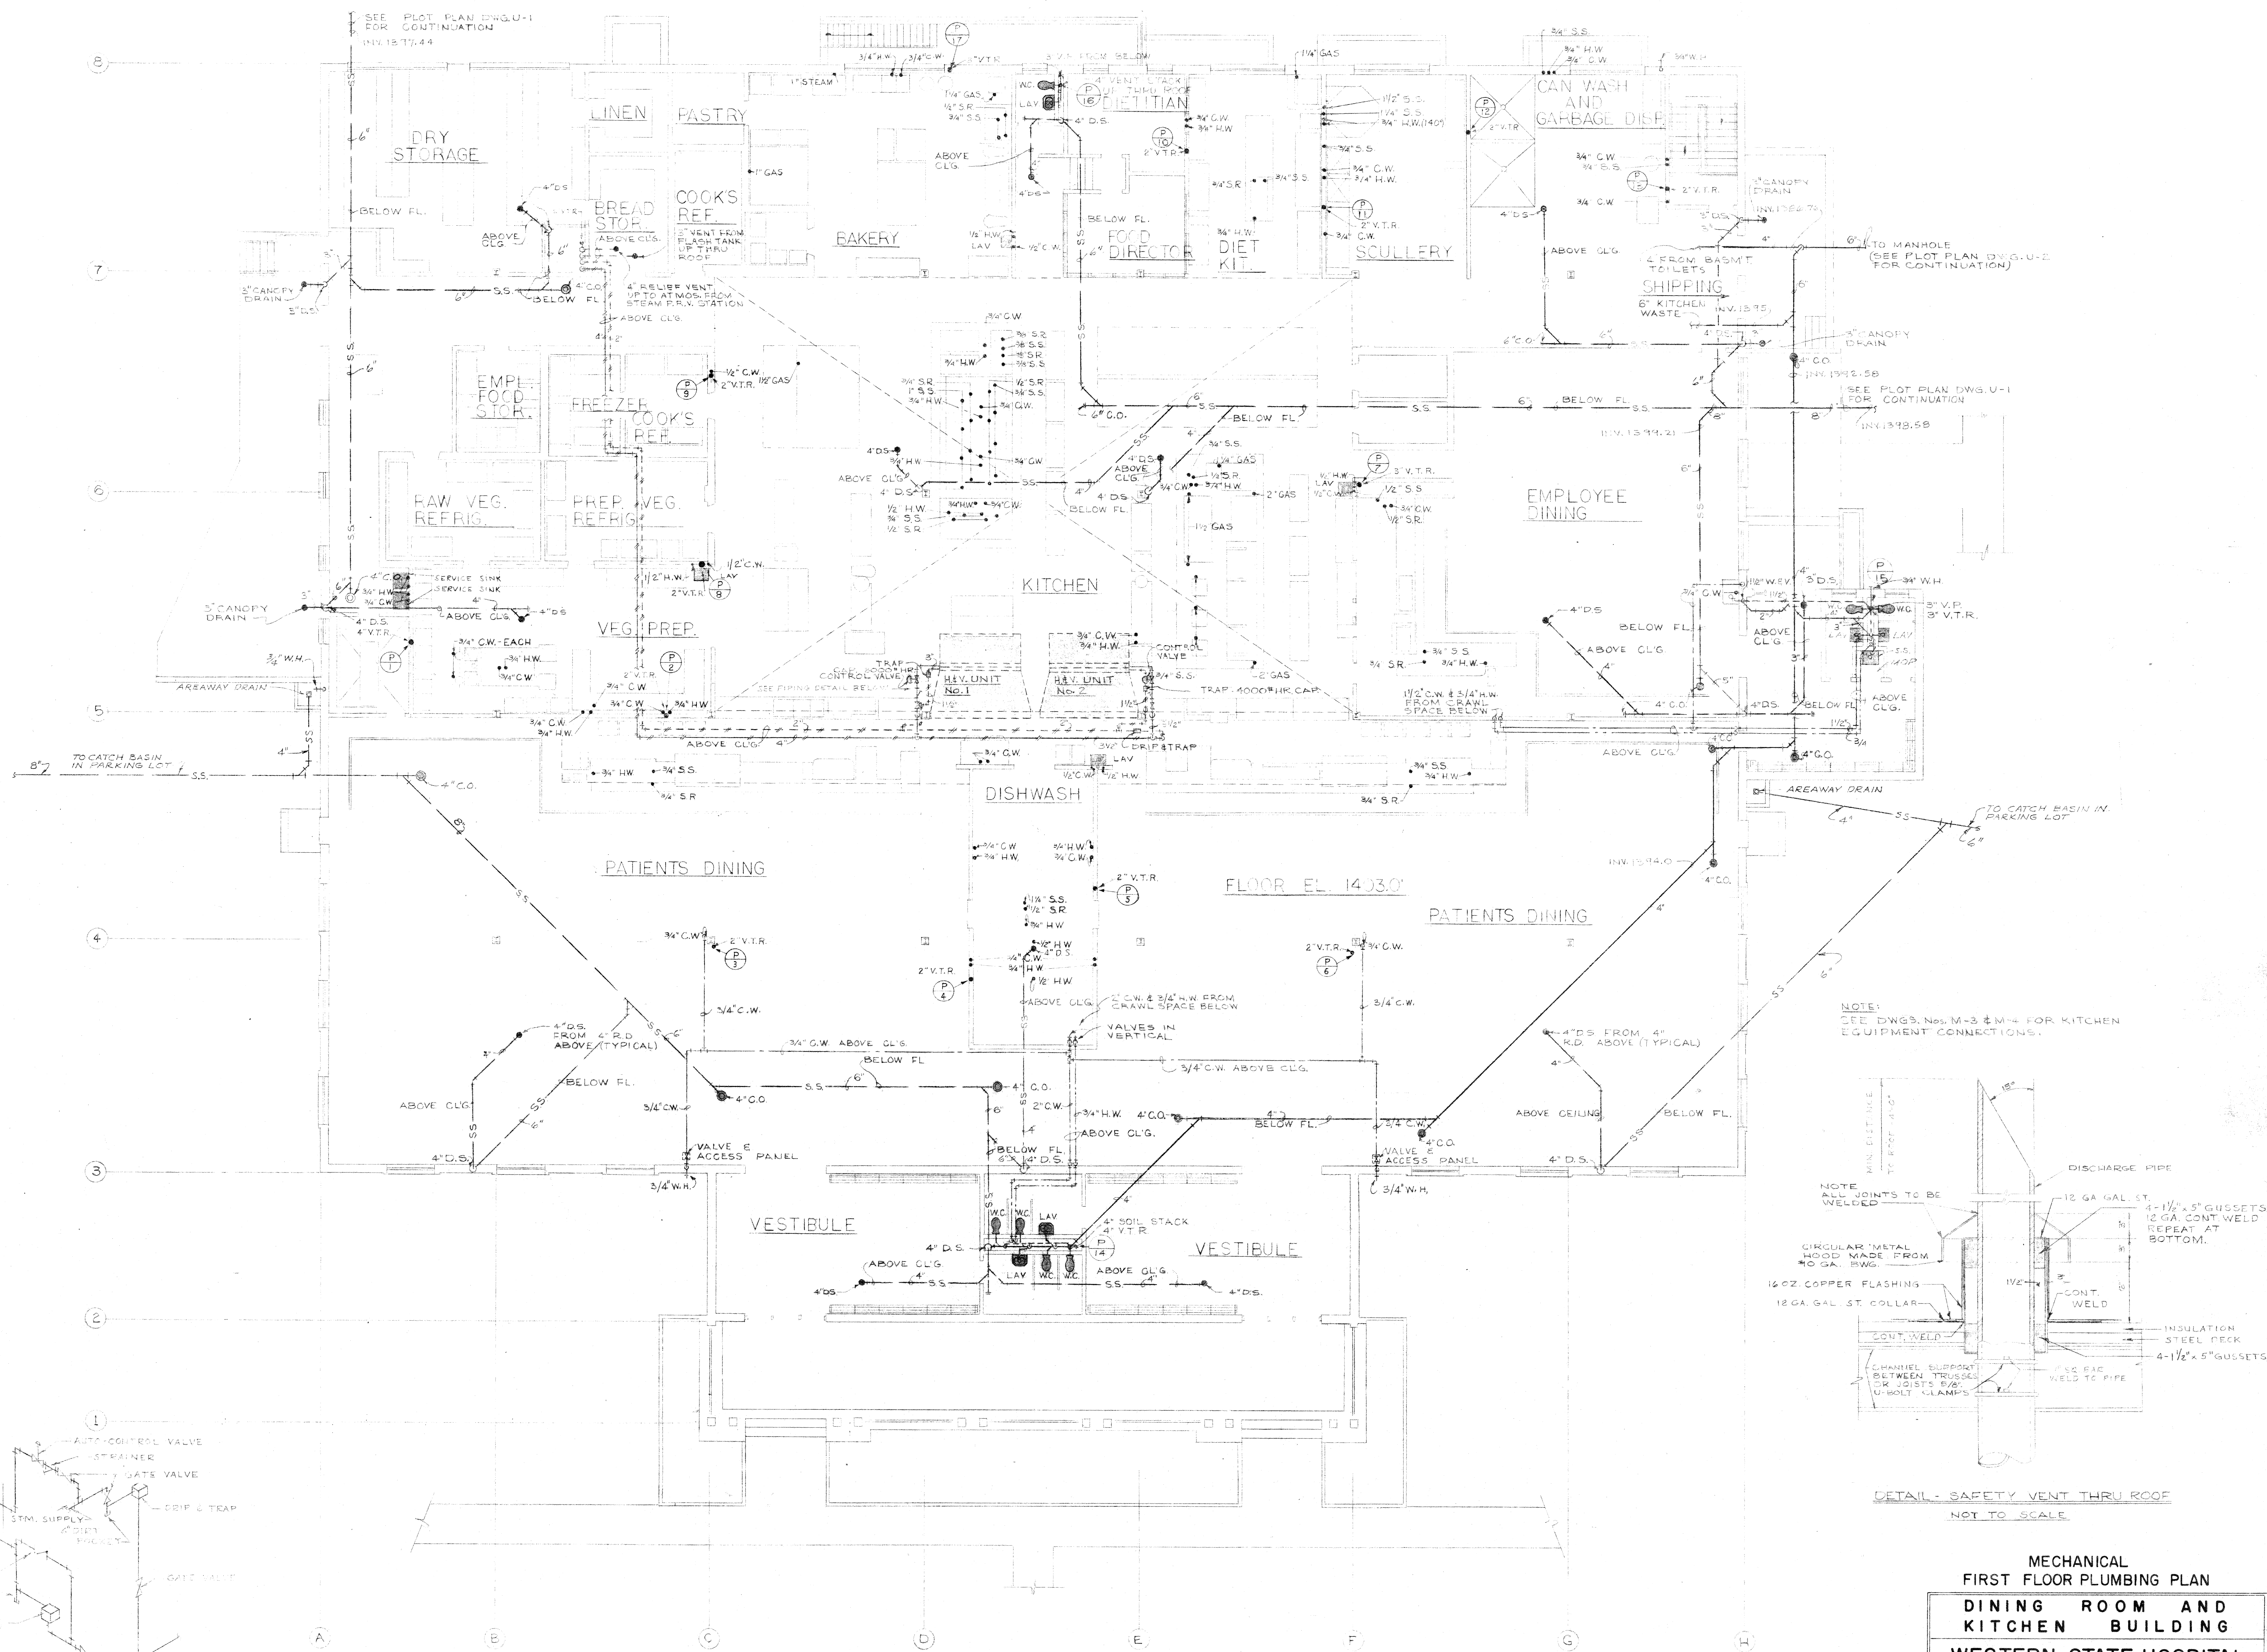

FIRST FLOOR PLAN
SCALE - 1/8" = 1'-0"

MECHANICAL
FIRST FLOOR PLUMBING PLAN

DINING ROOM AND
KITCHEN BUILDING

WESTERN STATE HOSPITAL
WAYNESBORO ROAD
STAUNTON VIRGINIA

WILEY & WILSON
CONSULTING ENGINEERS
LYNCHBURG, VA. RICHMOND, VA.

DATE
SEPT. 1961
REVISED

MARCELLUS WRIGHT & SON
ARCHITECTS
100 EAST MAIN STREET
RICHMOND, VIRGINIA

SHEET
M-2
9
OF 2