



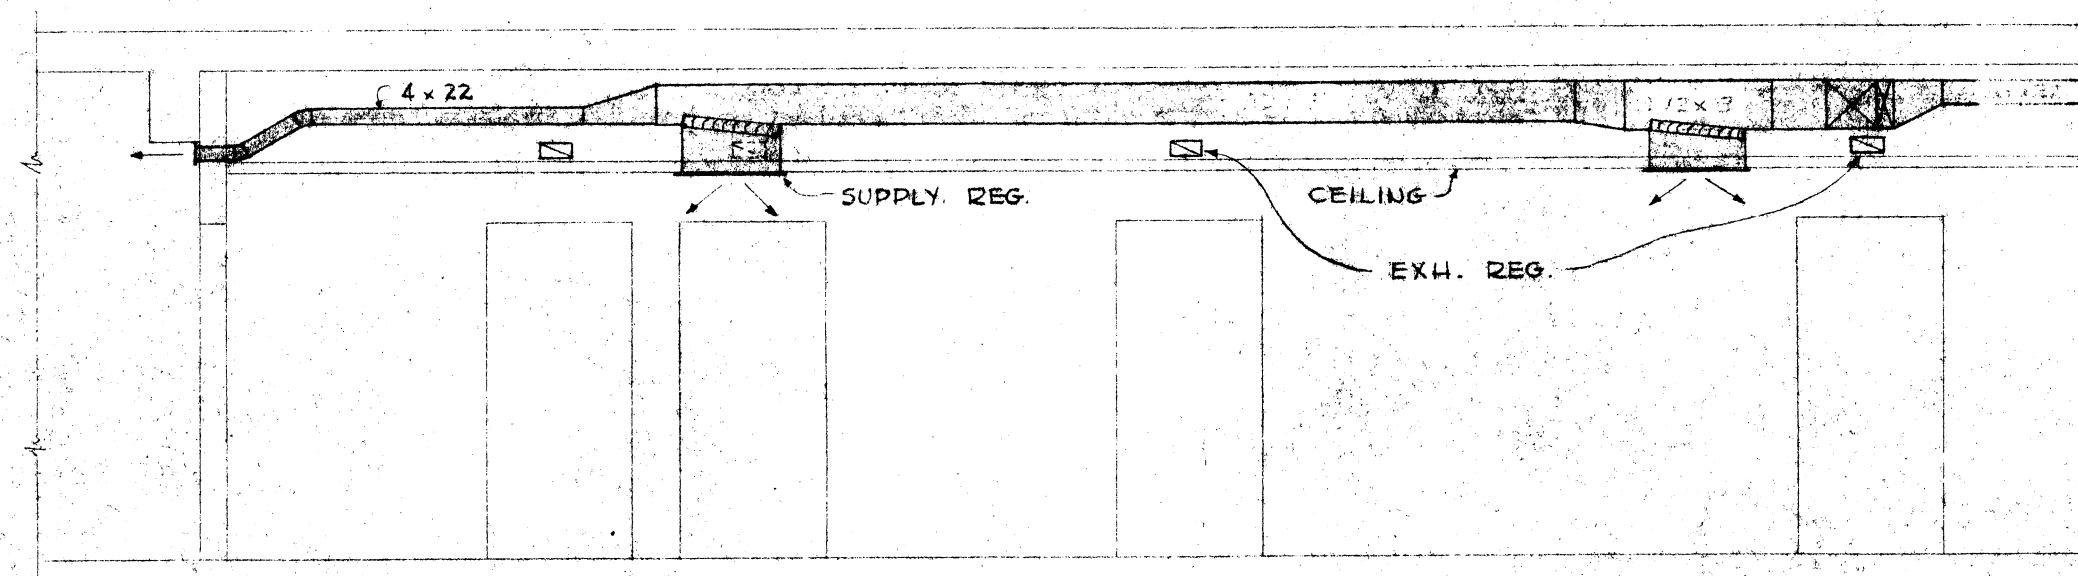


SECTION 'A-A'
SCALE: 1/4" = 1'-0"

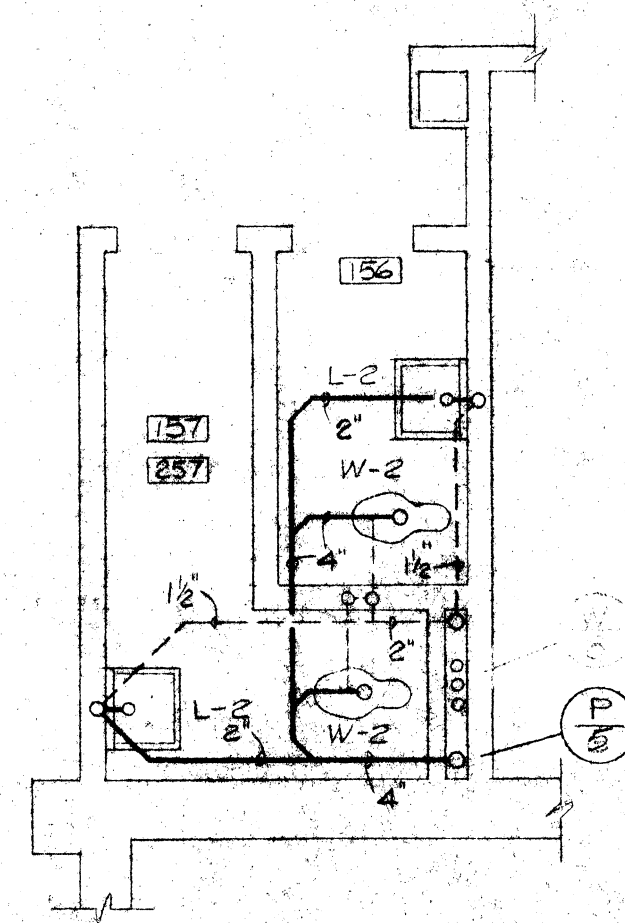

TOILET ROOM DETAIL
SCALE: 1/4" = 1'-0"


REGISTER SCHEDULE				
EXHAUST				
SYMBOL	SIZE	QFM	LOCATION	# TYPE
E1	8x6	40	CLG.	C
E2	8x4	65	WALL	C
E3	10x4	85	WALL	C
E4	14x4	110	WALL	C
E5	8x6	110	CLG.	C
E6	22x4	165	WALL	B
E7	8x6	110	CLG.	C
E8	8x6	110	CLG.	C
E9	8x6	110	CLG.	C
SUPPLY				
S1	8x6	40	CLG.	D
S2	12x12	35	CLG.	A
S3	24x12	275	CLG.	D
S4	22x4	225	WALL	A
S5	48x24	2500	CLG.	A

* SEE SPECIFICATIONS FOR TYPE DESCRIPTION.

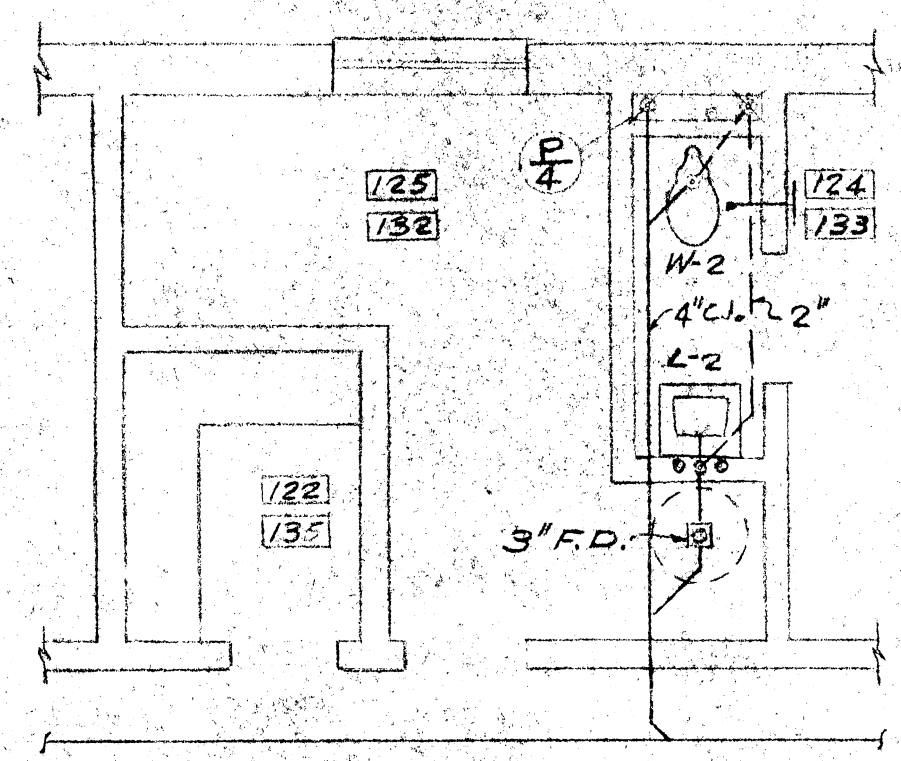


TOILET ROOM DETAIL
SCALE: 1/4" = 1'-0"

NOTES:
1. SEE SITE PLAN FOR PLUMBING SYMBOLS

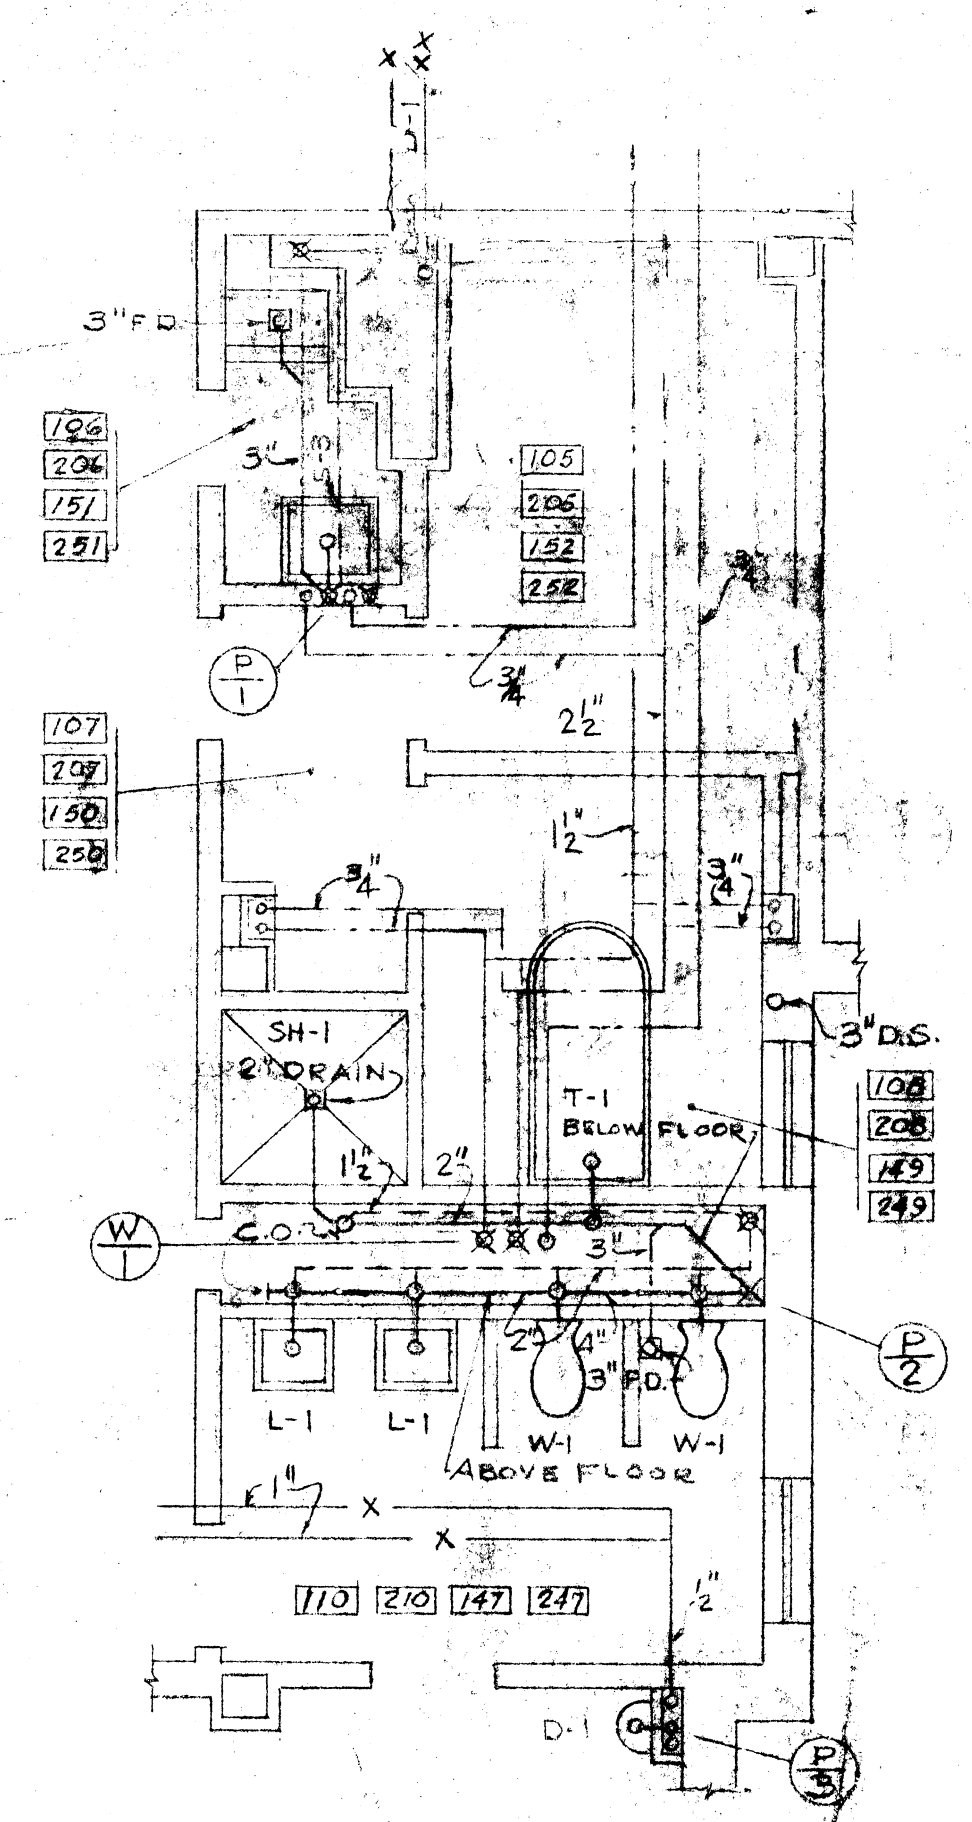

TOILET ROOM DETAIL
SCALE: 1/4" = 1'-0"
SAN. SEWER TYPICAL NORTH & SOUTH WING-SEE WATER PIPING RISER DIAGRAM FOR WATER DISTRIBUTION NORTH WING

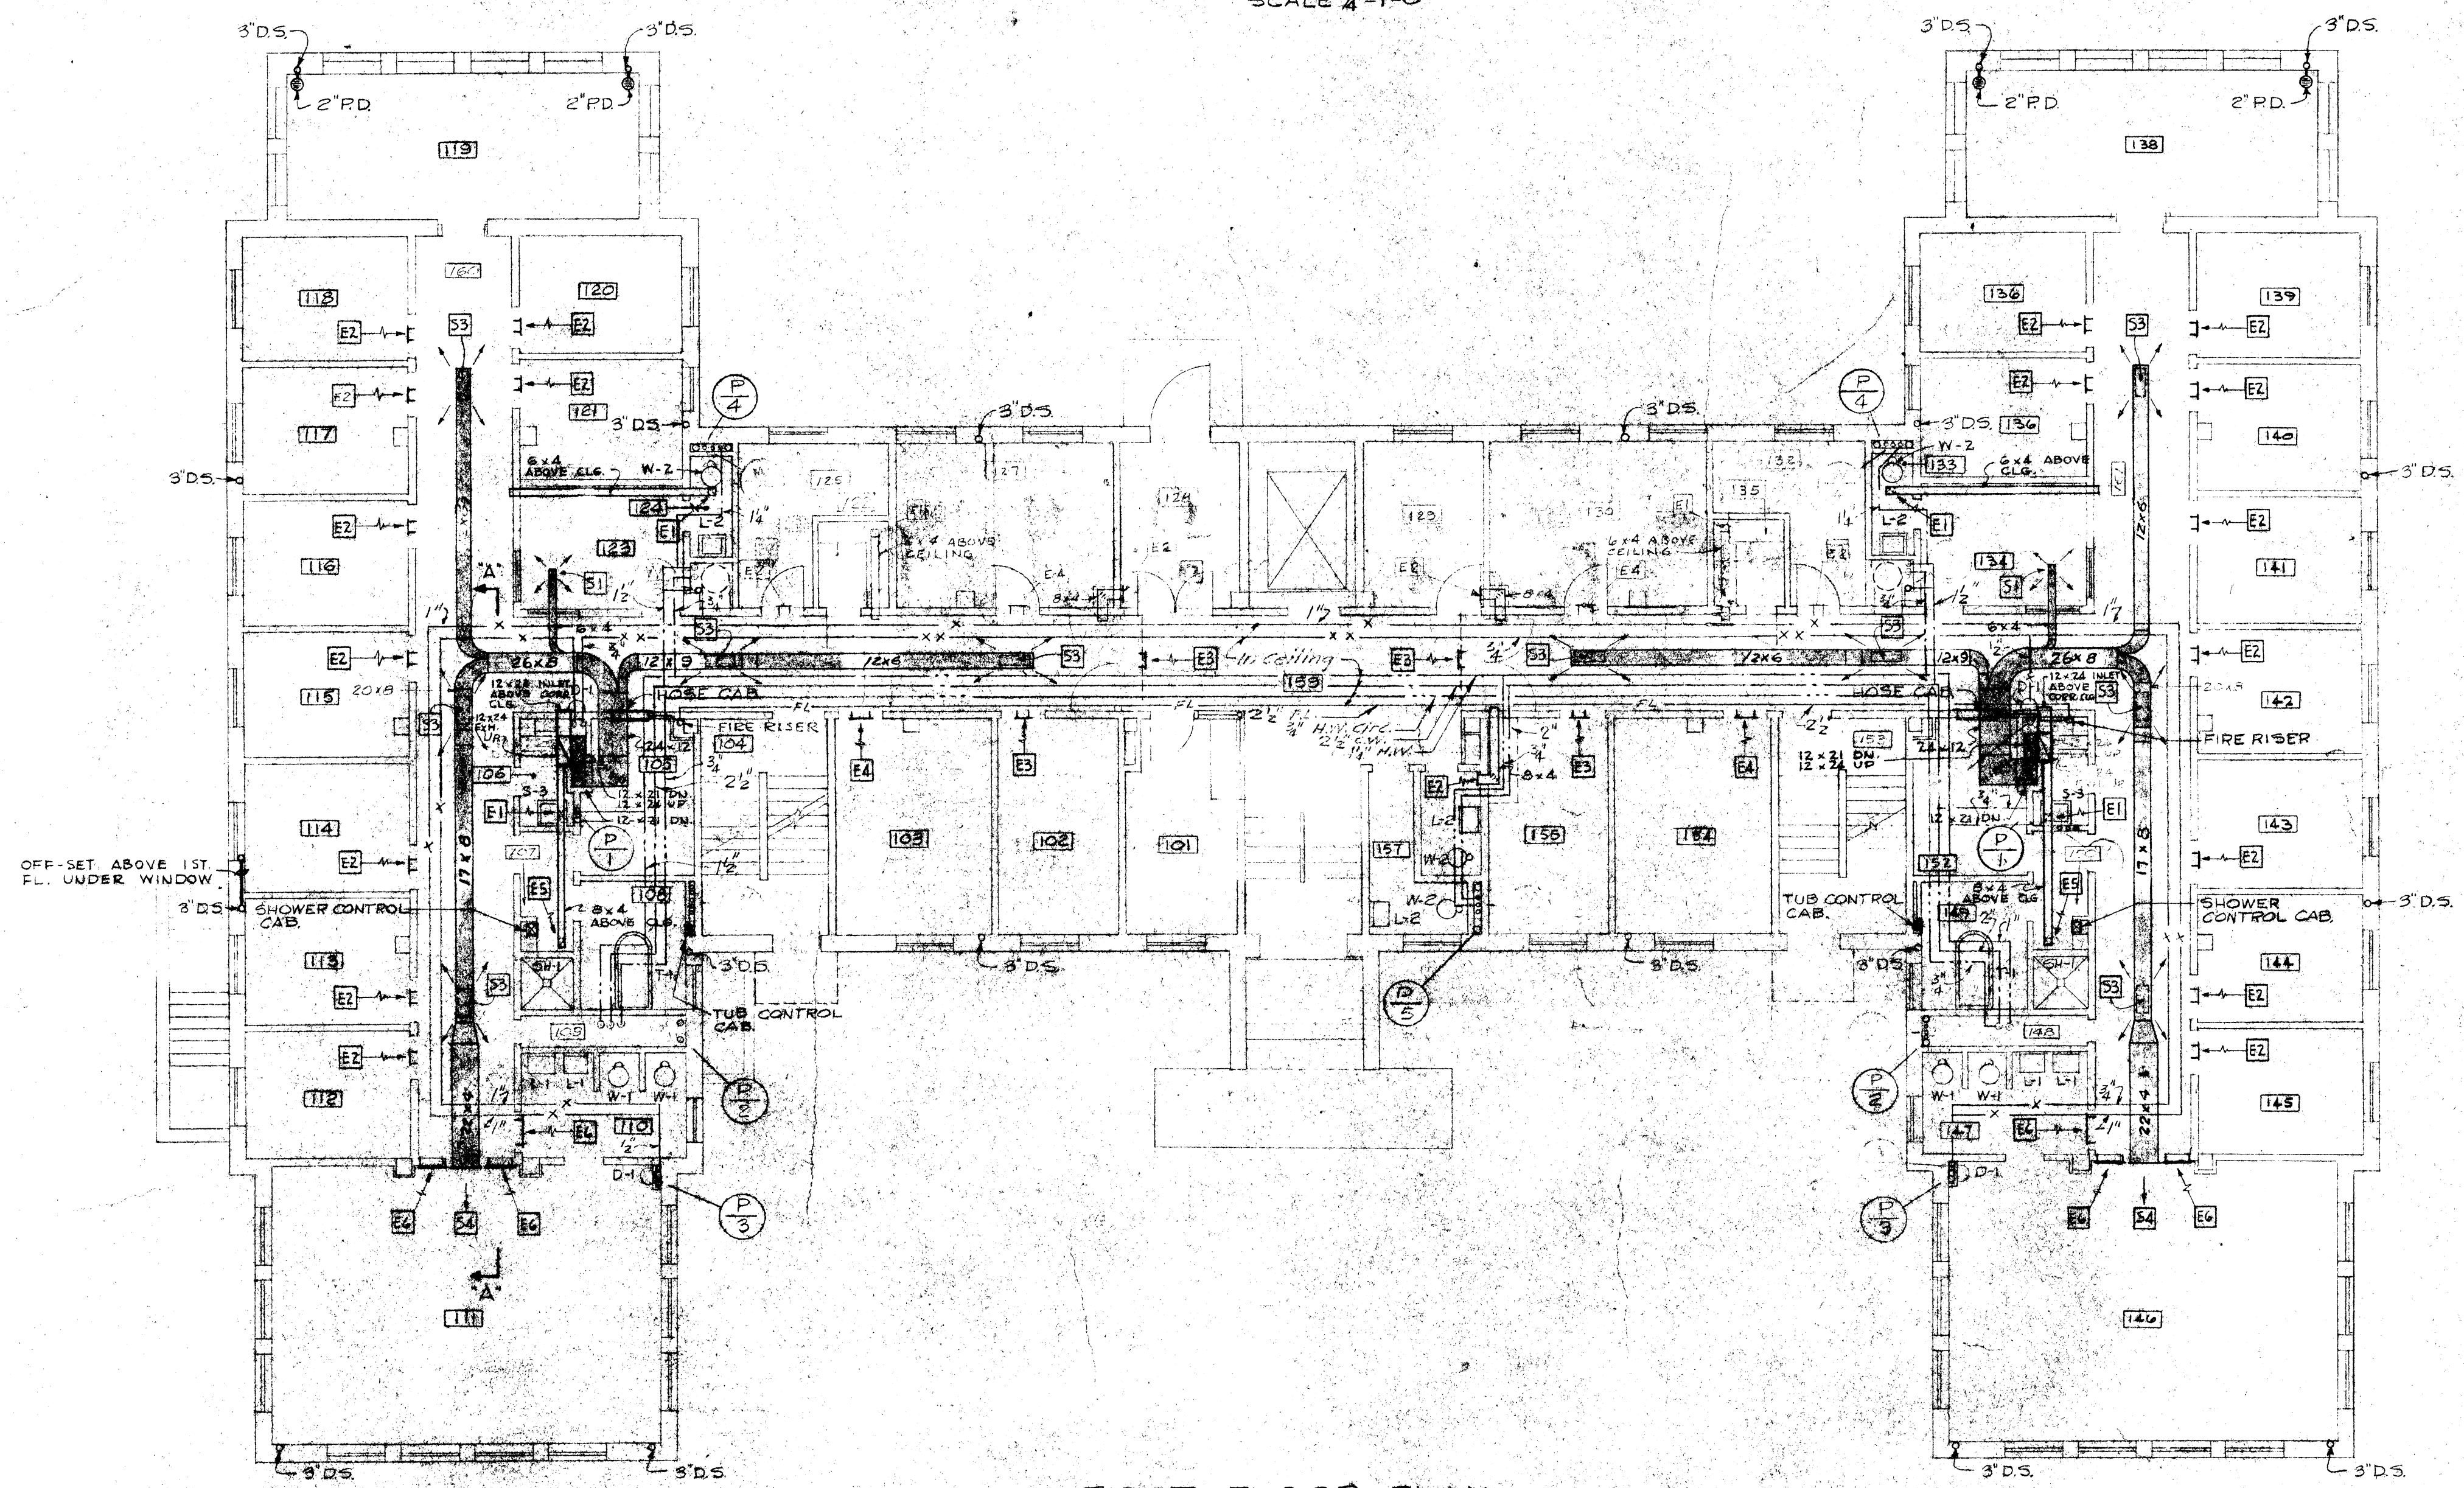

FIRST FLOOR PLAN
SCALE: 1/8" = 1'-0"


PLUMBING & VENTILATION
FIRST FLOOR PLAN

SITE ADAPTED BY
WILEY & WILSON
CONSULTING ENGINEERS
LYNCHBURG, VA. - RICHMOND, VA.



RECOVERY BUILDING C-2F
WESTERN STATE HOSPITAL
WAYNESBORO ROAD
STAUNTON VIRGINIA

DATE: SEPT. 1958
REVISION: AS BUILT NOV. 1960
MARGELLUS WRIGHT & SON
ARCHITECTS
100 EAST MAIN STREET
RICHMOND, VIRGINIA


SHEET
M-6
OF 11

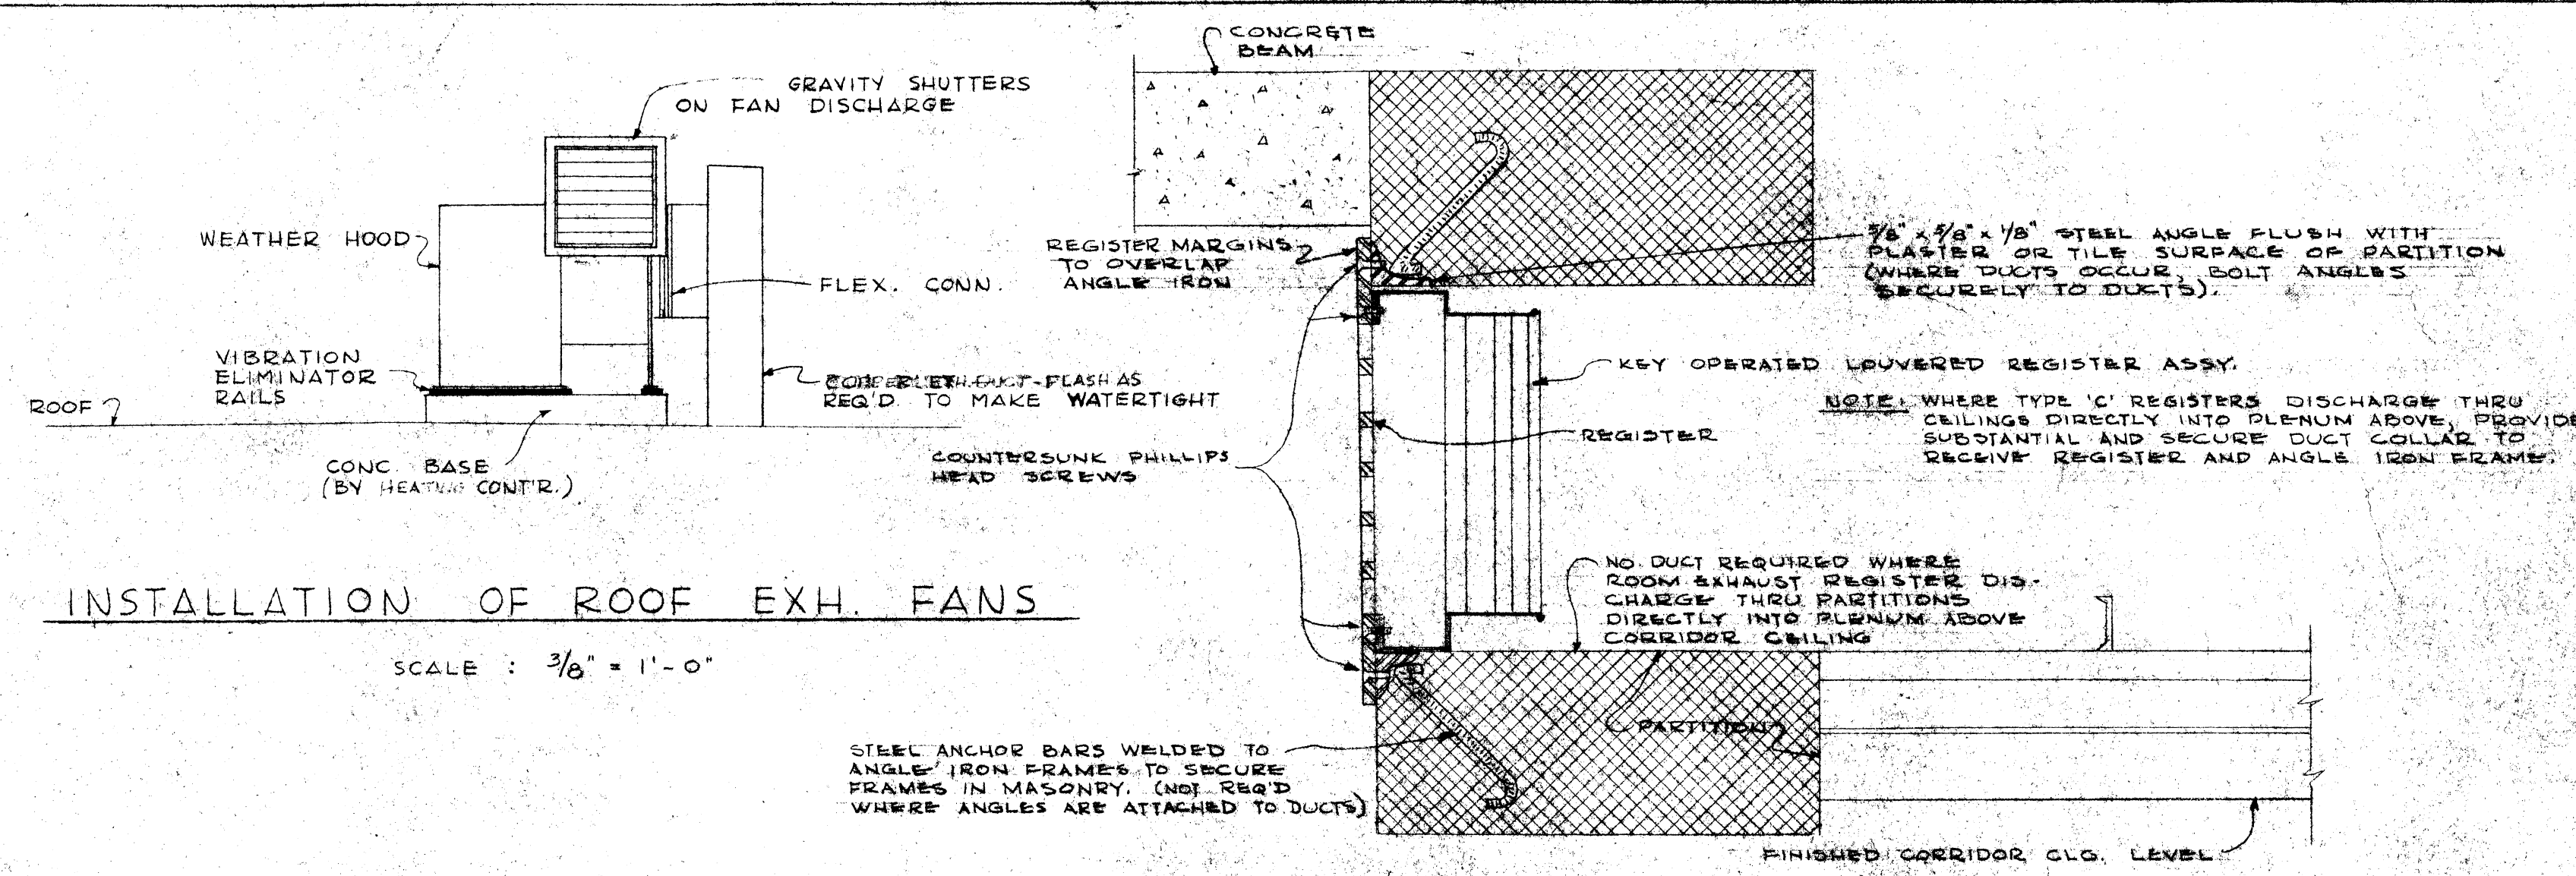

TYPICAL DETAIL
TYPE 'C' REGISTER IN PATIENT'S WING
NO SCALE

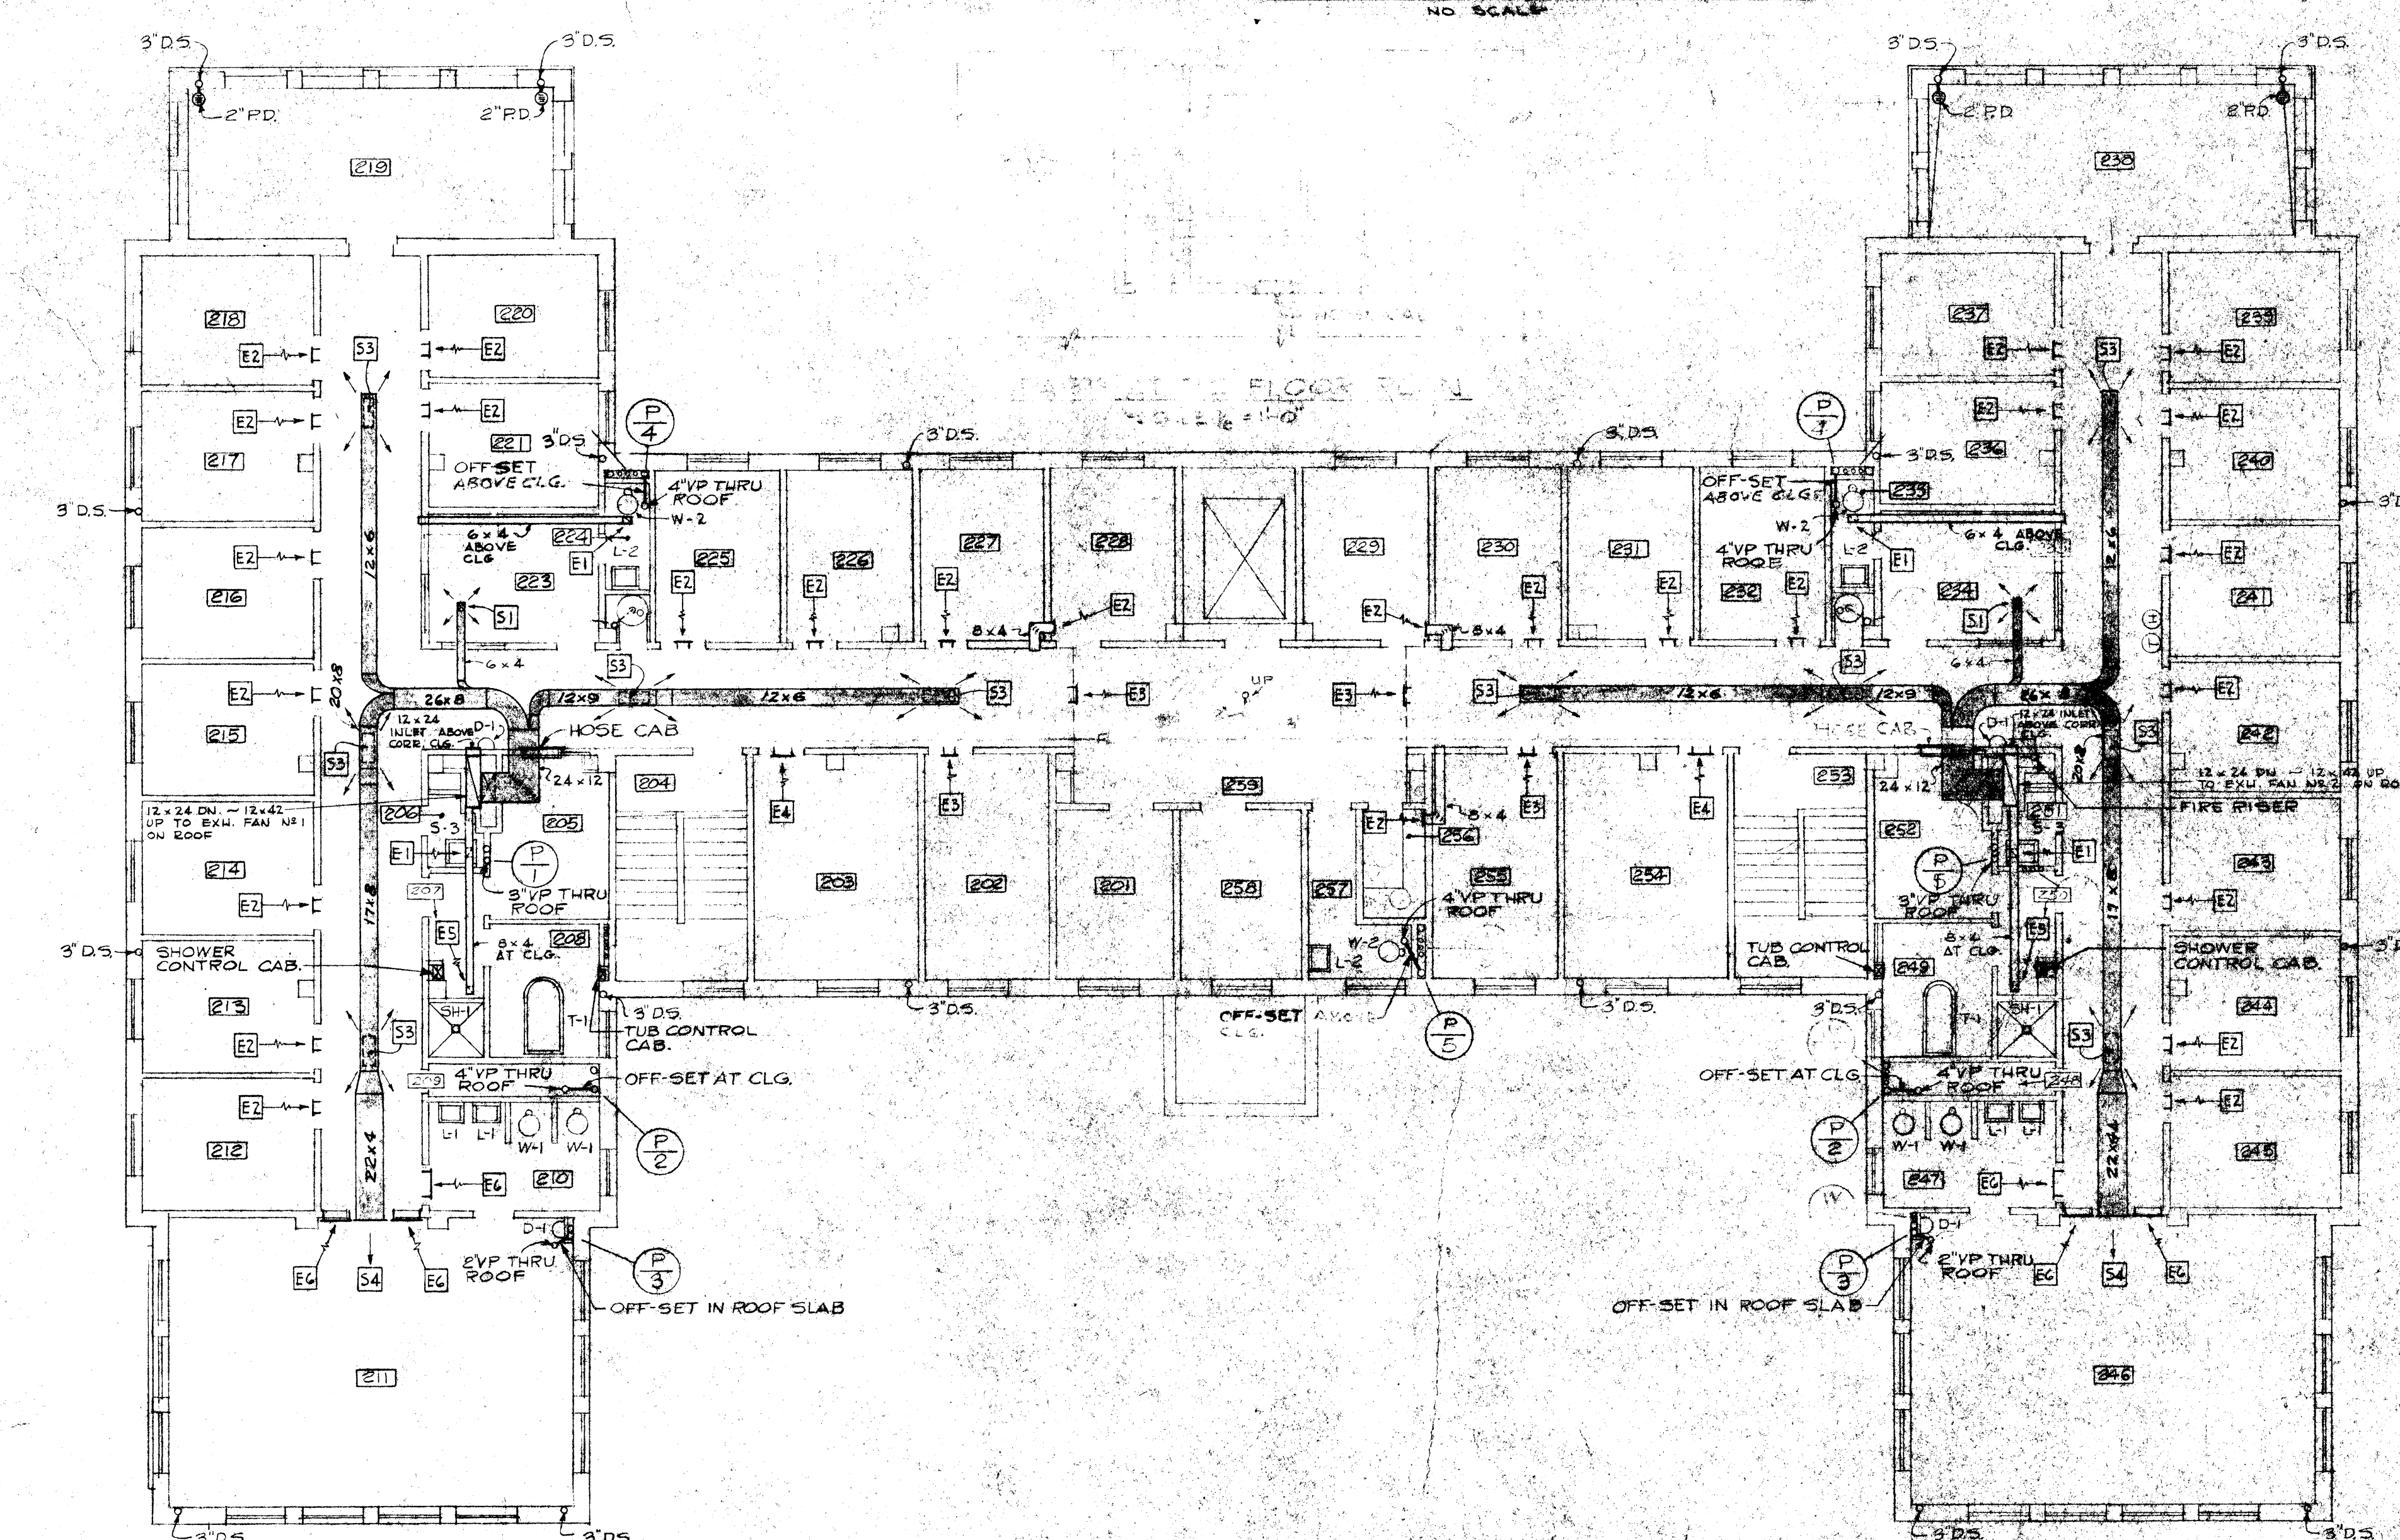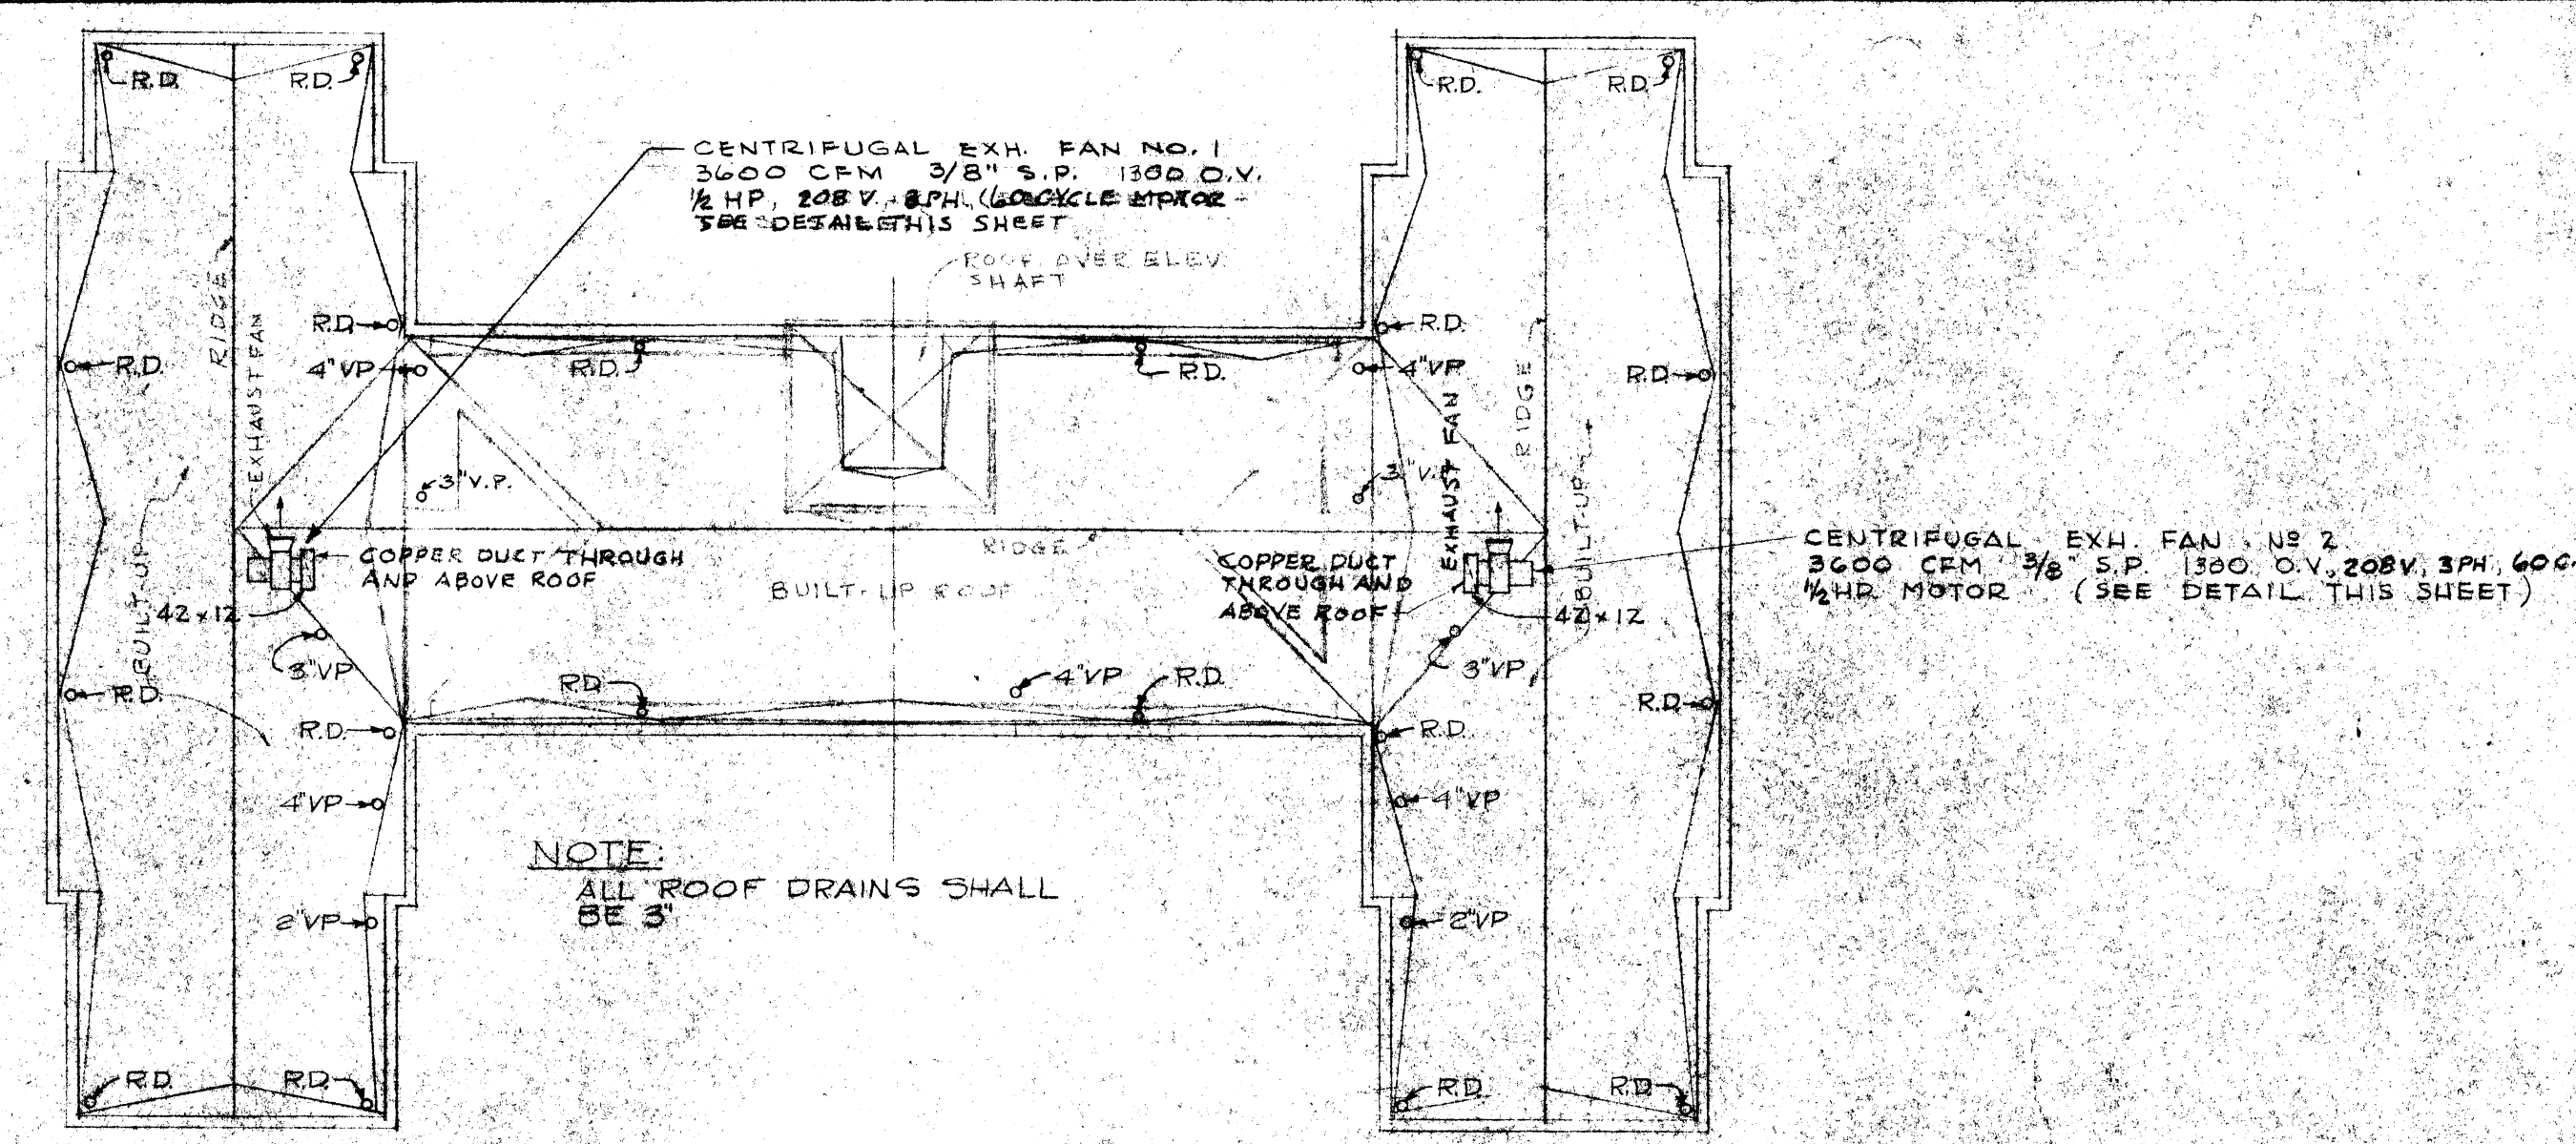

WESTERN STATE HOSPITAL

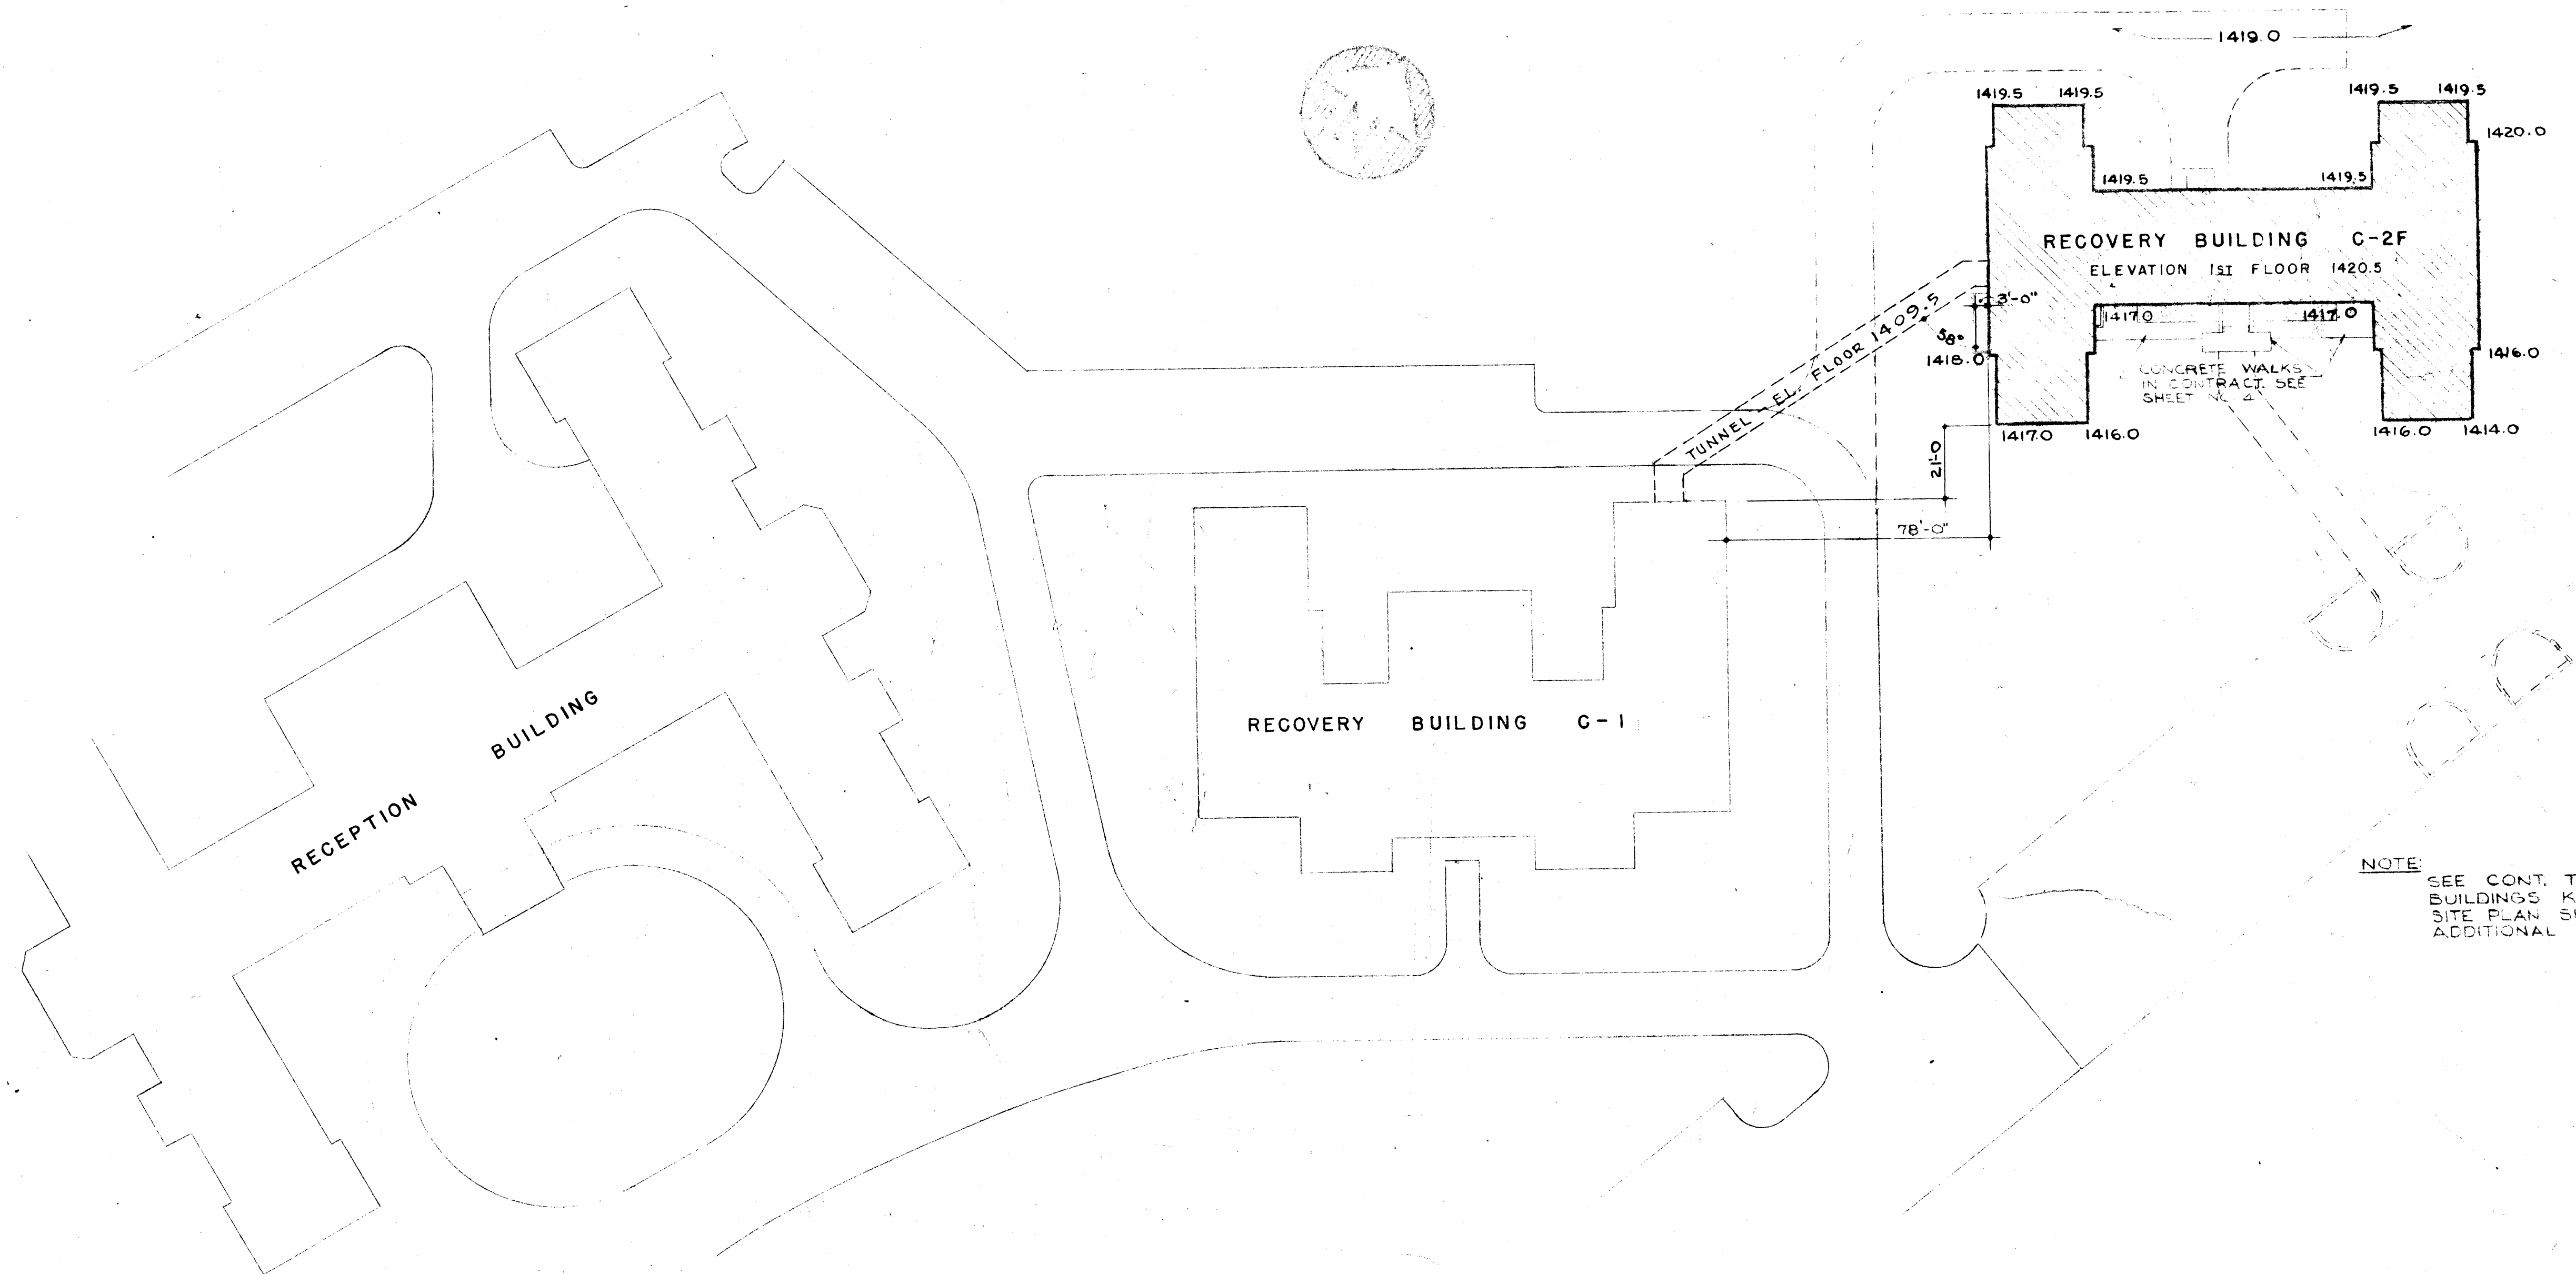

PLOT PLAN

SCALE: 1" = 30'-0"

DEPARTMENT OF MENTAL HYGIENE AND HOSPITALS

DR. HIRAM W. DAVIS - COMMISSIONER

WESTERN STATE HOSPITAL, STAUNTON, VIRGINIA

DR. JAMES B. PETTIS - SUPERINTENDENT

STRUCTURAL: REVISED AND SITE ADAPTED
BY
TORRENCE AND DREELIN—CONSULTING ENGINEERS
MECHANICAL: REVISED AND SITE ADAPTED
BY
WILEY AND WILSON —CONSULTING ENGINEERS

HENRY W. ROBERTS
CONSULTING STRUCTURAL ENGINEER
RICHMOND, VIRGINIA





LANIER & LEVY, INC.
CONSULTING MECHANICAL ENGINEERS
WASHINGTON, D. C.

B-115
RECOVERY BUILDING C-2F

DATE
SEPT. 1958
REVISED
"AS BUILT"
NOV. 1960

MARCELLUS WRIGHT & SON
ARCHITECTS
100 EAST MAIN STREET
RICHMOND, VIRGINIA

SHEET
1
OF 12

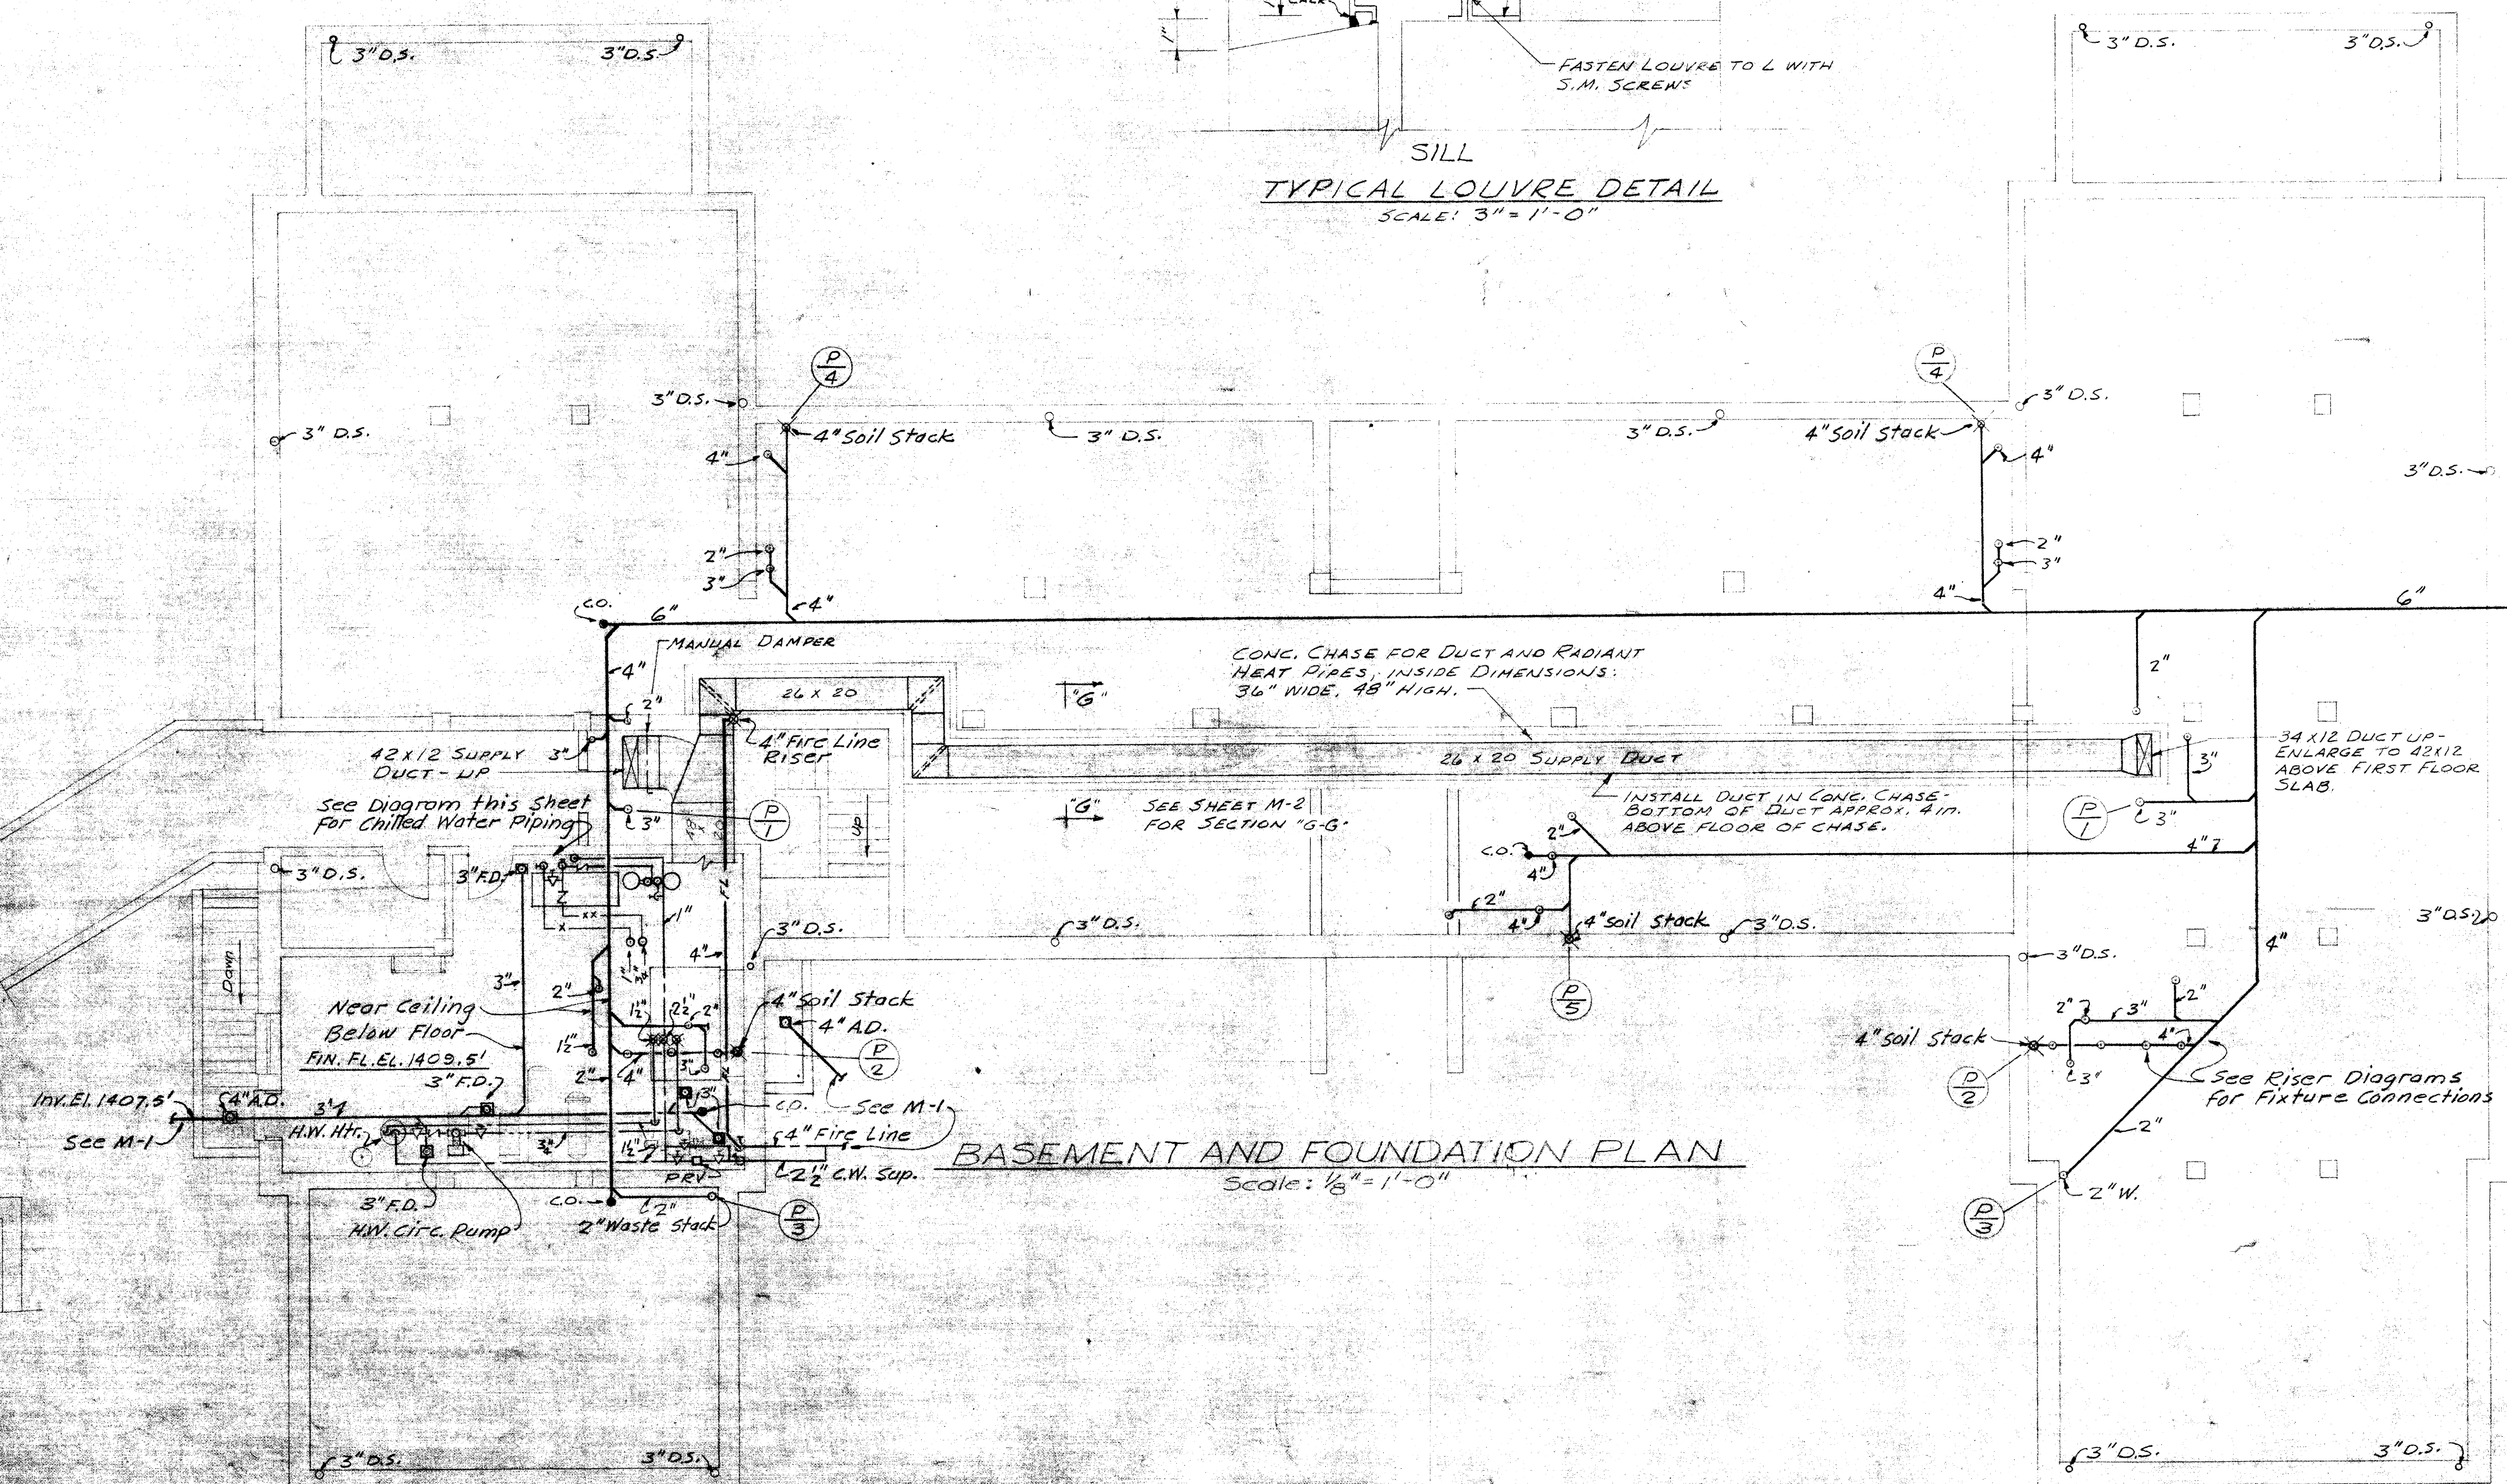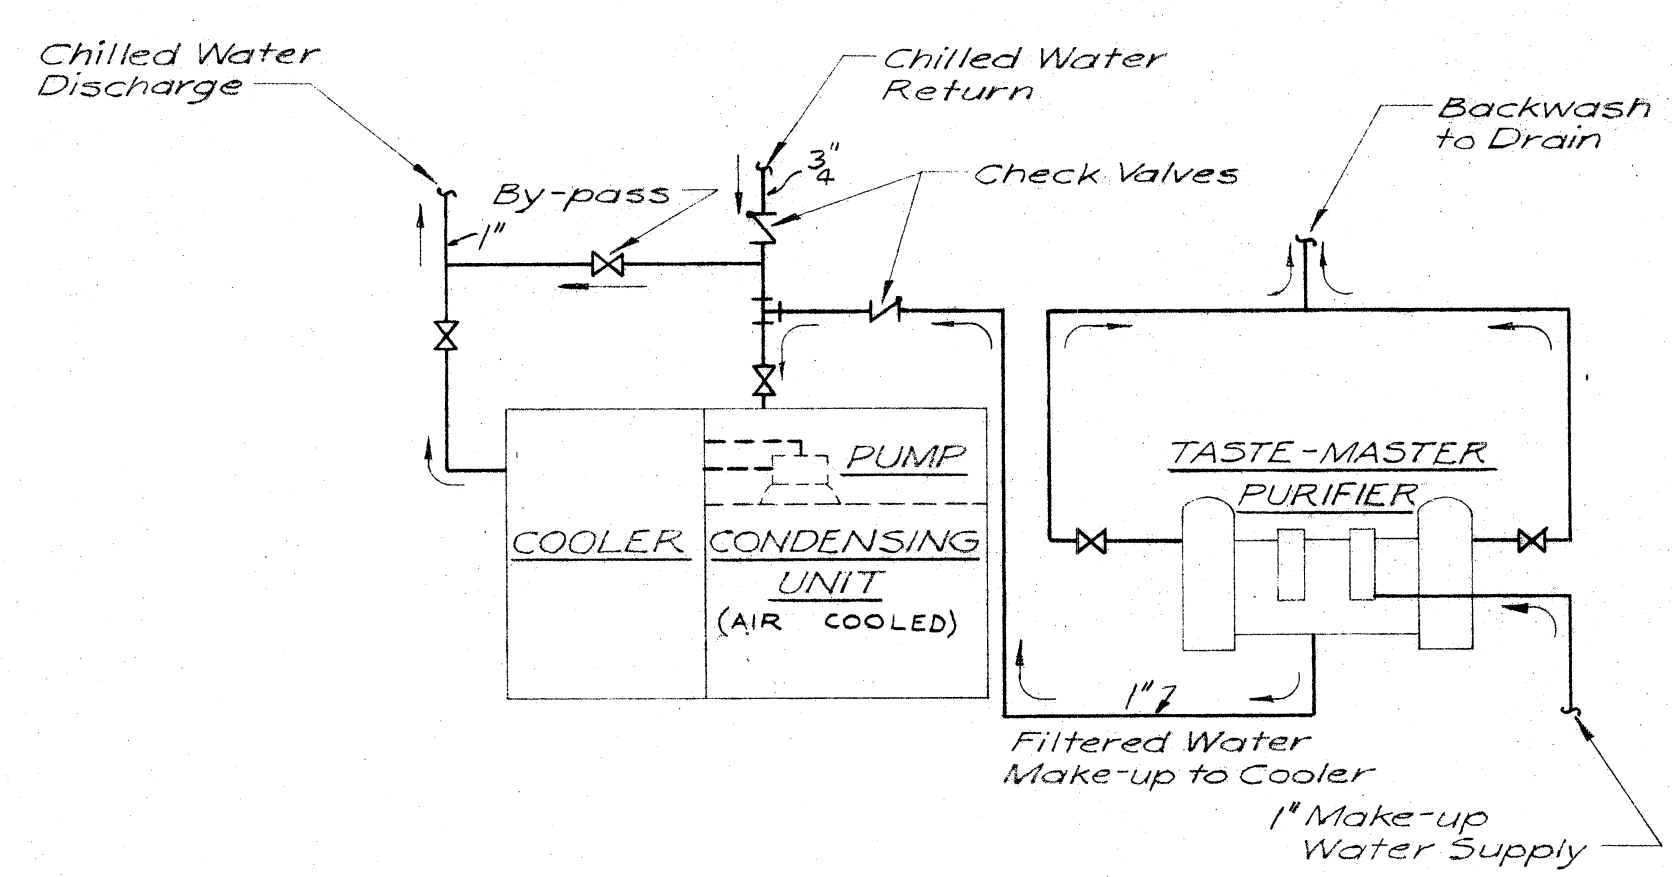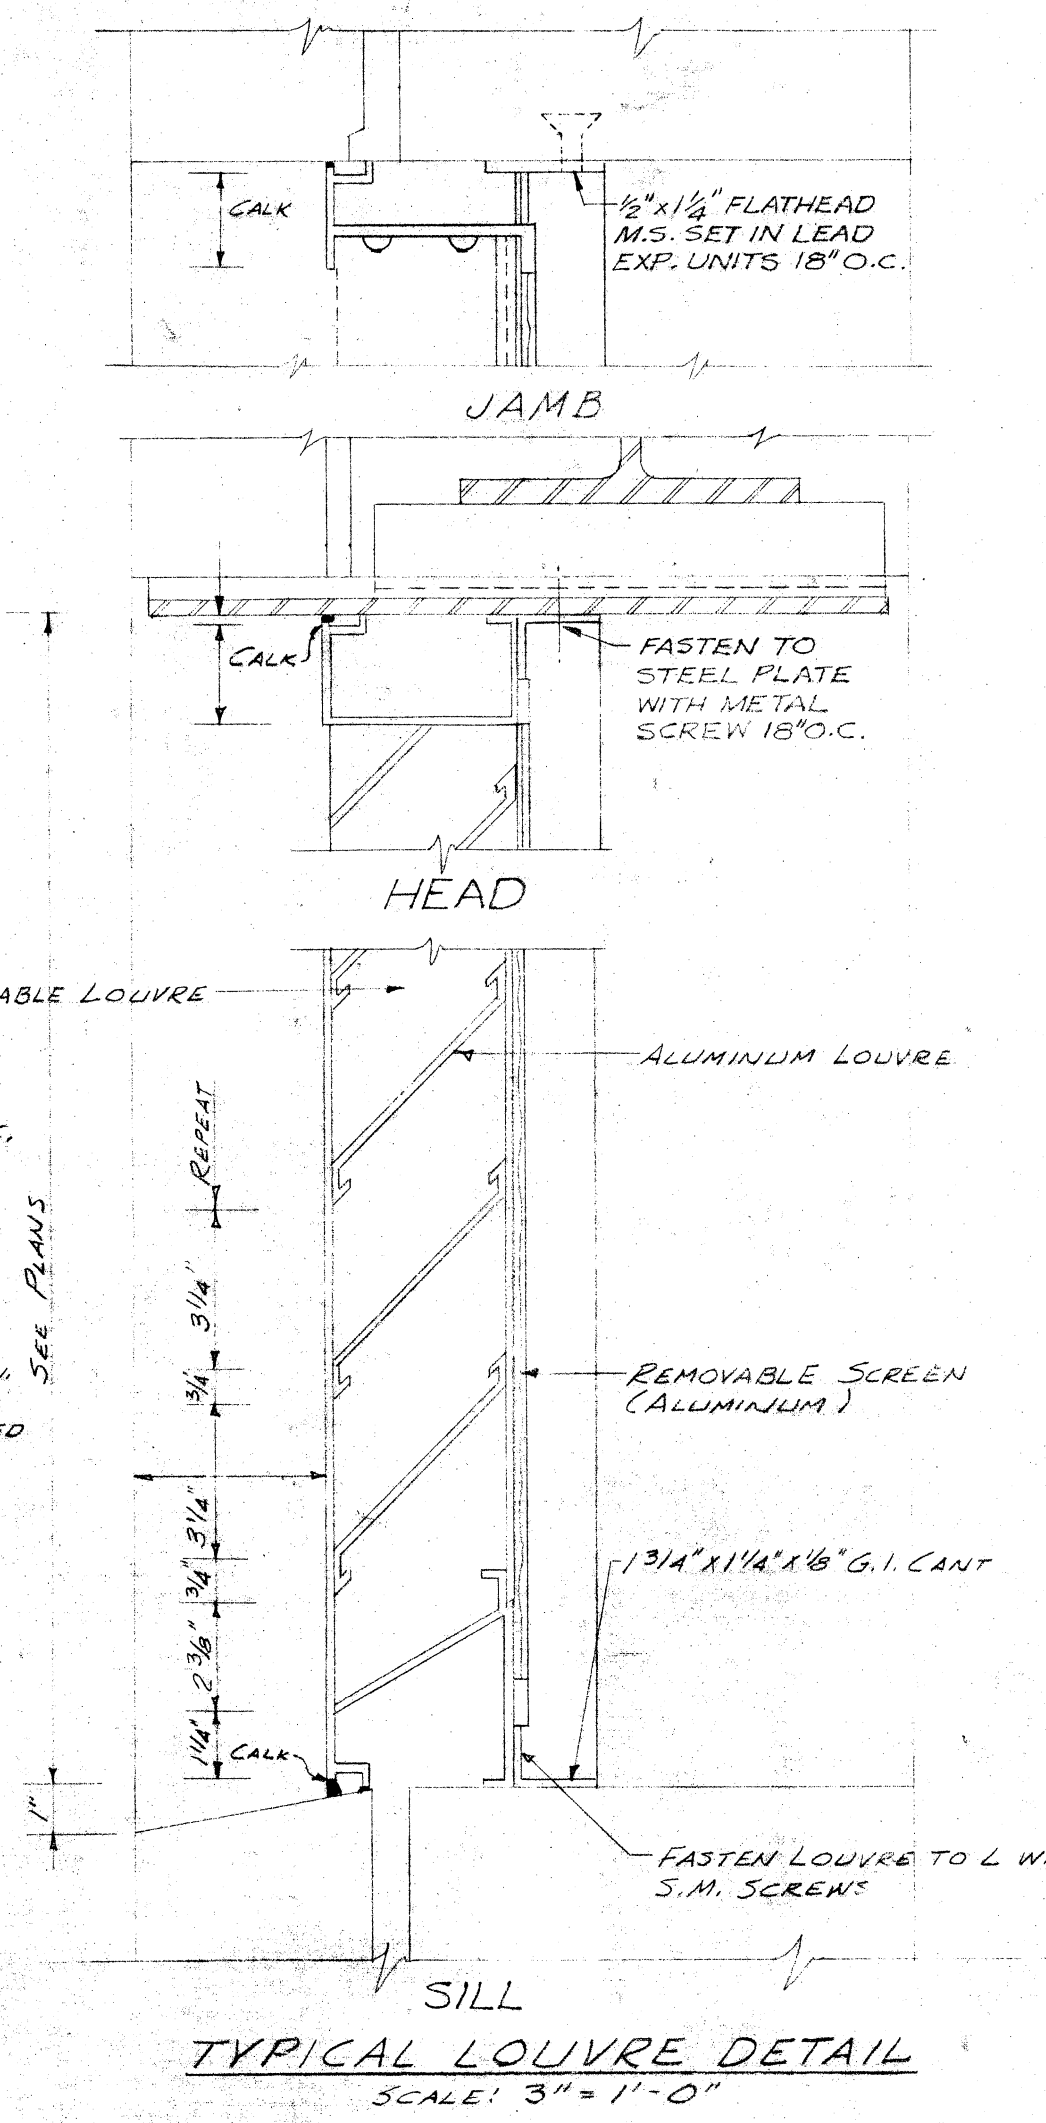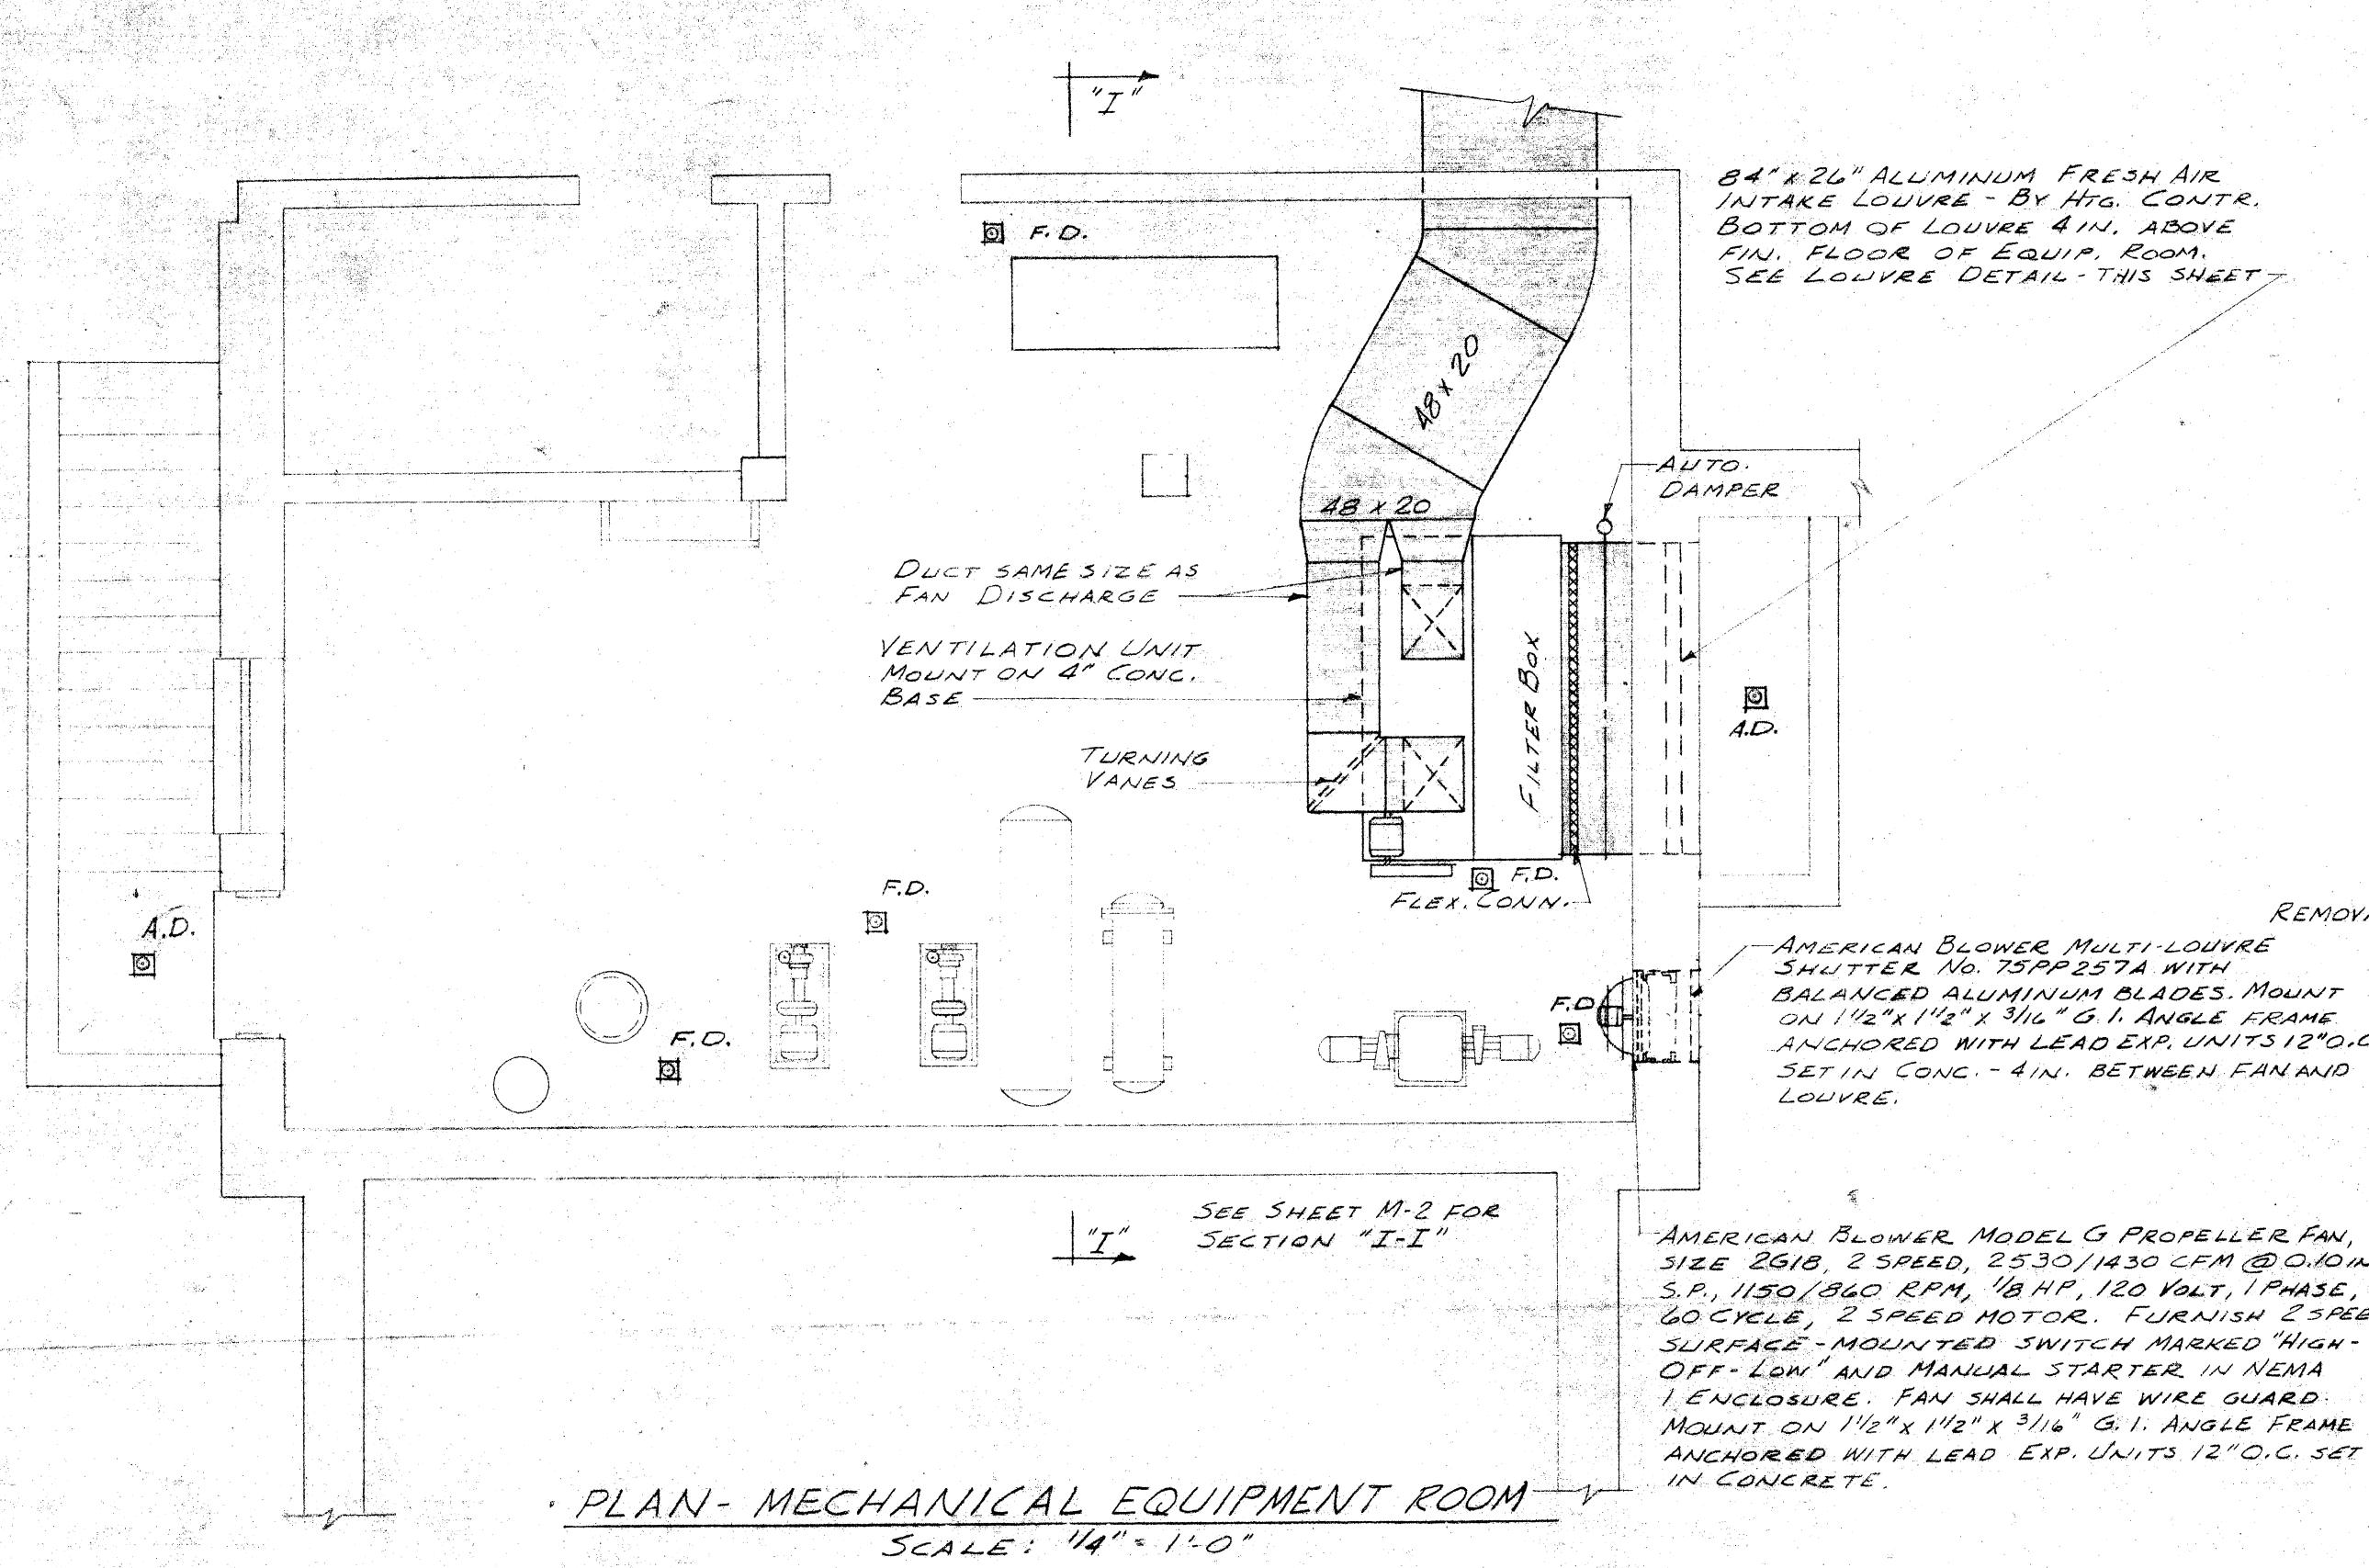

PLUMBING AND VENTILATION
BASEMENT PLAN

RECOVERY BUILDING C-2F

WESTERN STATE HOSPITAL
WAYNESBORO ROAD
STAUNTON VIRGINIA

DATE SEPT 1958	MARCELLUS WRIGHT & SON ARCHITECTS 100 EAST MAIN STREET RICHMOND, VIRGINIA	SHEET M 5 OF 11
WILEY & WILSON CONSULTING ENGINEERS LYNCHBURG, VA. RICHMOND, VA.	REVISED AS BUILT NOV 1960	