



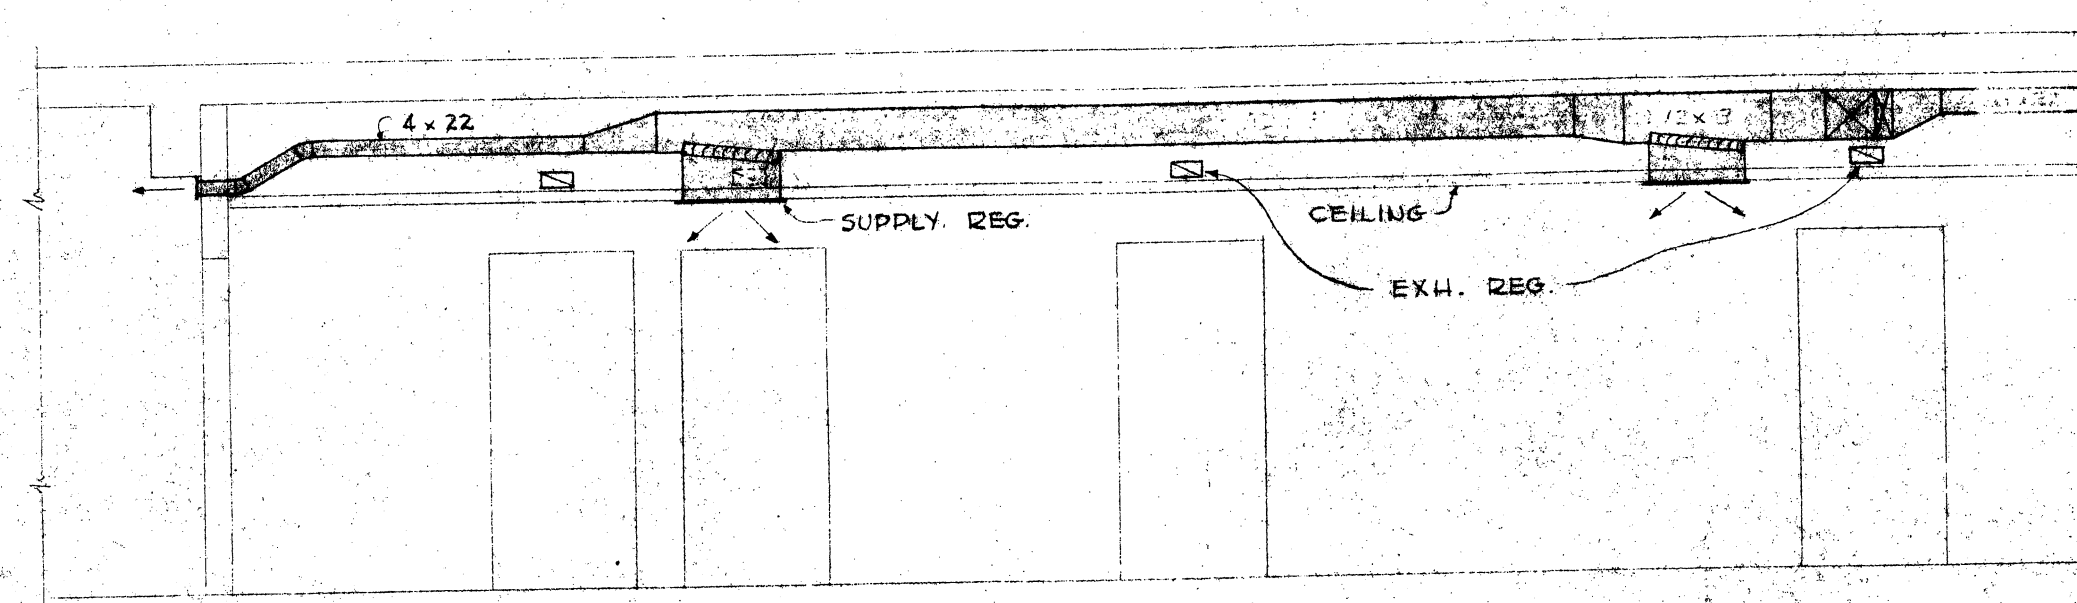


SECTION 'A-A'
SCALE: 1/4" = 1'-0"

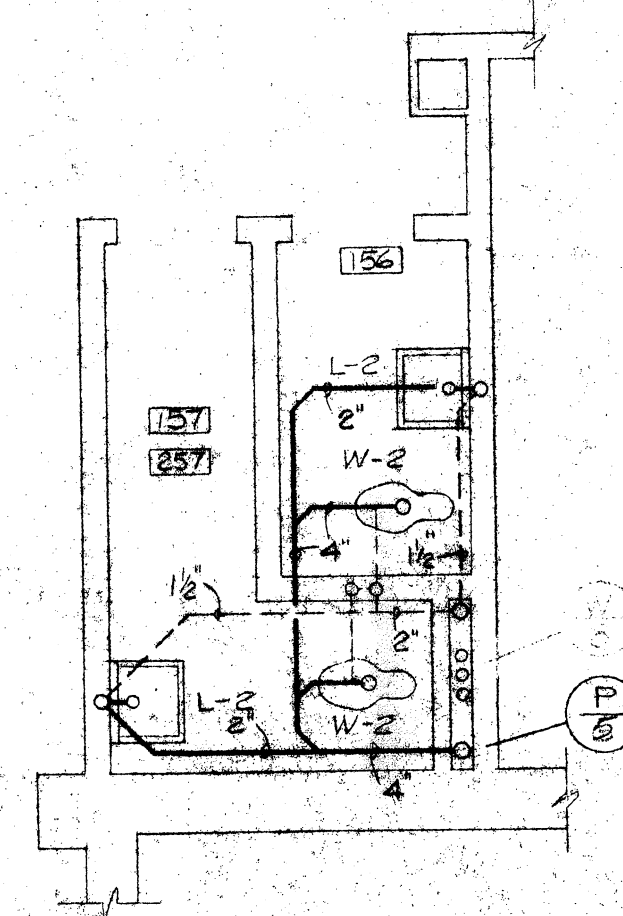

TOILET ROOM DETAIL
SCALE: 1/4" = 1'-0"

REGISTER SCHEDULE				
EXHAUST				
SYMBOL	SIZE	CEM	LOCATION	# TYPE
E1	6x6	45	CLG	C
E2	8x4	65	WALL	C
E3	10x4	85	WALL	C
E4	14x4	110	WALL	C
E5	8x6	110	CLG	C
E6	22x4	165	WALL	B
E7	8x12	175	WALL	C
E8	8x12	175	WALL	C
E9	8x12	175	WALL	C
SUPPLY				
S1	6x6	45	CLG	D
S2	12x12	35	CLG	A
S3	24x12	175	CLG	D
S4	22x4	325	WALL	A
S5	48x24	2250	CLG	A

* SEE SPECIFICATIONS FOR 'TYPE' DESCRIPTION.

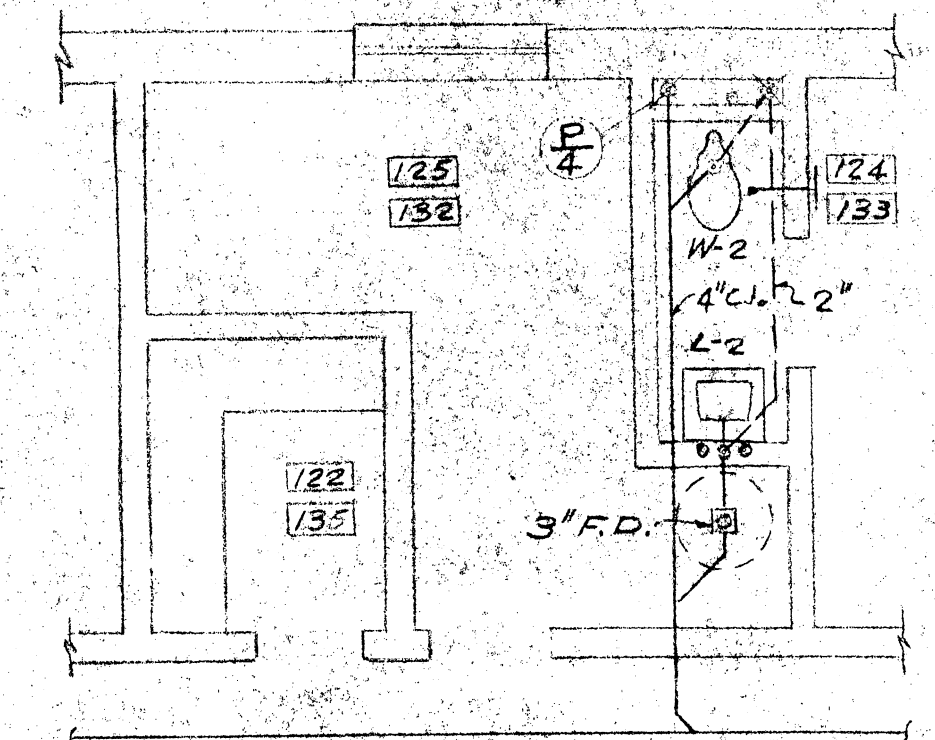


TOILET ROOM DETAIL
SCALE: 1/4" = 1'-0"

NOTES:


1. SEE SITE PLAN FOR PLUMBING SYMBOLS.

113
112
118
117
116

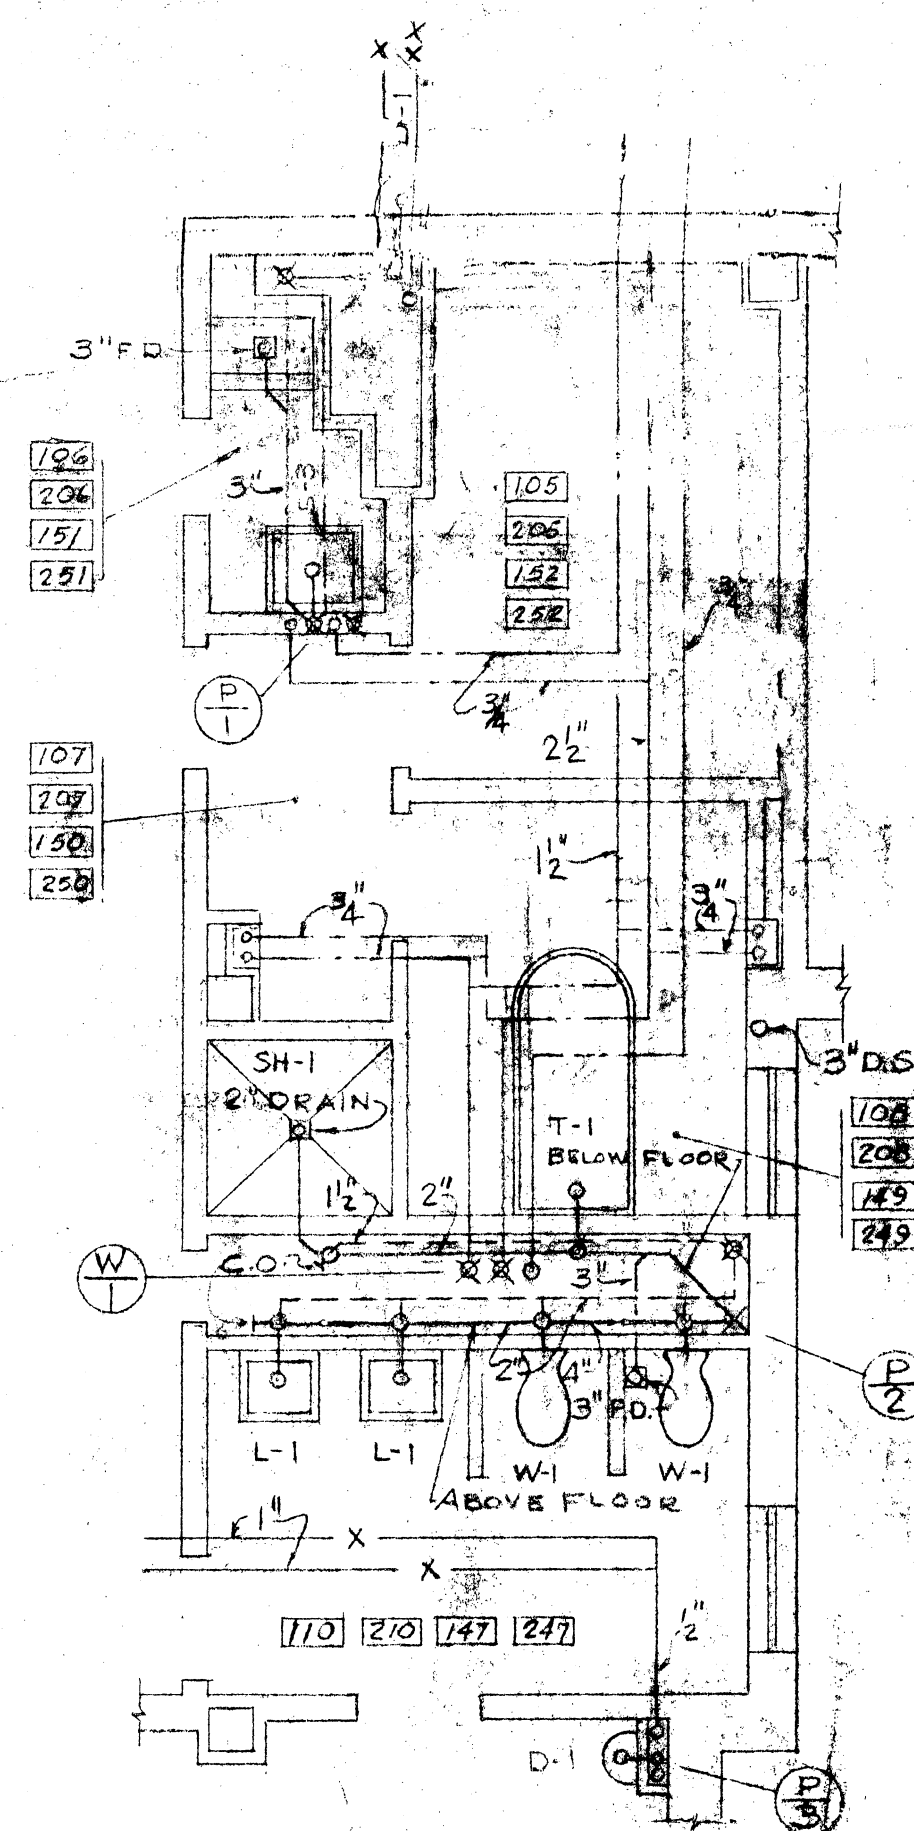

TOILET ROOM DETAIL
SCALE: 1/4" = 1'-0"

SAN SEWER TYPICAL NORTH & SOUTH WING. SEE WATER PIPING RISER DIAGRAM FOR WATER DISTRIBUTION NORTH WING.

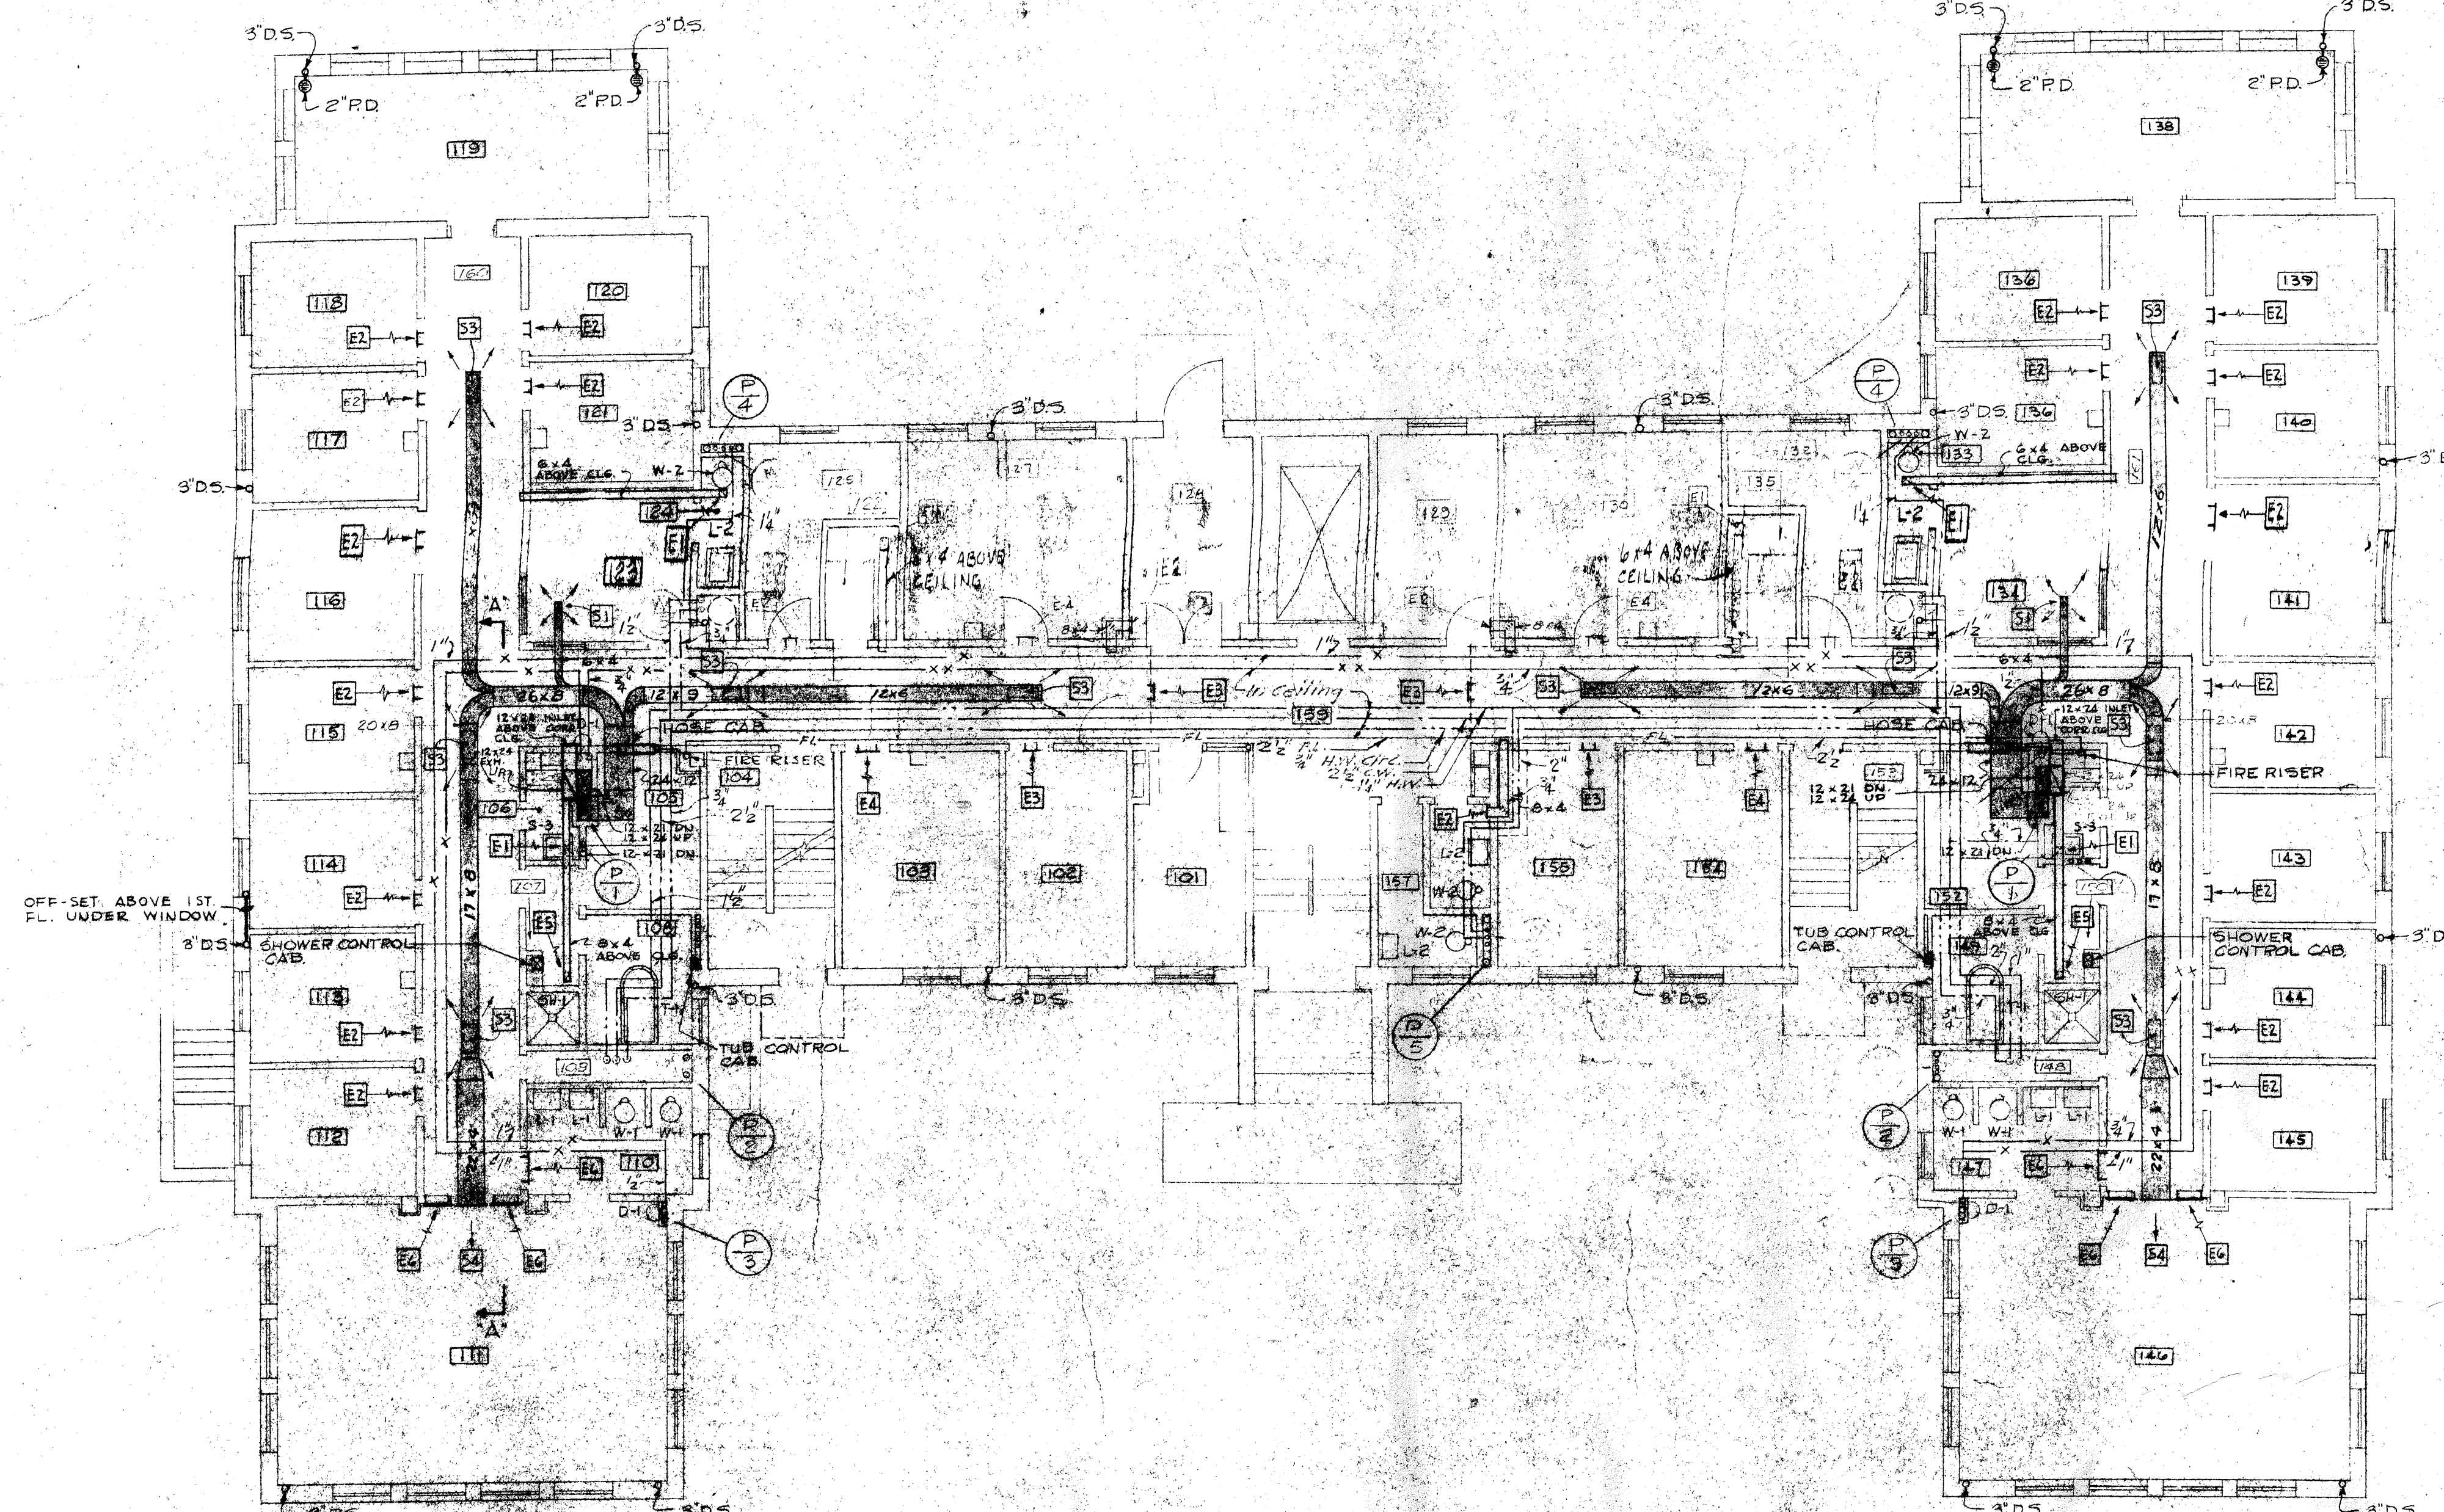

FIRST FLOOR PLAN
SCALE: 1/8" = 1'-0"

PLUMBING & VENTILATION
FIRST FLOOR PLAN


RECOVERY BUILDING C-2F
WESTERN STATE HOSPITAL
WAYNEBORO ROAD
STAUNTON, VIRGINIA

SITE ADAPTED BY
WILEY & WILSON
CONSULTING ENGINEERS
LYNCHBURG, VA. - RICHMOND, VA.

DATE
SEPT. 1958
REVISED
AS BUILT
NOV. 1960

MARCELLUS WRIGHT & SON
ARCHITECTS
100 EAST MAIN STREET
RICHMOND, VIRGINIA


SHEET
M6
OF 11

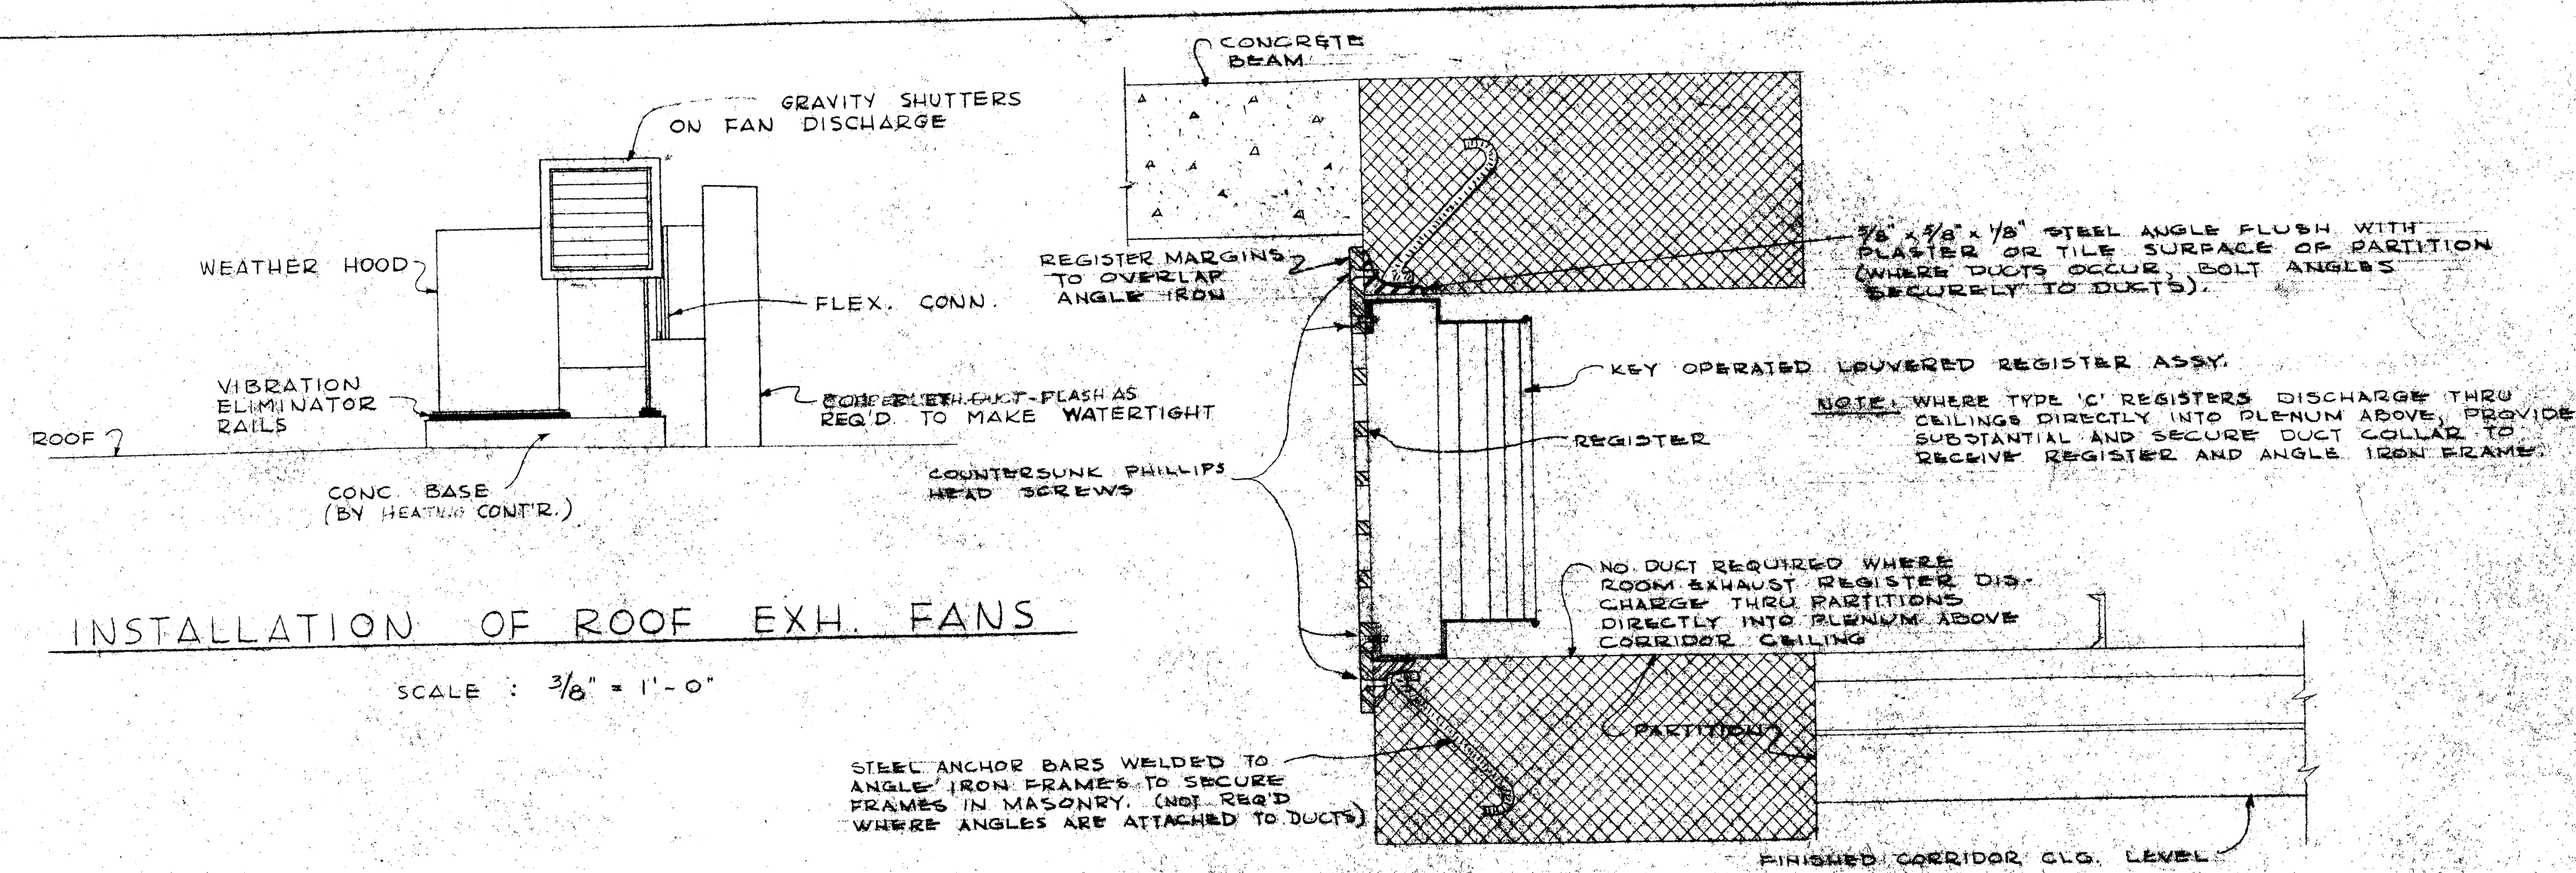


INSTALLATION OF ROOF EXH. FANS

SCALE: $\frac{3}{8}" = 1'-0"$


TYPICAL DETAIL
TYPE 'C' REGISTER IN PATIENT'S WING
NO SCALE

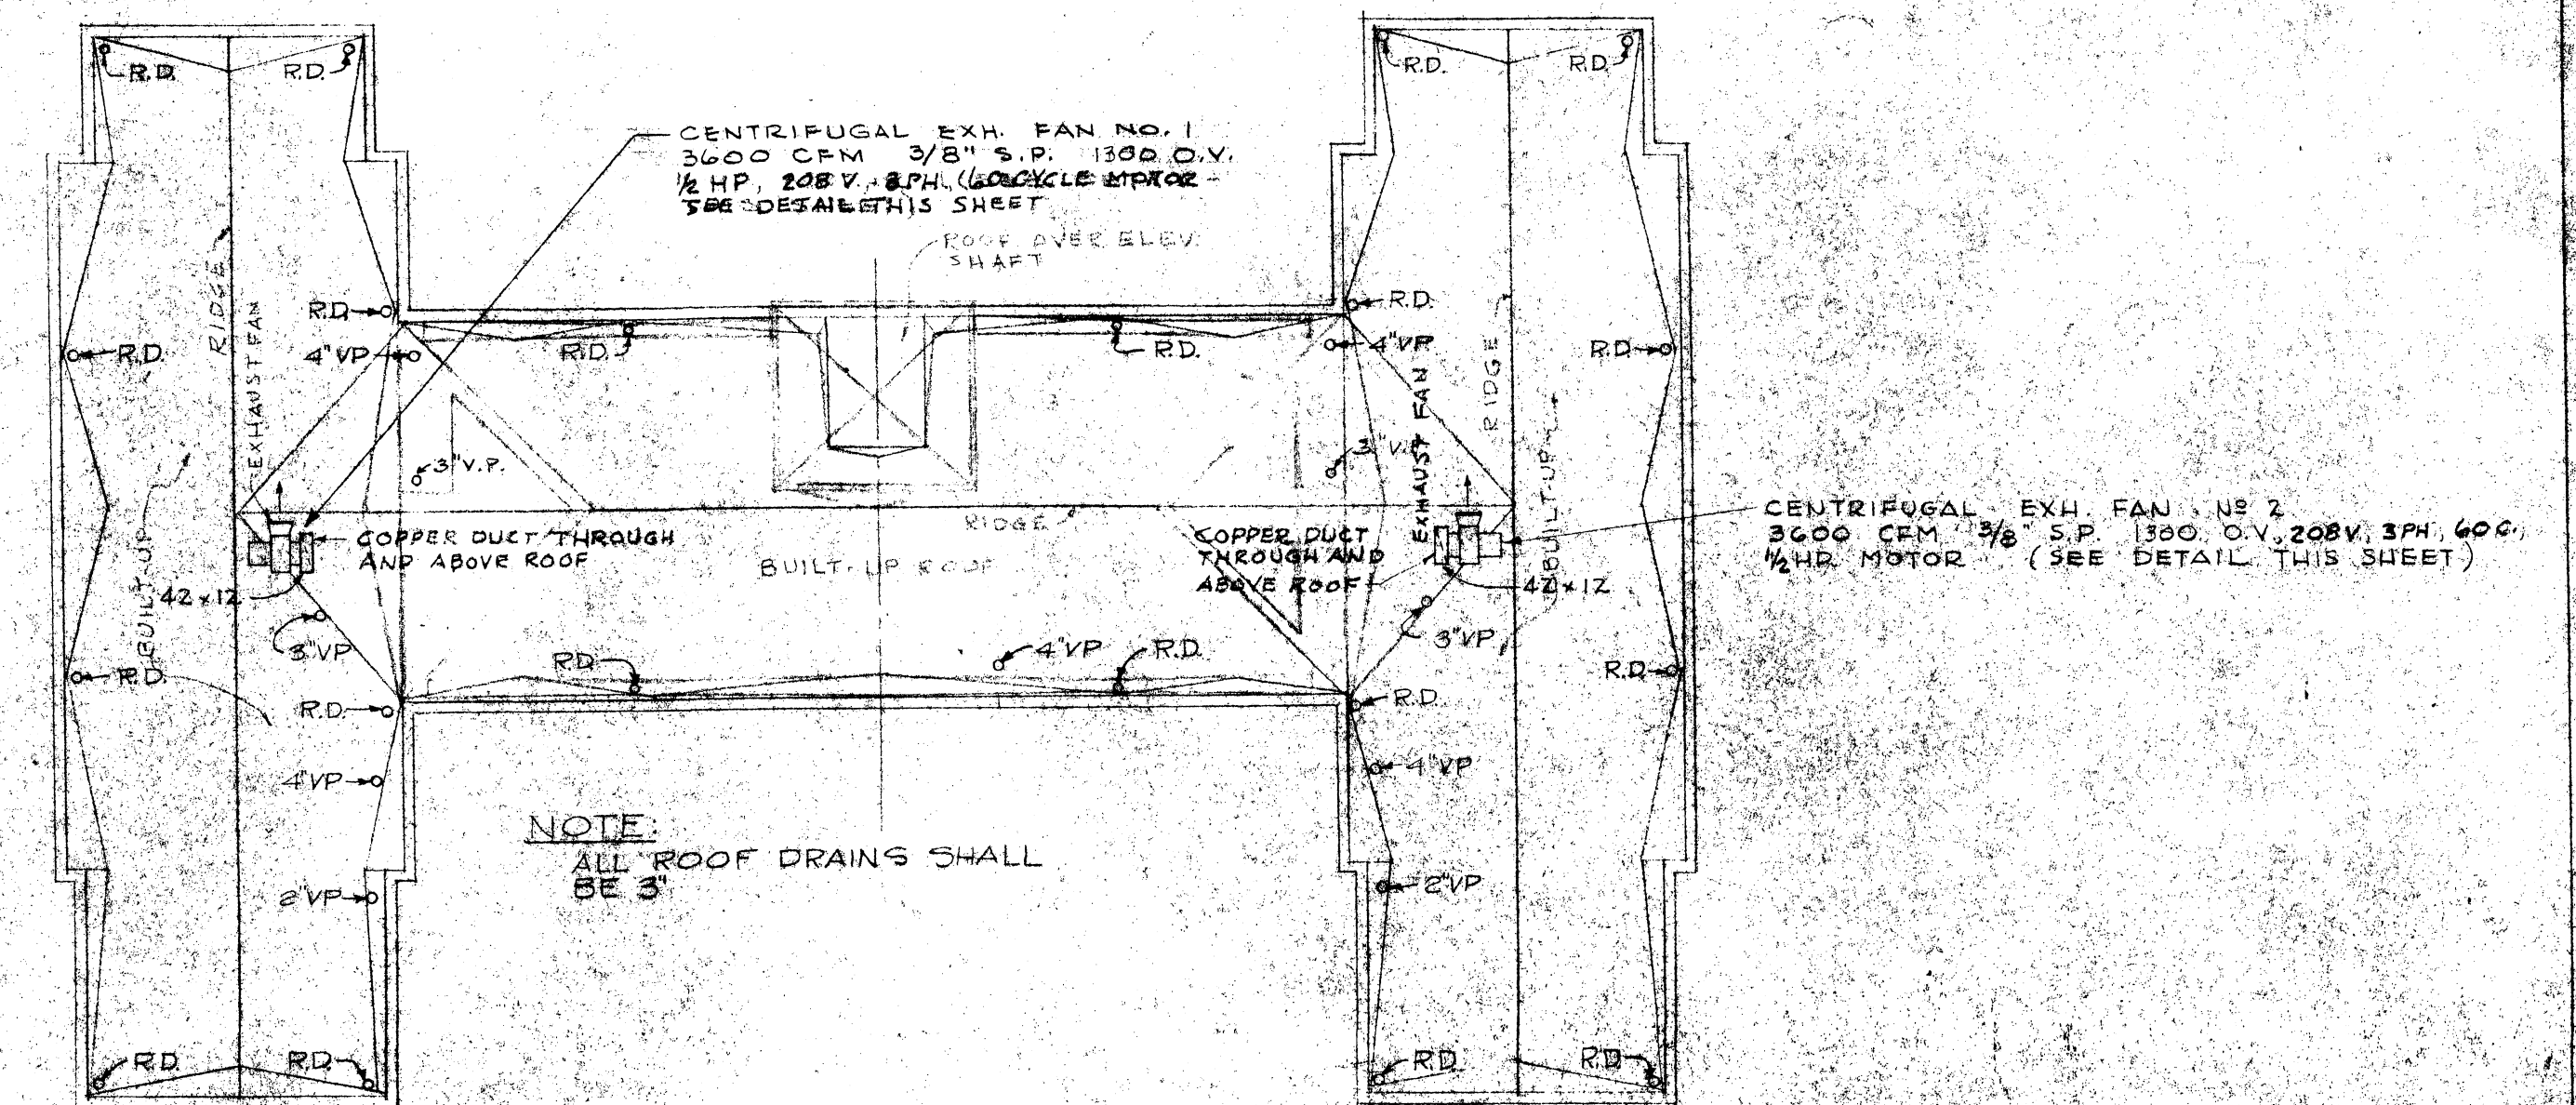

ROOF PLAN
SCALE $\frac{1}{8}" = 1'-0"$

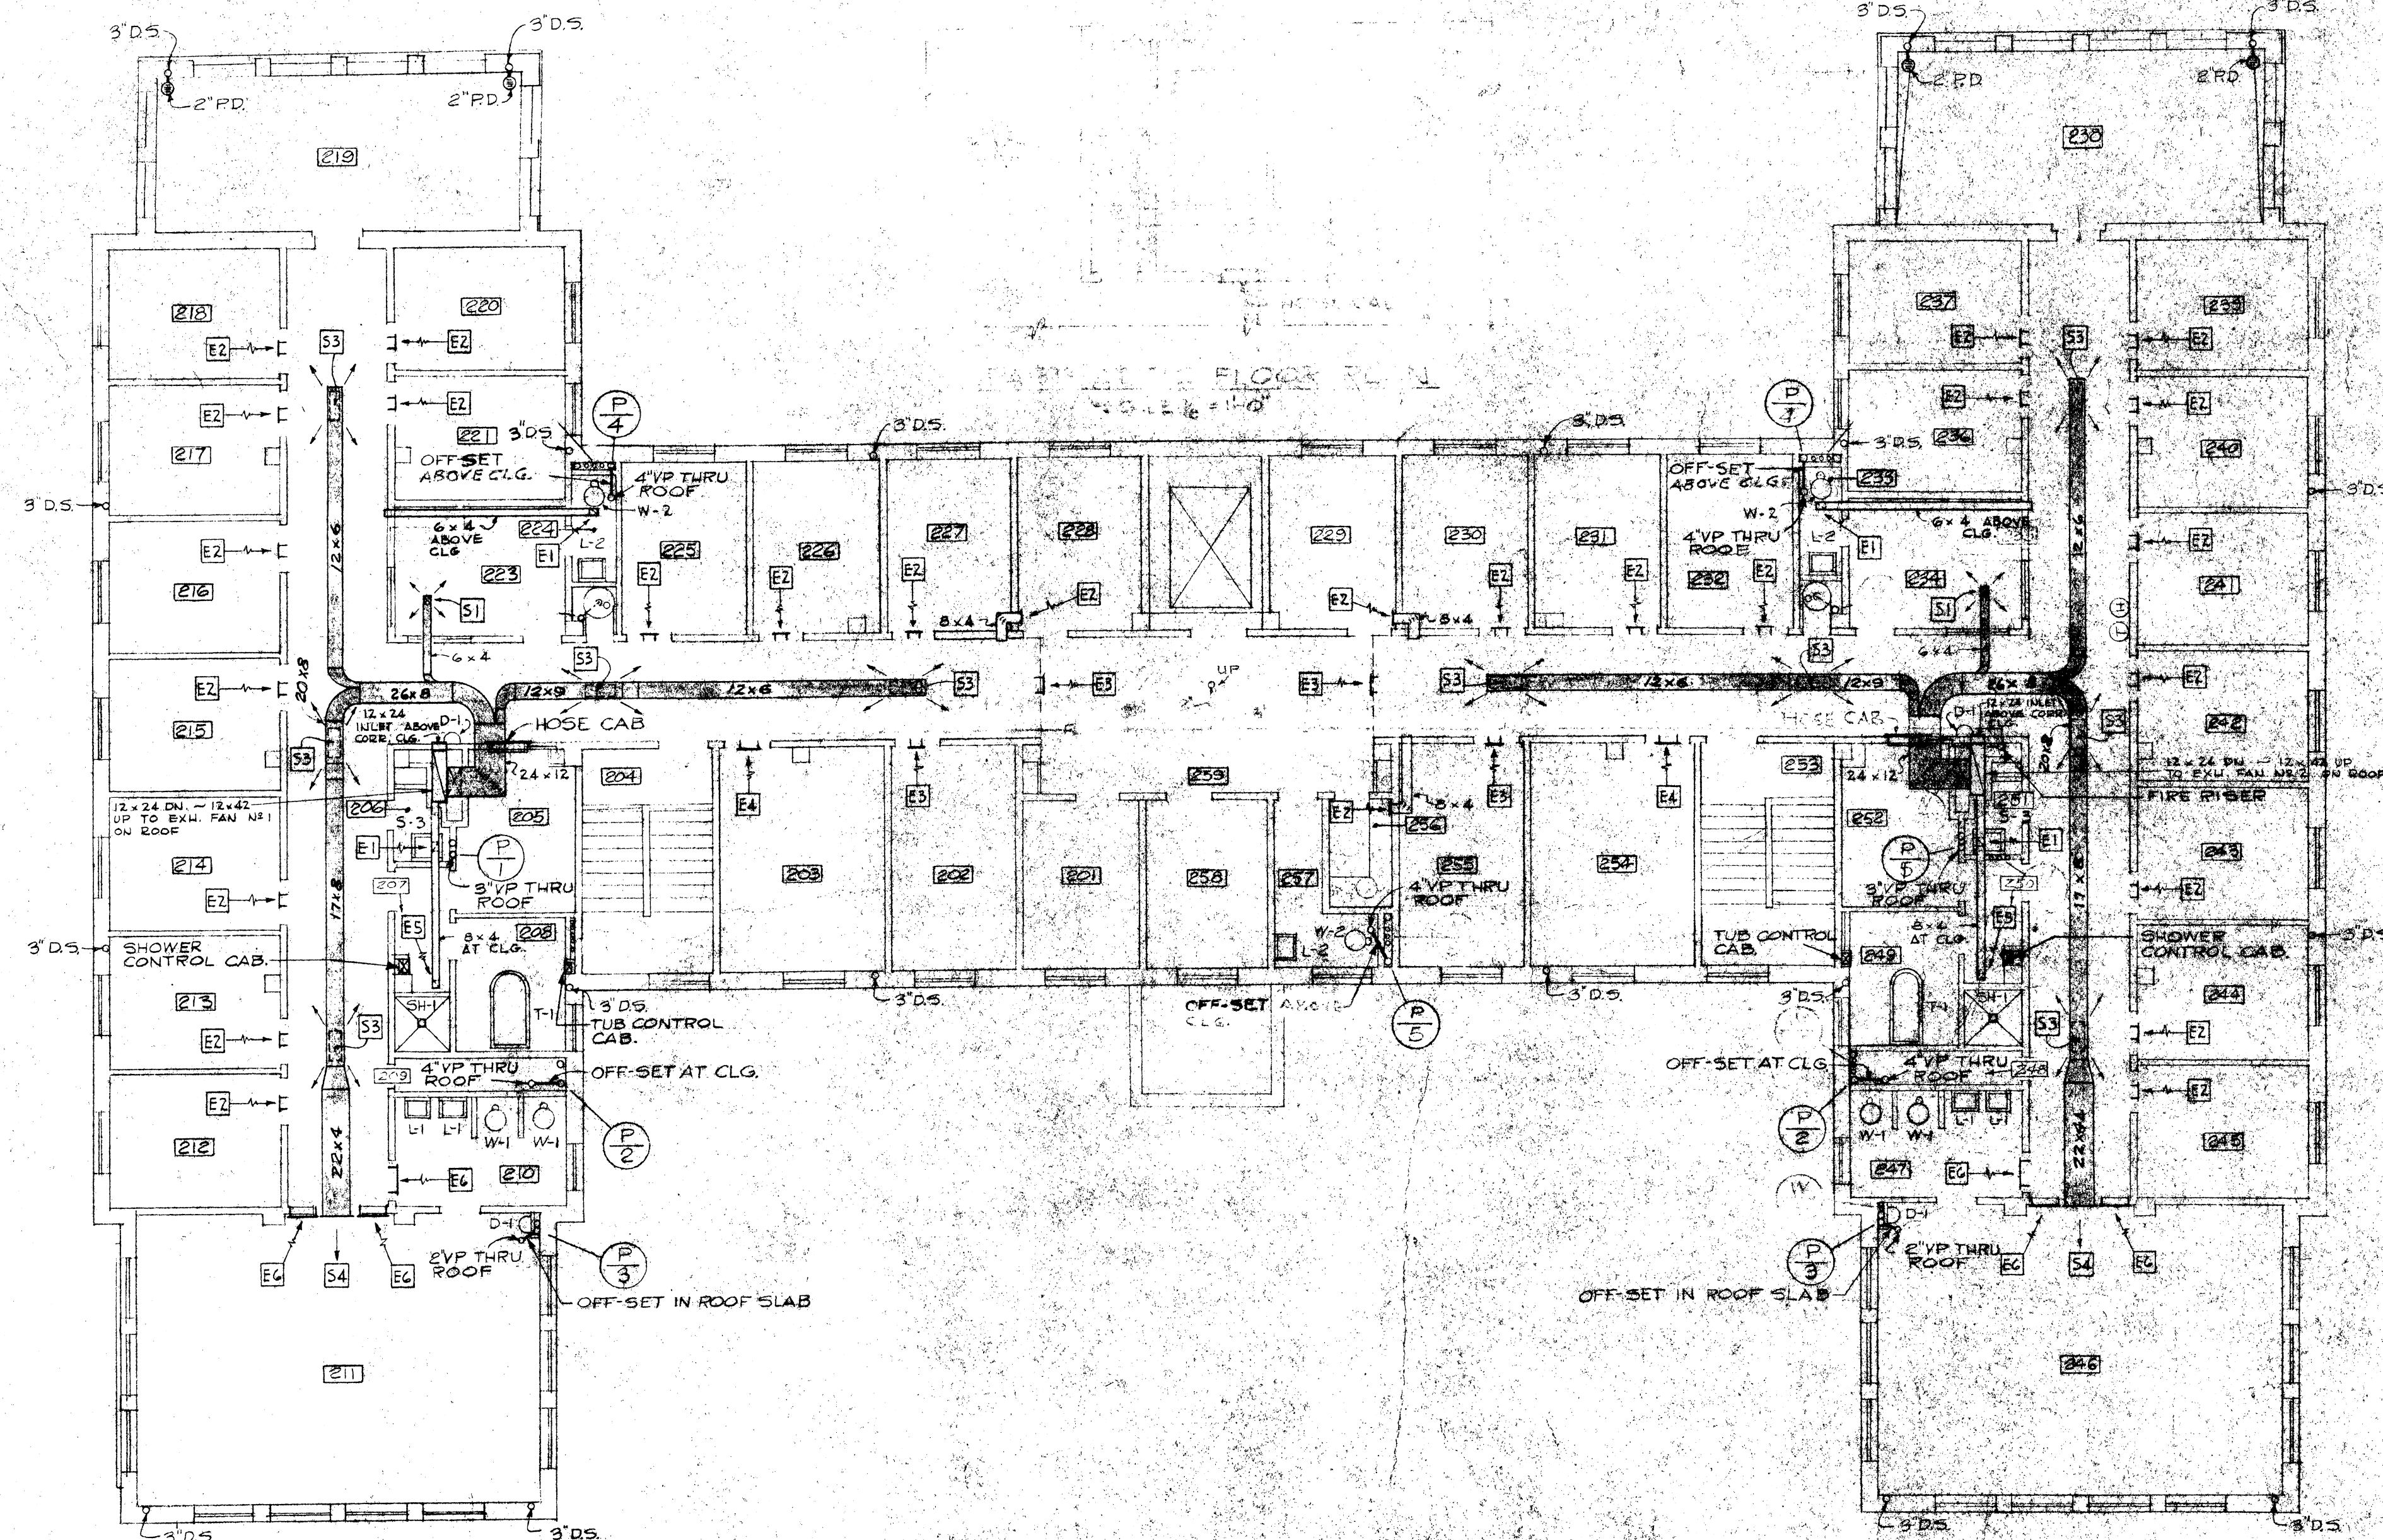

SECOND FLOOR PLAN
SCALE $\frac{1}{8}" = 1'-0"$

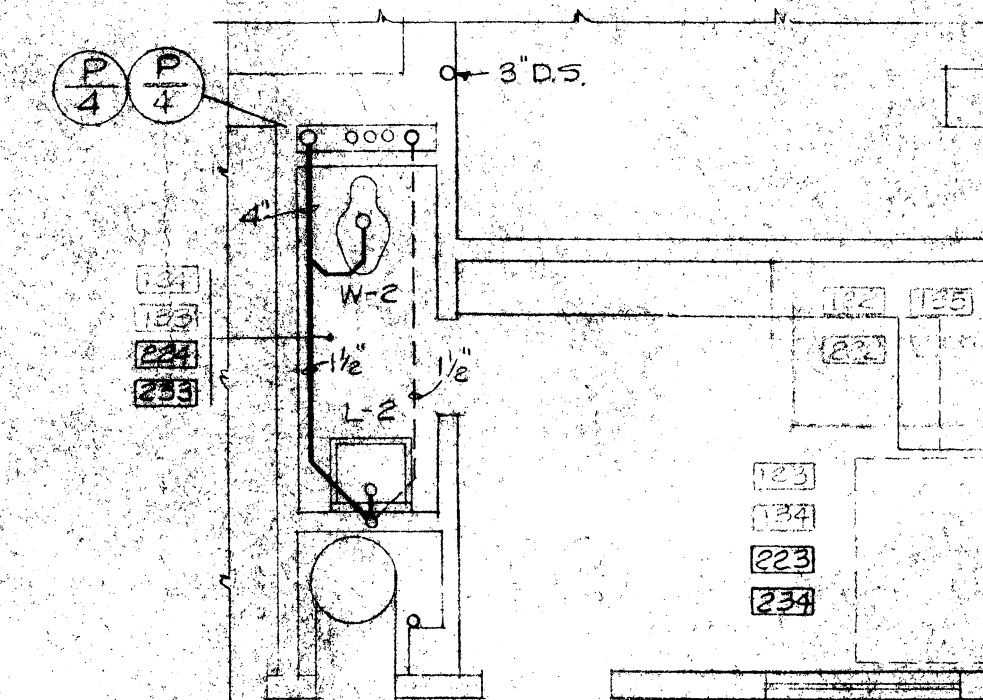

TOILET ROOM DETAIL
SCALE $\frac{1}{4}" = 1'-0"$

- NOTES:
1. SEE SITE PLAN FOR PLUMBING SYMBOLS
 2. PROVIDE 12"x12" ACCESS PANELS AT SECOND FL. NEAR CEILING ABOVE D.F. FOR ACCESS TO AIR VENTS

PLUMBING & VENTILATION
SECOND FLOOR PLAN

SITE ADAPTED BY
WILEY & WILSON
CONSULTING ENGINEERS
LYNCHBURG, VA. RICHMOND, VA.

LANIER & LEVY, INC.
CONSULTING ENGINEERS
WASHINGTON D. C.


RECOVERY BUILDING C-2F
WESTERN STATE HOSPITAL
WAYNESBORO ROAD
STAUNTON VIRGINIA

DATE: SEPT. 1958
REVISION: AS BUILT
NOV. 1960

MARCELLUS WRIGHT & SON
ARCHITECTS
100 EAST MAIN STREET
RICHMOND, VIRGINIA

SHEET
M
OF 11

WESTERN STATE HOSPITAL

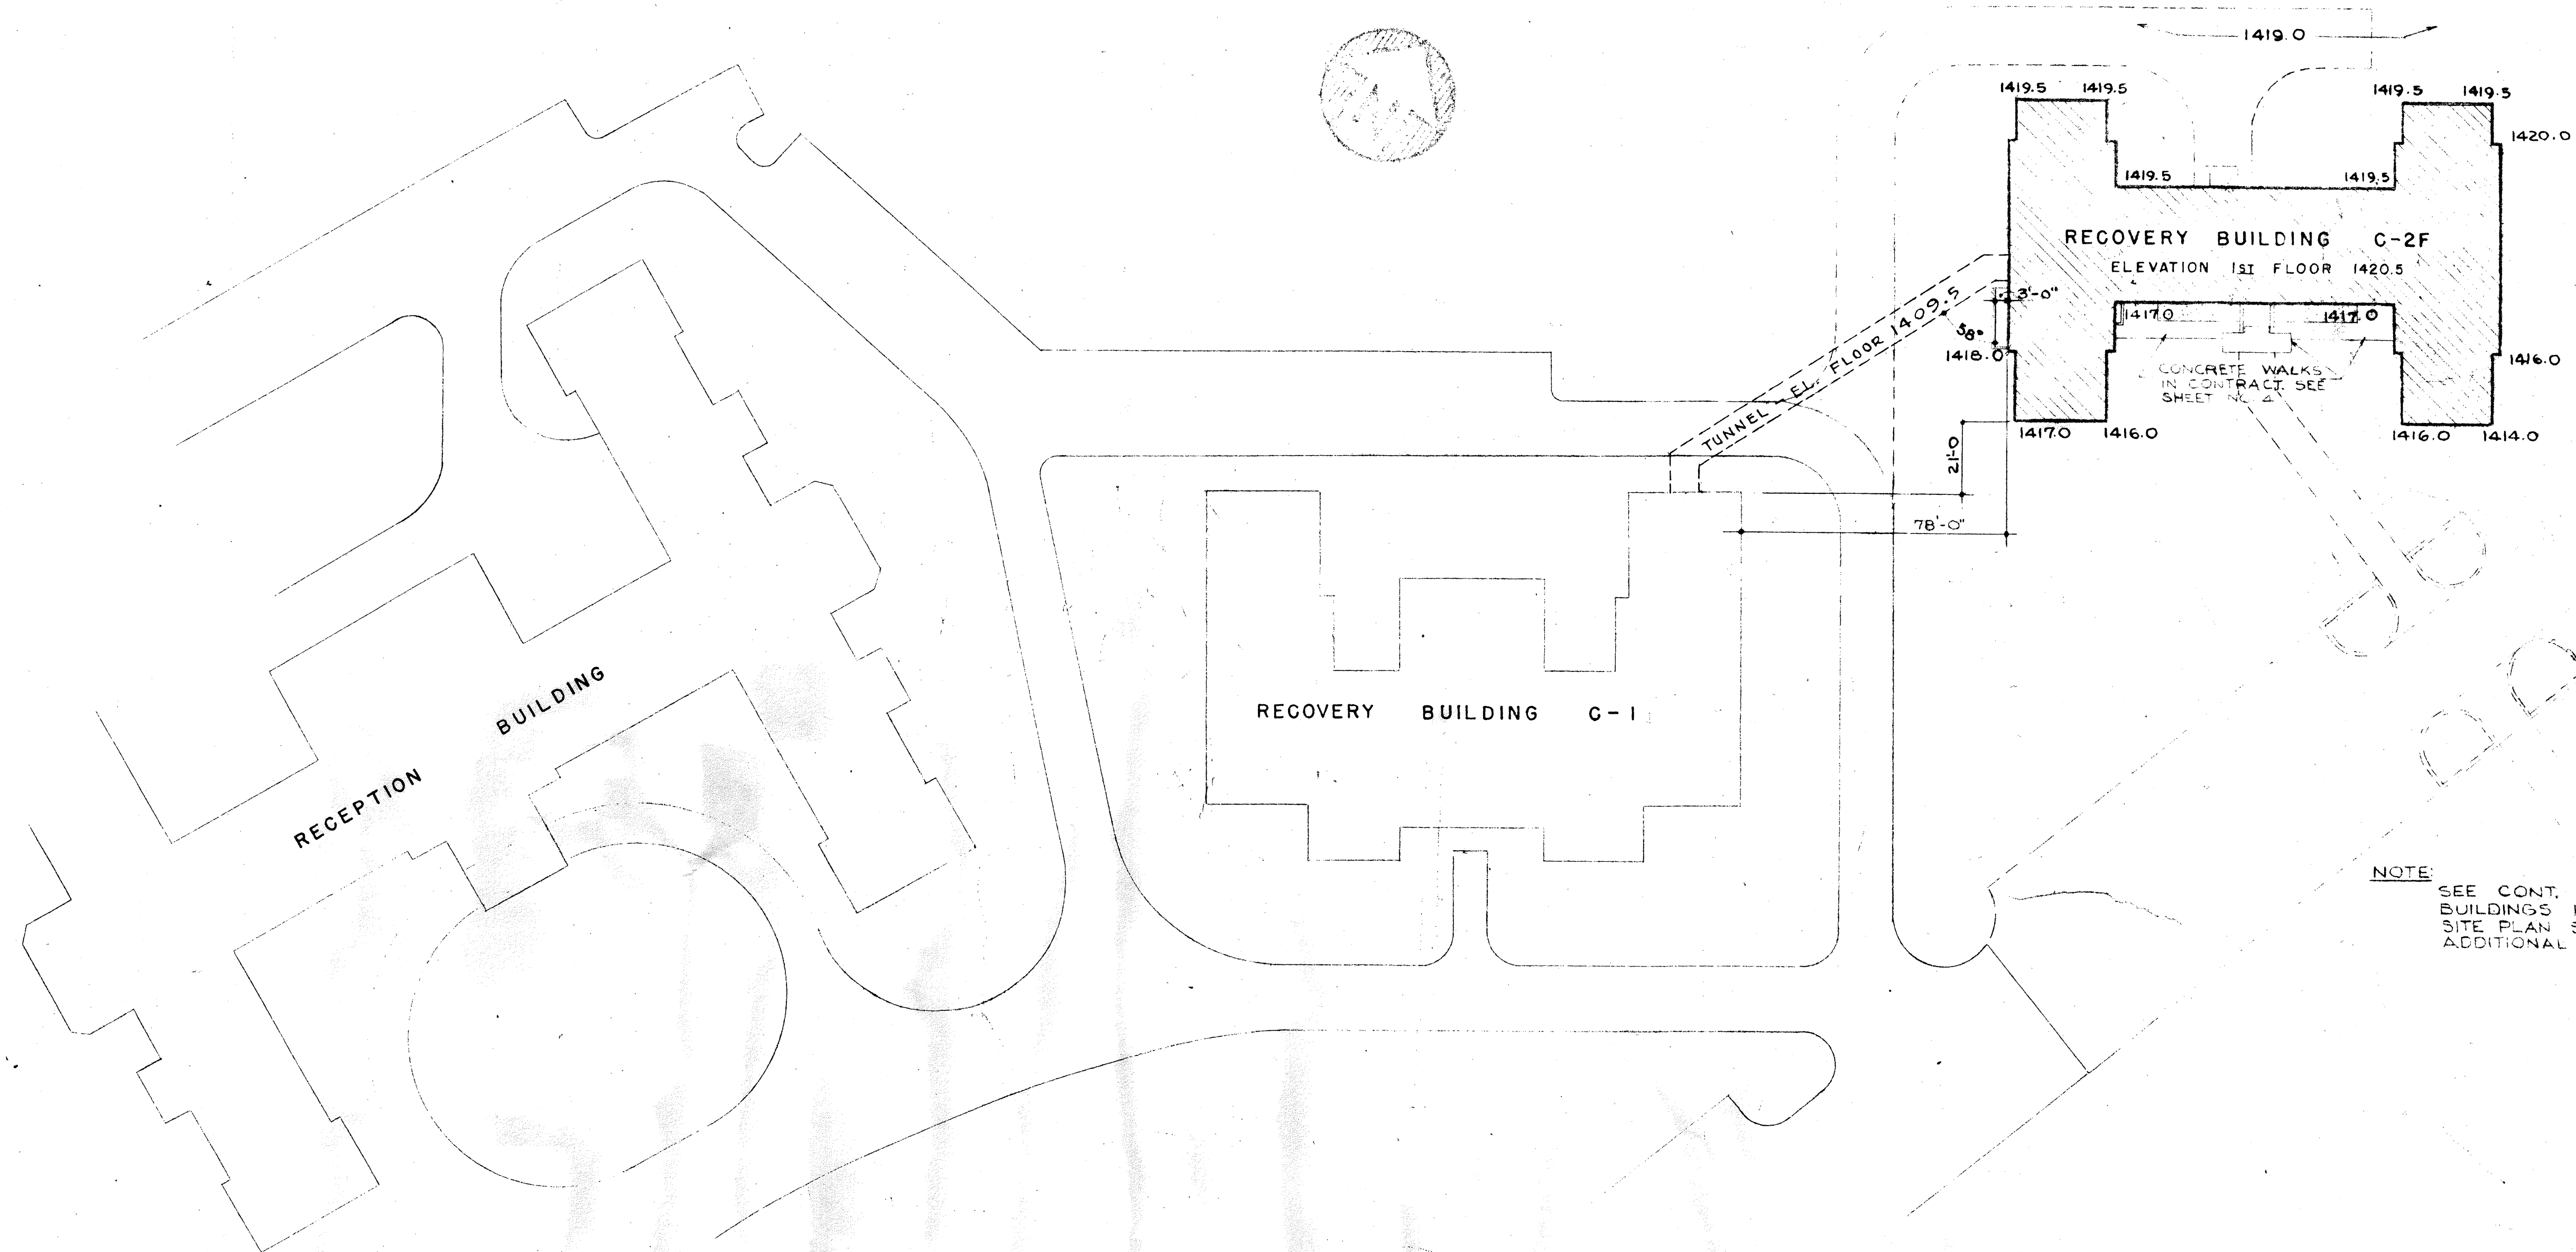

NOTE:
SEE CONT. TREATMENT
BUILDINGS K2-C & K2D
SITE PLAN SHEET FOR
ADDITIONAL INFORMATION.

PLOT PLAN

SCALE: 1" = 30'-0"

DEPARTMENT OF MENTAL HYGIENE AND HOSPITALS

DR. HIRAM W. DAVIS - COMMISSIONER

WESTERN STATE HOSPITAL, STAUNTON, VIRGINIA

DR. JAMES B. PETTIS - SUPERINTENDENT

STRUCTURAL: REVISED AND SITE ADAPTED
BY
TORRENCE AND DREELIN - CONSULTING ENGINEERS
MECHANICAL: REVISED AND SITE ADAPTED
BY
WILEY AND WILSON - CONSULTING ENGINEERS

HENRY W. ROBERTS
CONSULTING STRUCTURAL ENGINEER
RICHMOND, VIRGINIA





LANIER & LEVY, INC.
CONSULTING MECHANICAL ENGINEERS
WASHINGTON, D. C.

B-115
RECOVERY BUILDING C-2F

DATE
SEPT. 1958
REVISED
"AS BUILT"
NOV. 1960

MARCELLUS WRIGHT & SON
ARCHITECTS
100 EAST MAIN STREET
RICHMOND, VIRGINIA

SHEET
1
OF 12

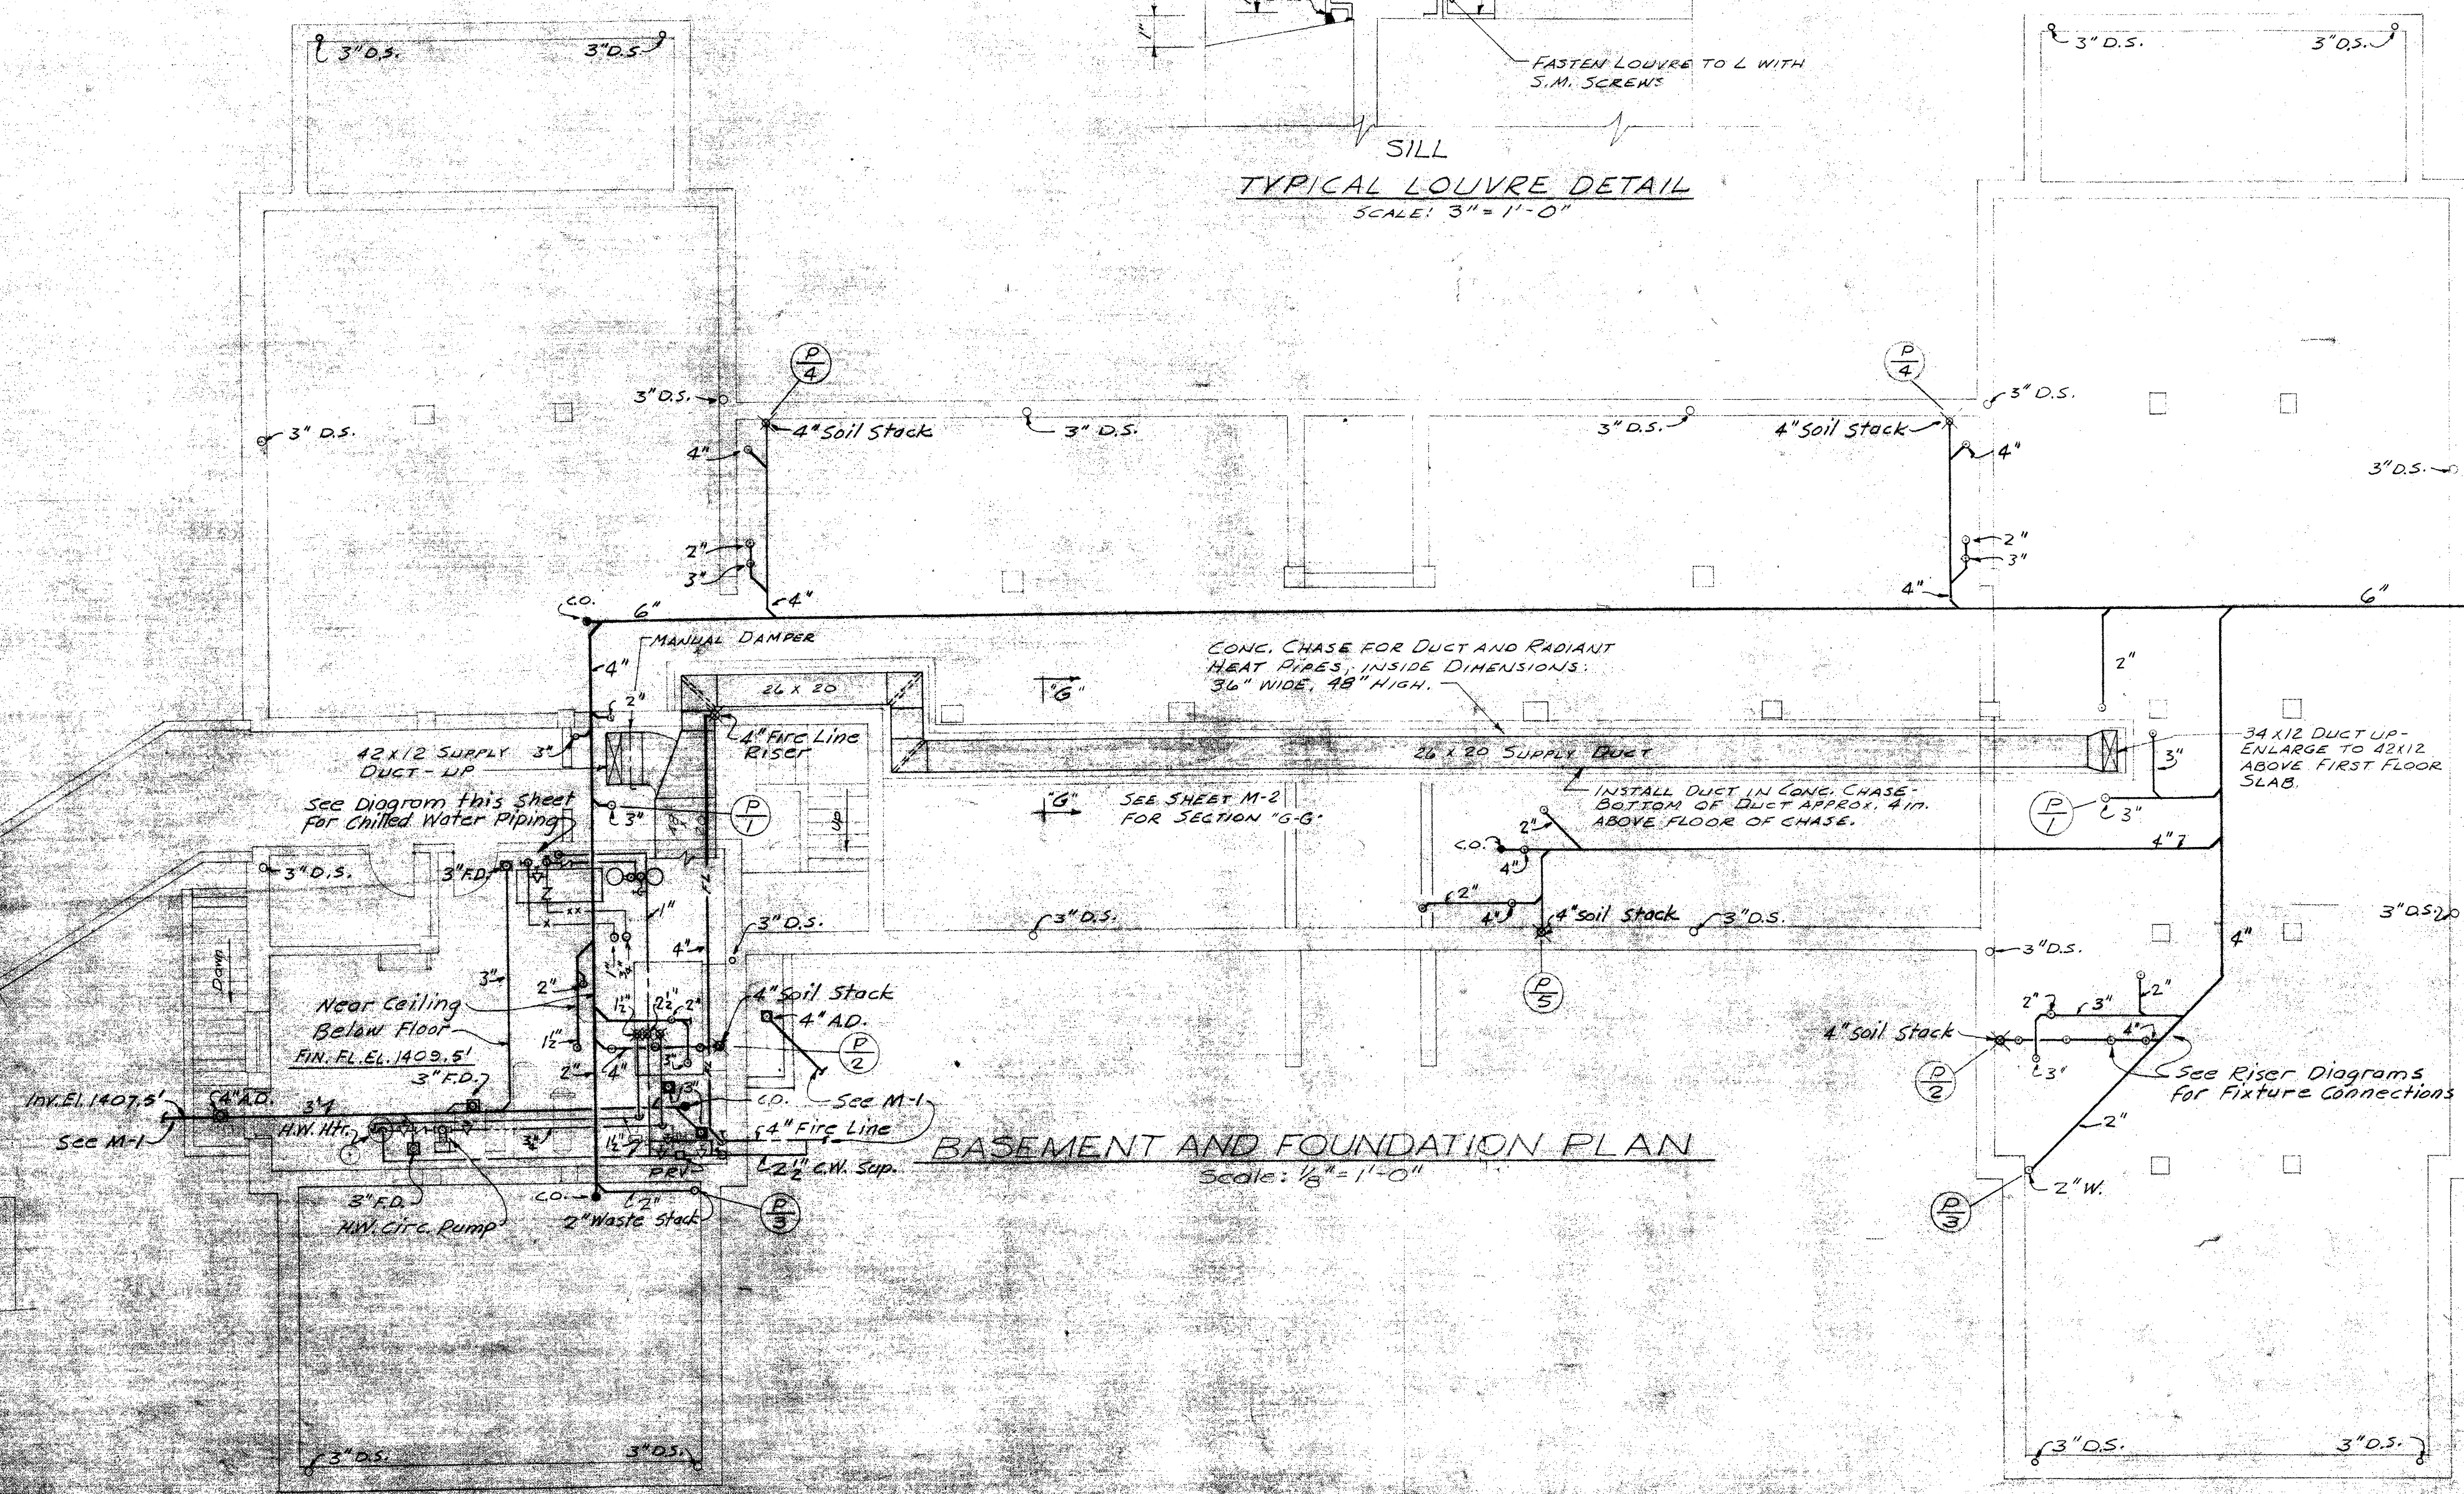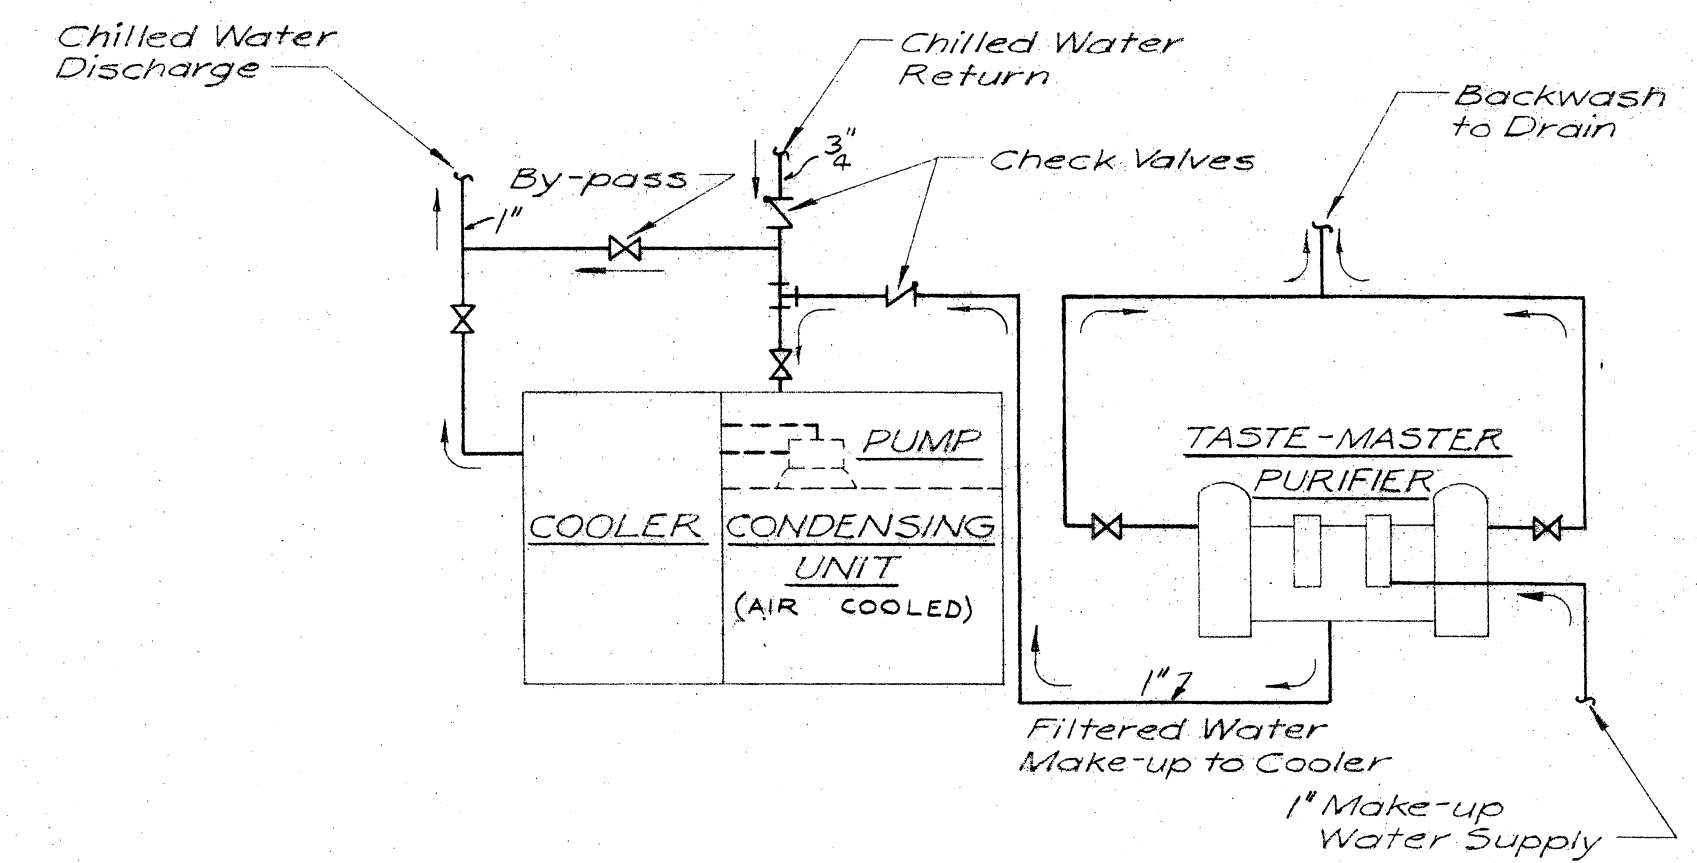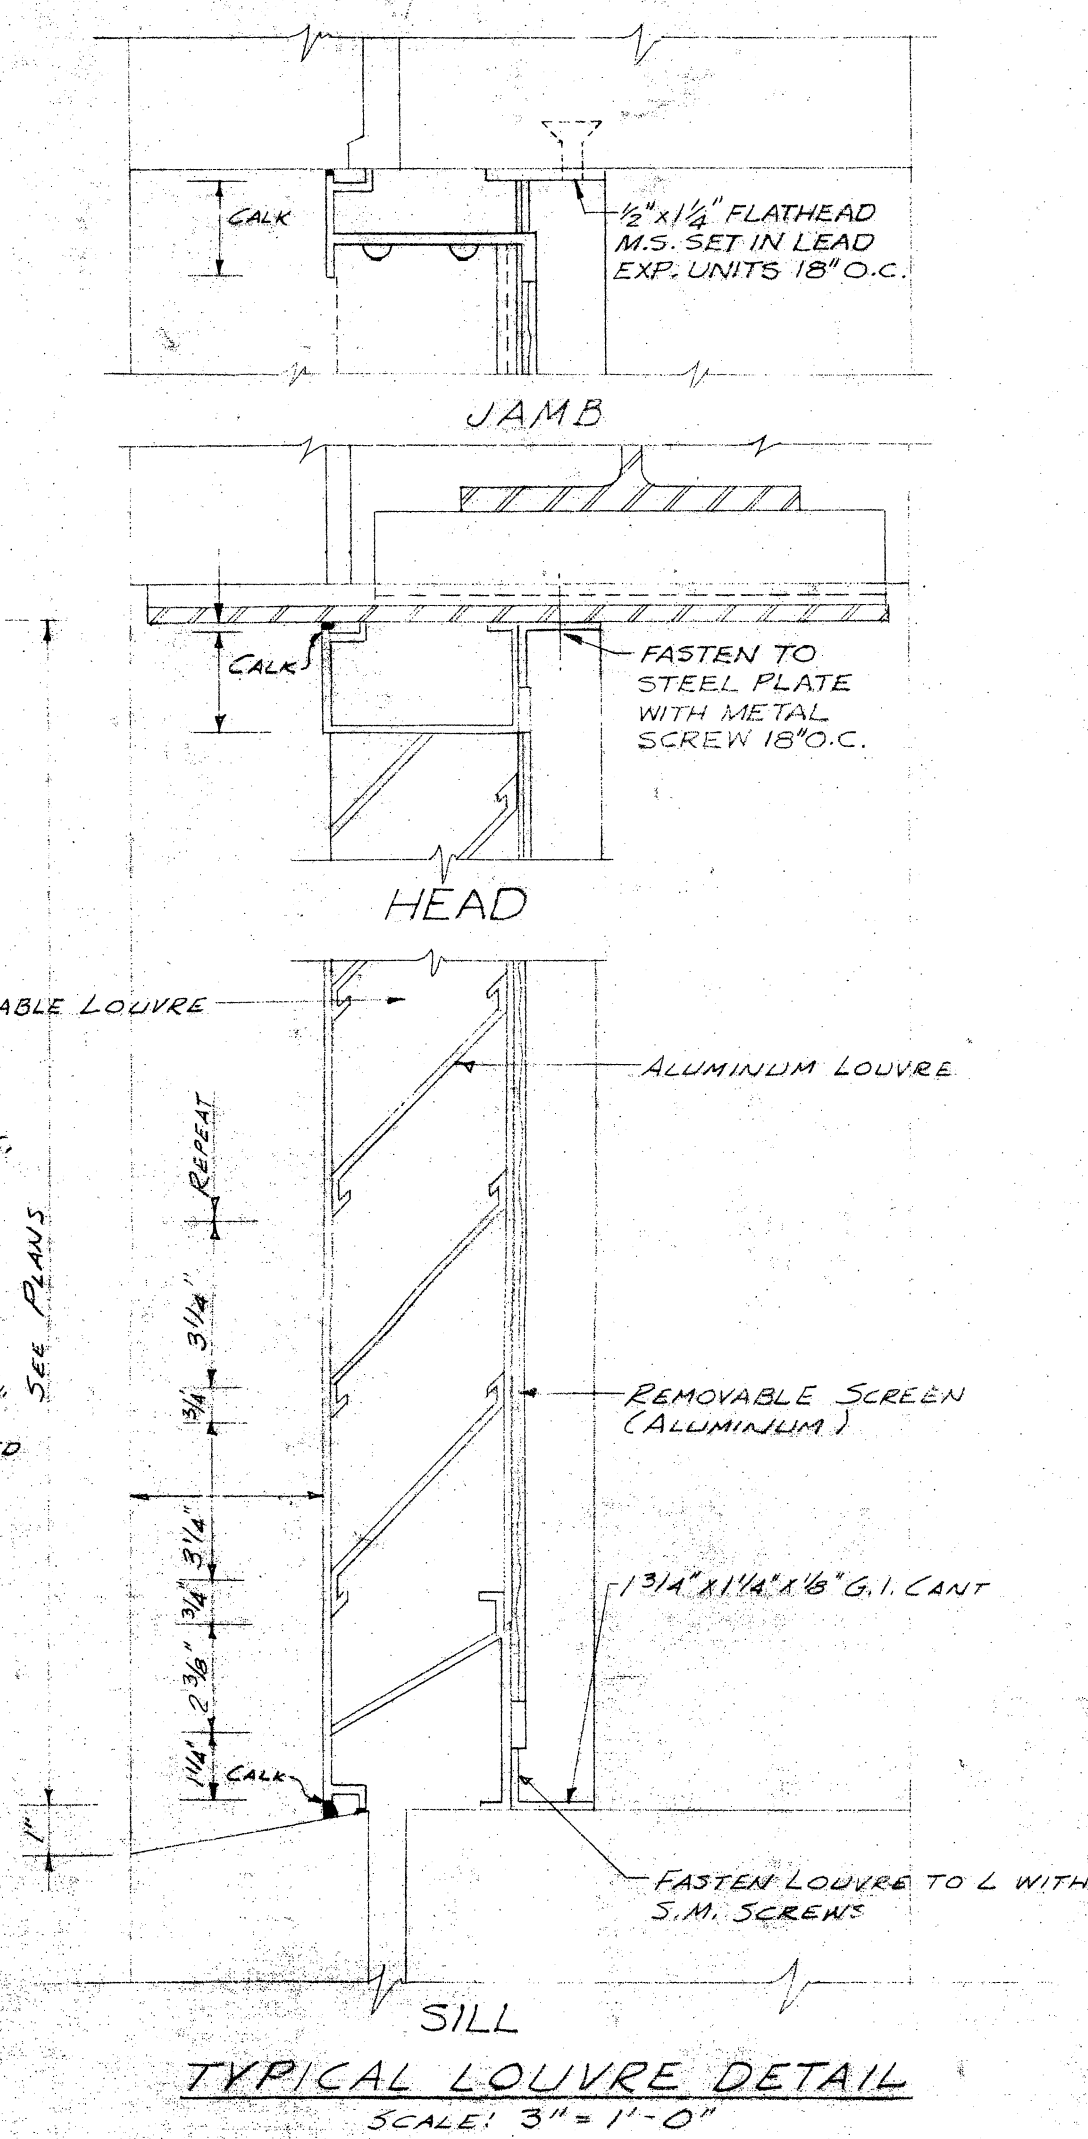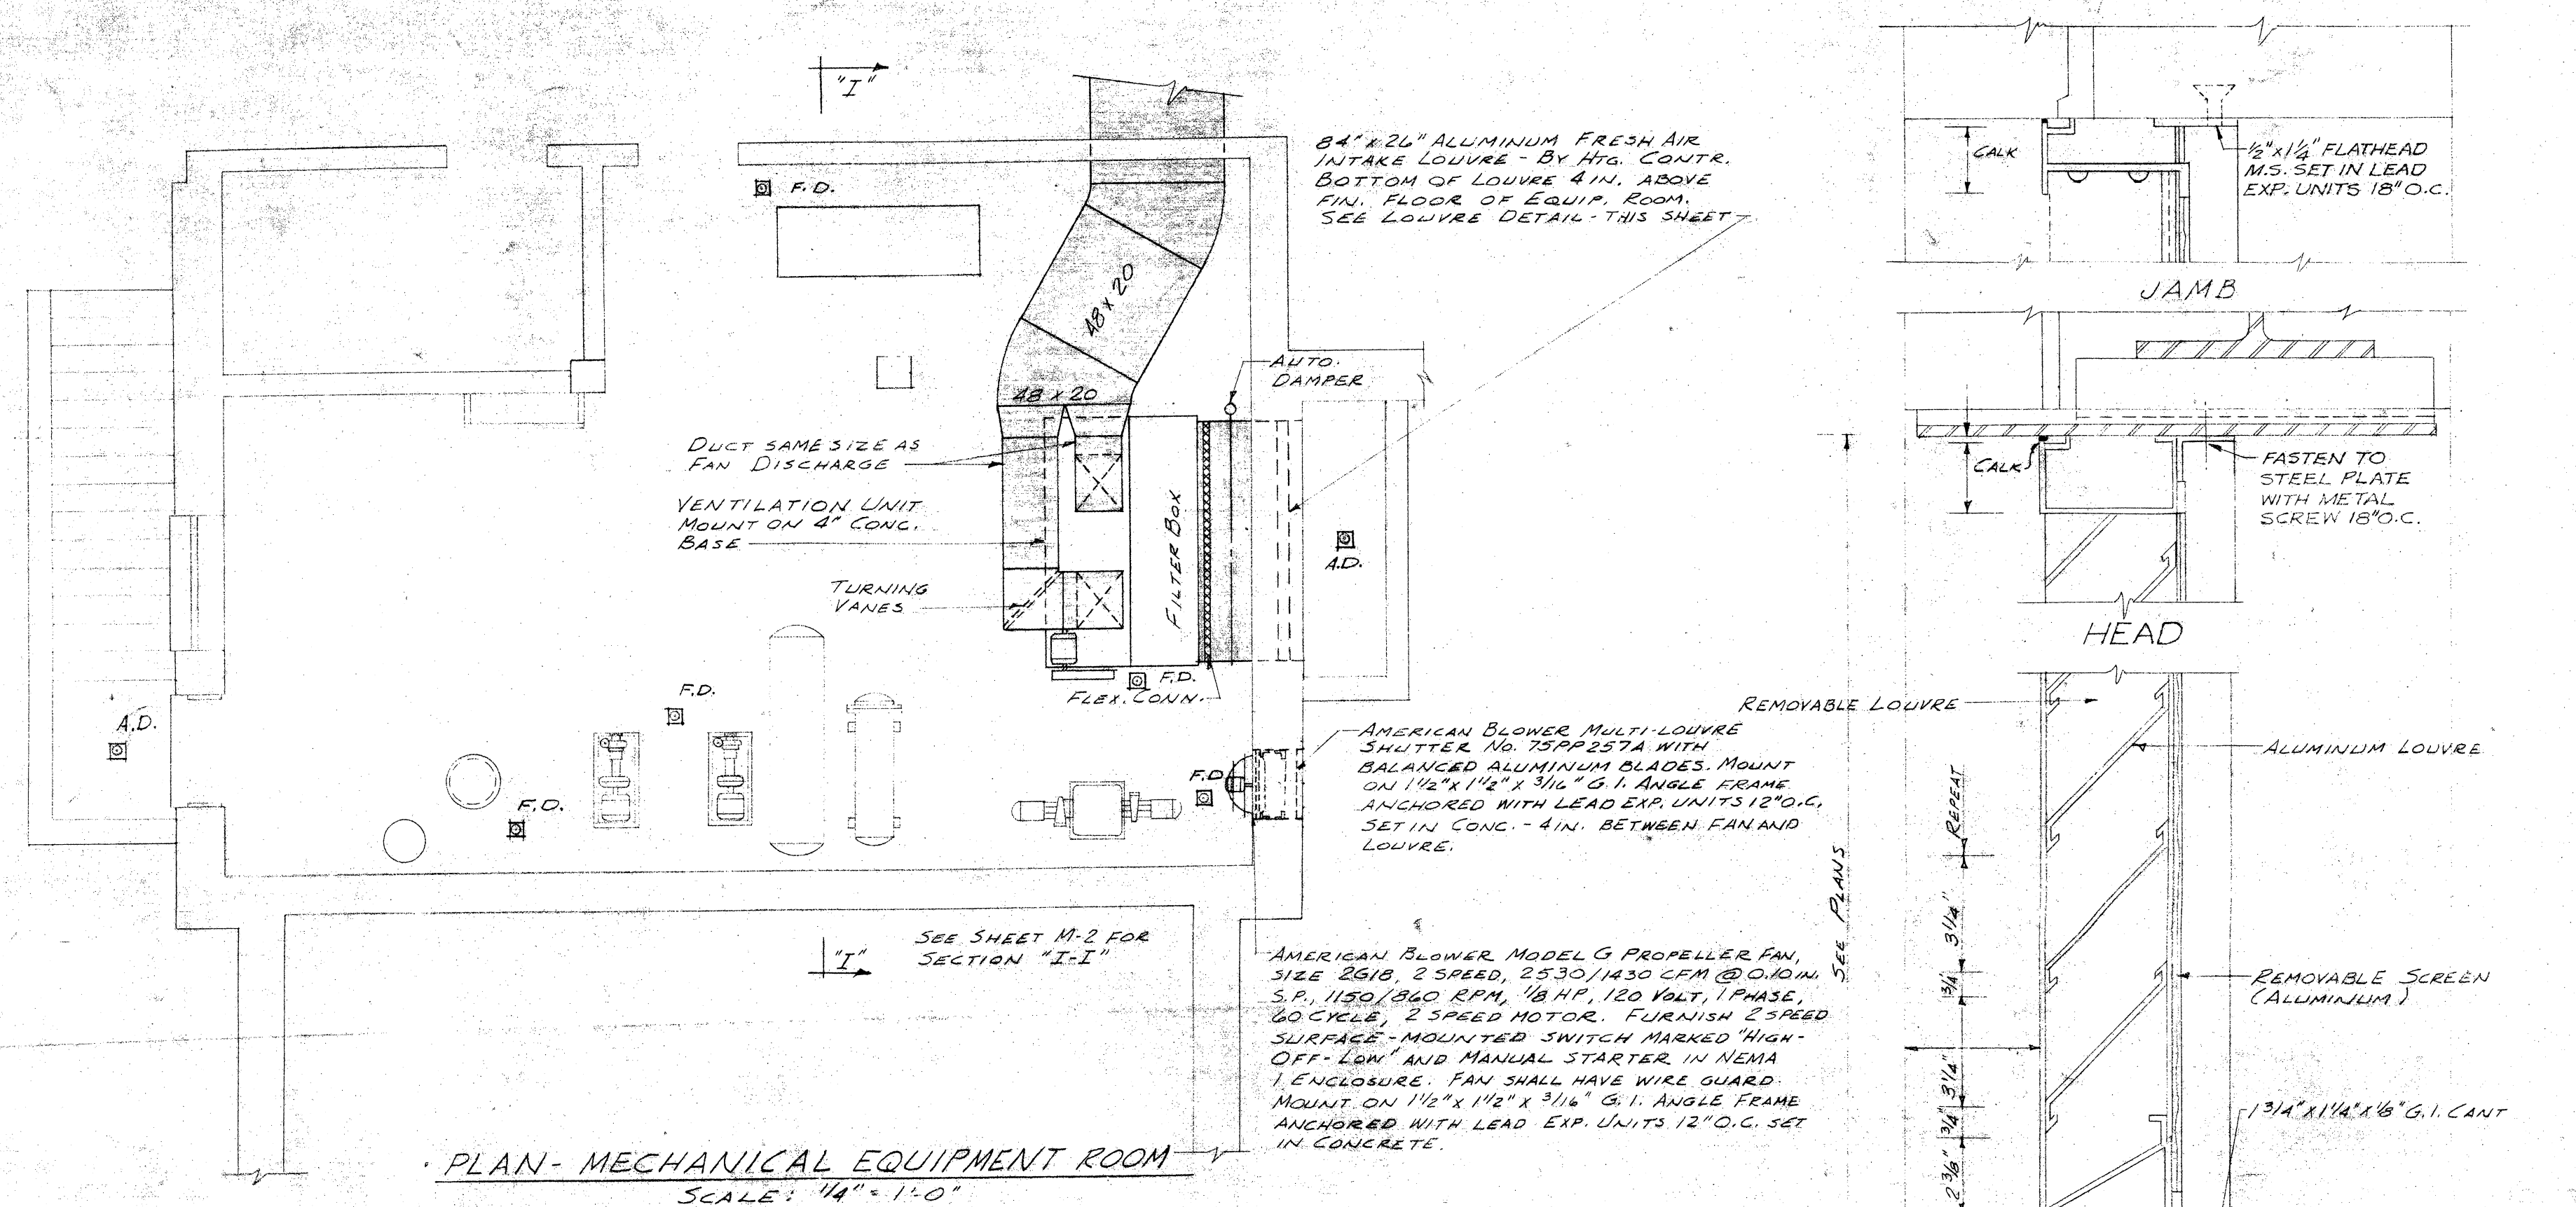

NOTE: STANDARD DETAILS 1-5 INCL.
BOUND AS PART OF SPECIFICATIONS
APPLY TO THESE DRAWINGS.

WILEY & WILSON
CONSULTING ENGINEERS
LYNCHBURG, VA. - RICHMOND, VA.

PLUMBING AND VENTILATION BASEMENT PLAN		
RECOVERY BUILDING C-2F		
WESTERN STATE HOSPITAL WAYNESBORO ROAD STAUNTON VIRGINIA		
DATE SEPT 1958 REVISED AS BUILT NOV 1960	MARCELLUS WRIGHT & SON ARCHITECTS 100 EAST MAIN STREET RICHMOND, VIRGINIA	SHEET M  OF 11