


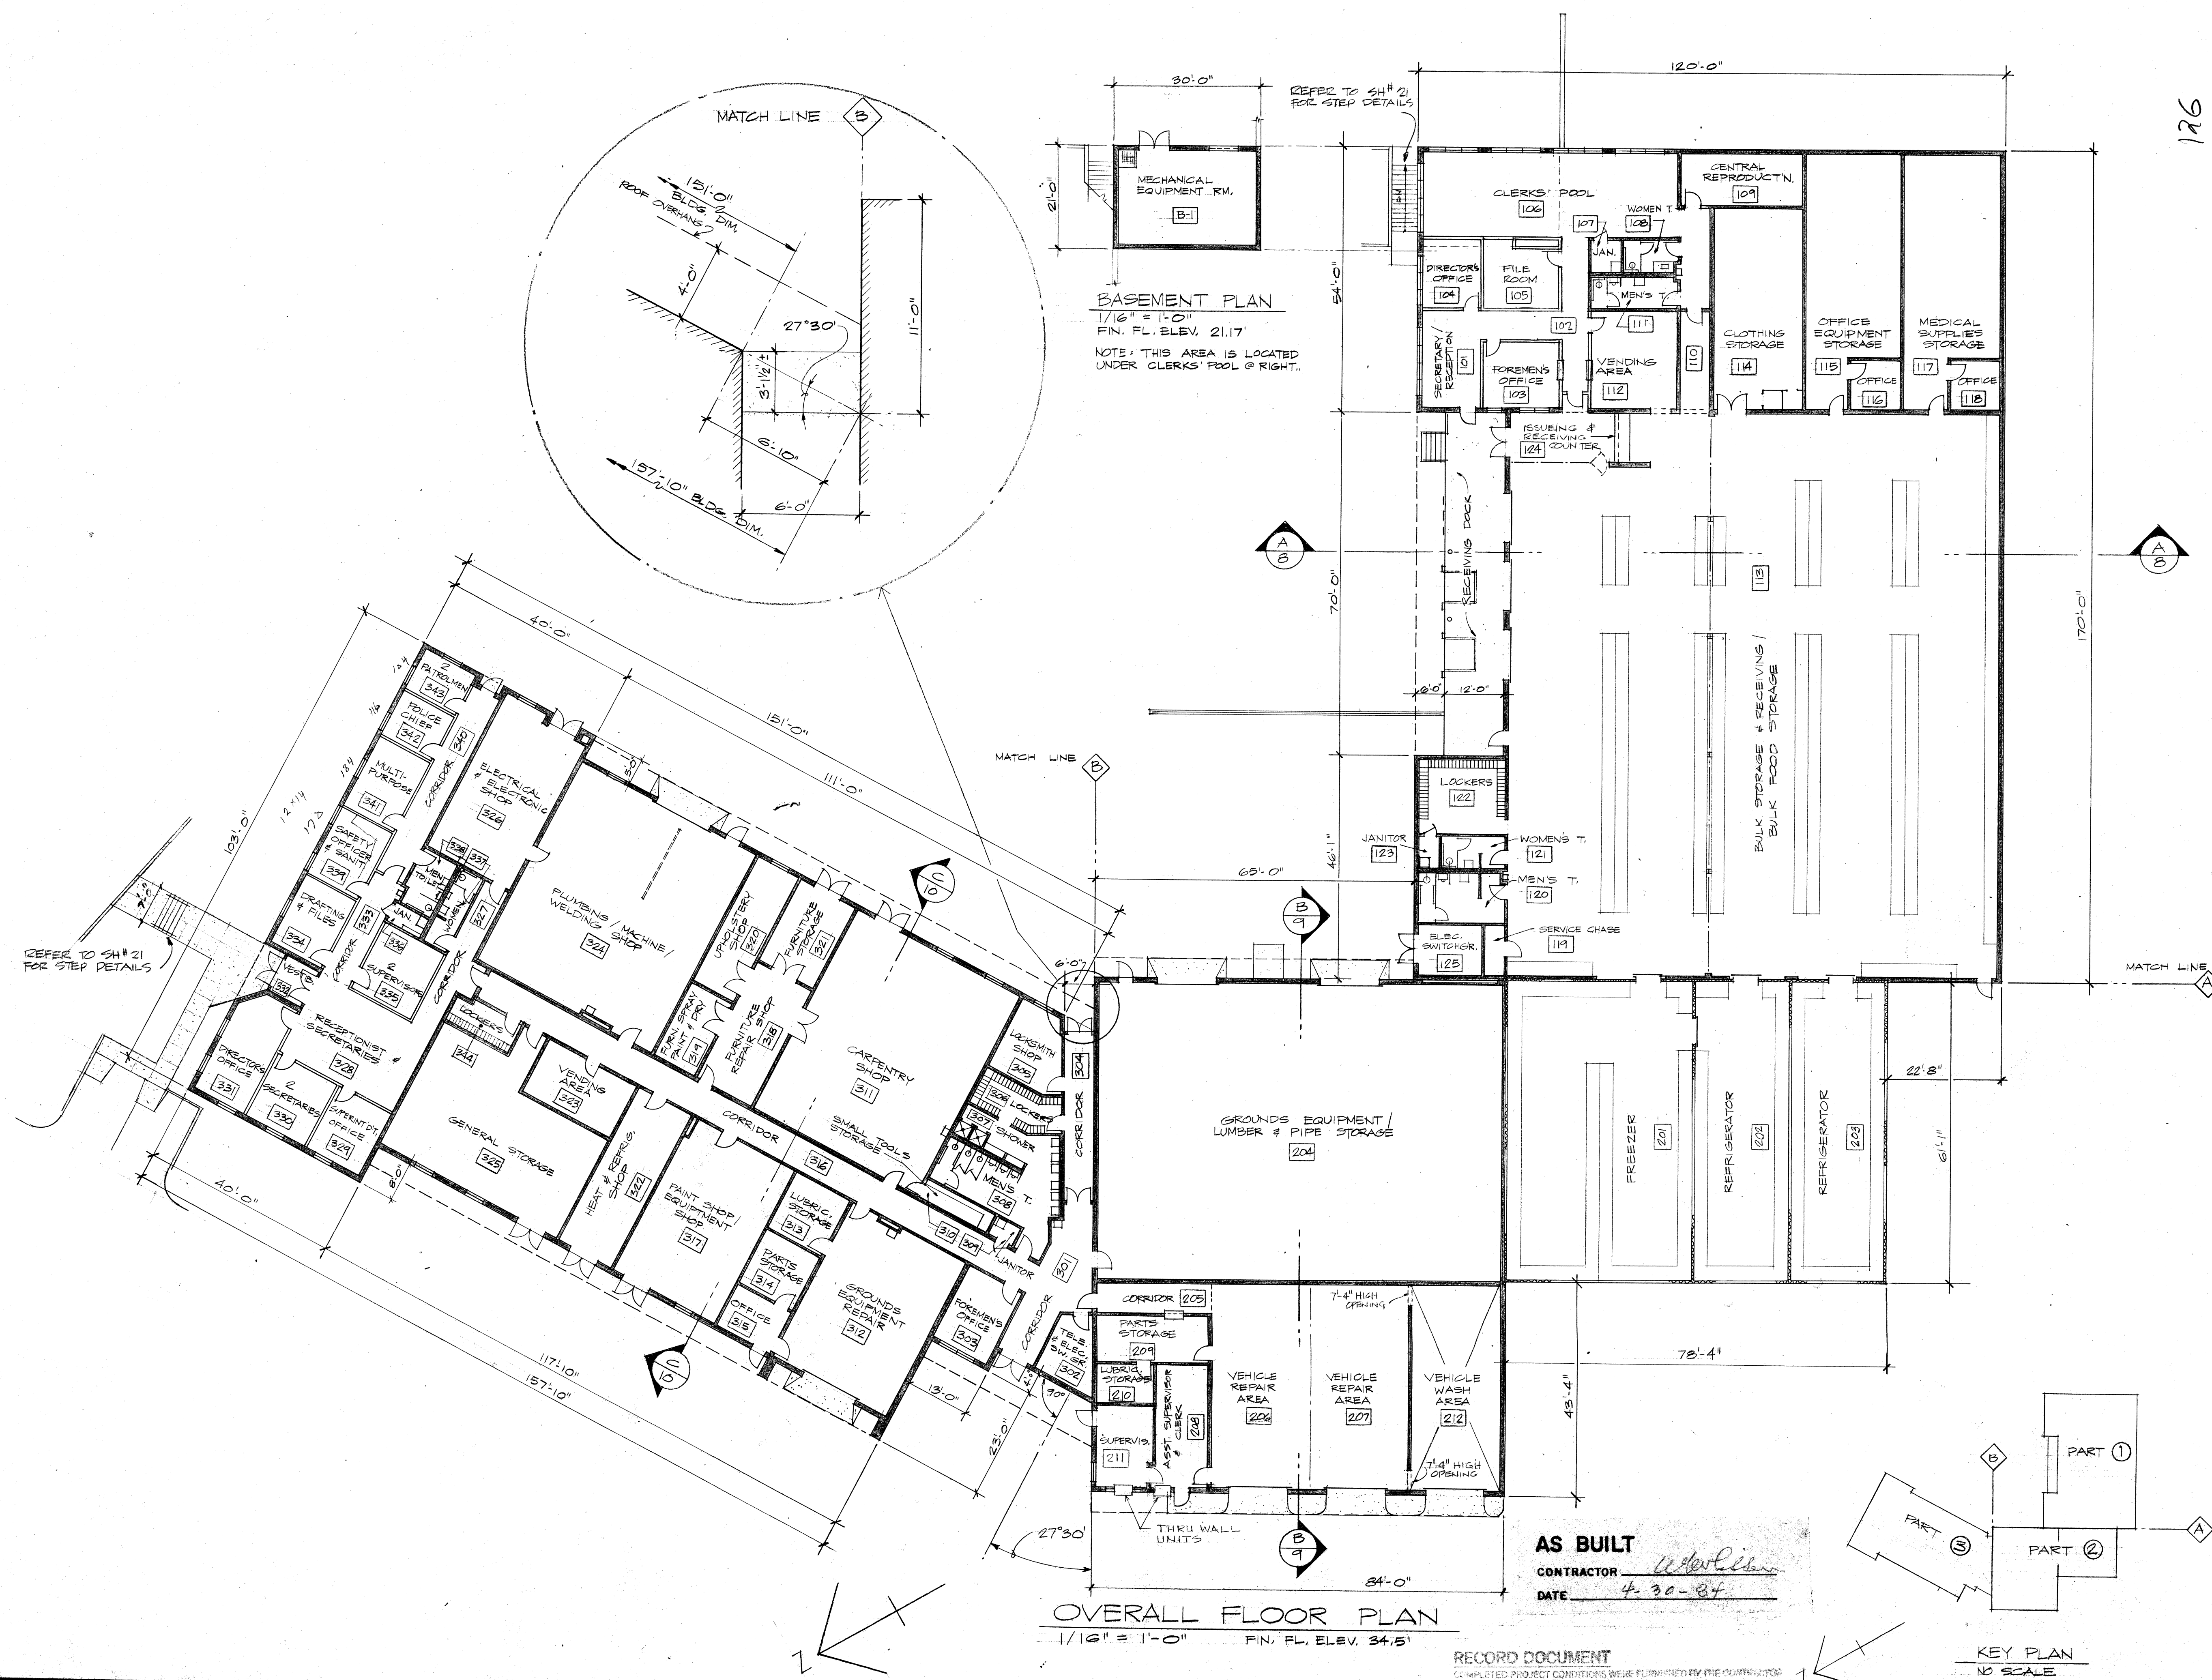

ben r. johns, jr.
 five west grace street
 richmond, virginia 23220 architect, aia
 (804) 644-7867

WAREHOUSE, MAINTENANCE
 SHOPS & MOTOR POOL
 FACILITY
 for
 WESTERN STATE HOSPITAL
 STAUNTON, VA.
 PROJECT NO. 706-10326

DRAWN/CHECKED

LCH

COMMISSION NO.

8102

ISSUE DATE

AUG 31, '81

SCALE

1/16" = 1'-0"

OVERALL
FLOOR PLAN2
OF
23